


SYMBOLS LEGEND

- CW COLD WATER PIPEWORK - NEW
- HW HOT WATER PIPEWORK - NEW
- TW TEPID WATER PIPEWORK - NEW
- HW HOT WATER SERVICE (SMALL) - NEW
- PIPework/CONDUIT DROPPER/RISE - NEW
- VALVE (ISOLATION IN BOX) - NEW
- + VALVE (ISOLATION) - NEW
- + VALVE (TAP-DOUBLE) - NEW
- + VALVE (TAP-SINGLE) - NEW
- VALVE (THERMOSTATIC MIXING) - NEW

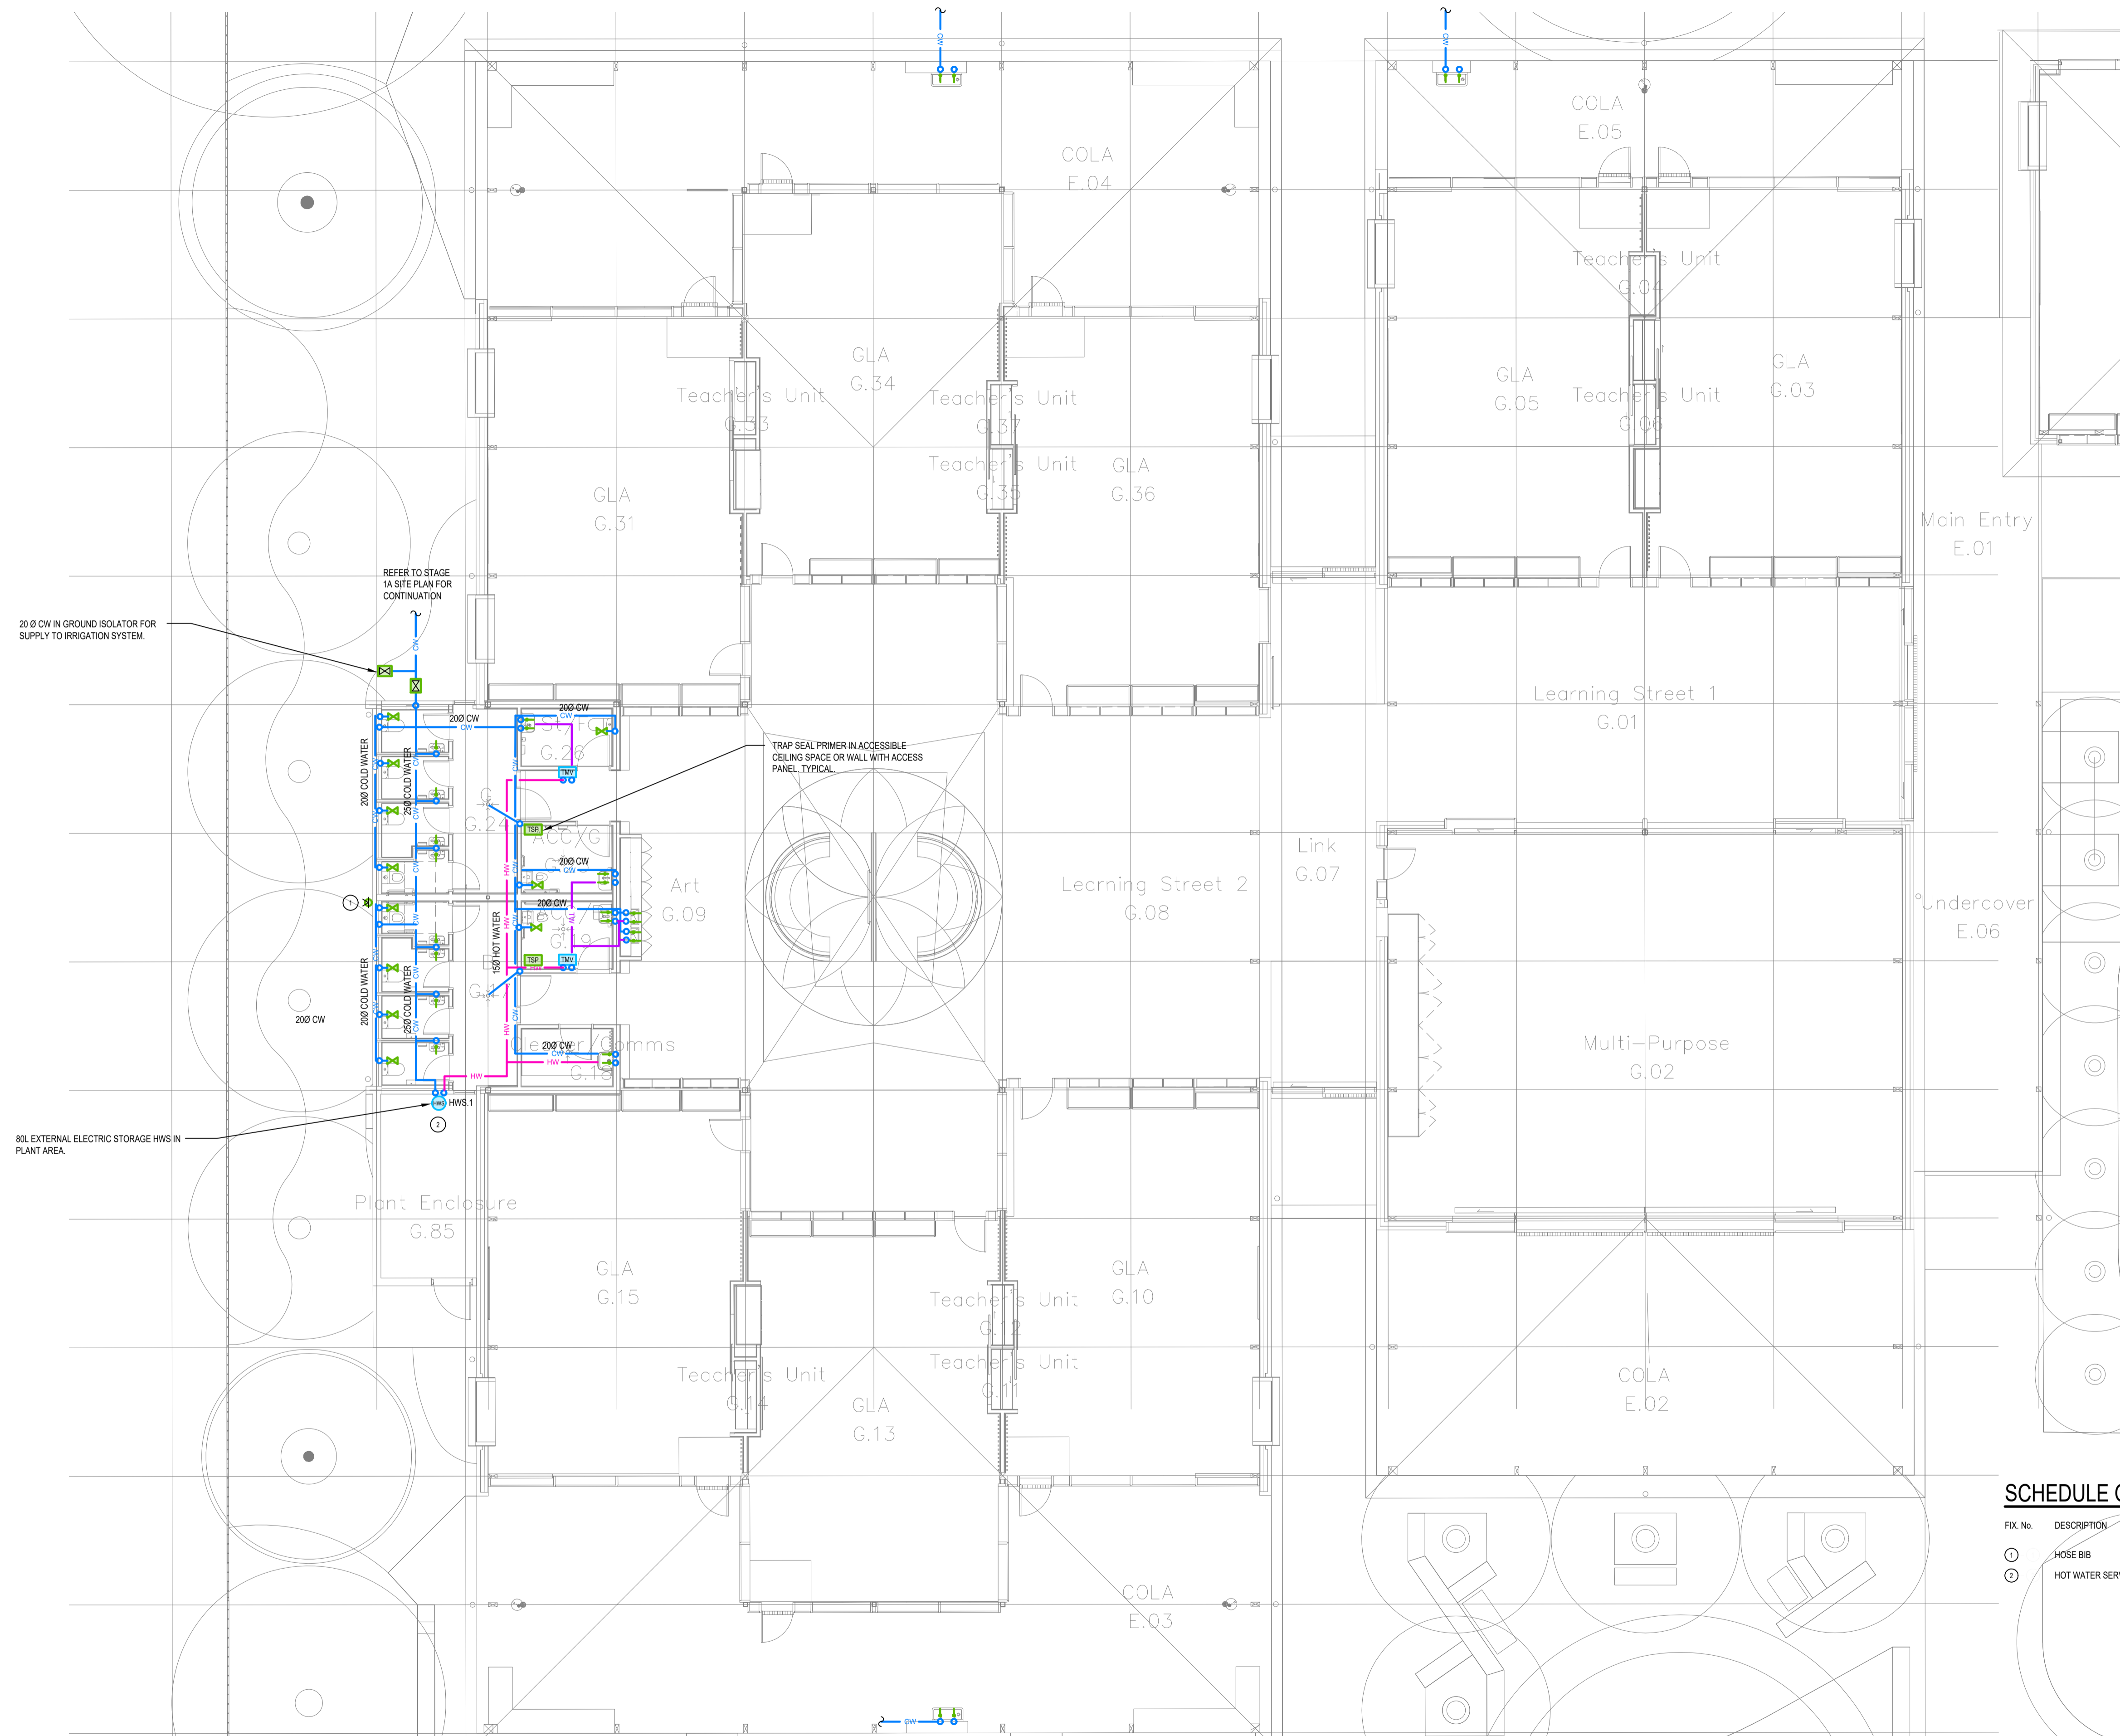

SCHEDULE OF SANITARY FIXTURES

FIX. No.	DESCRIPTION	No. OFF	WASTE SIZE	COLD WATER CONNECTION	HOT WATER CONNECTION	TEPID WATER CONNECTION	RAIN WATER CONNECTION
①	HOSE BIB	1	N/A	150	N/A	N/A	N/A
②	HOT WATER SERVICE	1	TO TUNDISH	200	200	N/A	N/A

THIS DRAWING IS REQUIRED TO BE PRINTED IN COLOUR. FAILURE TO DO SO MAY RESULT IN LOSS OF INFORMATION.

01	INITIAL TENDER ISSUE	20/08/2023	DW
REV	DESCRIPTION OF ISSUE	DATE	INITIAL
1:500	0m 10m 20m 30m	22.5m	
1:200	1m 2m 3m 5m 7.5m 10m 15m 18m	18m	
1:100	1m 2m 3m 4m 5m 6m 7m 8m 9m	9m	

Notes

- THIS DRAWING IS STRICTLY COPYRIGHT & SHALL NOT BE COPIED IN WHOLE OR IN PART WITHOUT THE WRITTEN CONSENT OF BRT CONSULTING ENGINEERS.
- CONTRACTOR MUST VERIFY ALL DIMENSIONS ON SITE BEFORE COMMENCING ANY WORK OR PREPARING ANY SHOP DRAWINGS.
- CONTRACTOR TO REFER TO ARCHITECTS REFLECTED CEILING PLANS & DETAIL DRAWINGS FOR EXACT LOCATION OF FITTINGS AND EQUIPMENT.
- WRITTEN DIMENSIONS TAKE PRECEDENCE OVER SCALED DIMENSIONS.
- THIS DRAWING IS REQUIRED TO BE PRINTED IN COLOUR. FAILURE TO DO SO MAY RESULT IN LOSS OF INFORMATION.

BRT Consulting Pty Ltd
 159 Victoria Parade
 Collingwood VIC 3066
 03 9417 2971
 melb@brt.com.au

PMDL **mcglashan everist**

pmdl-mea.com.au

PMDL ARCHITECTURE - DESIGN (M/G, M/ED)
PMDL ARCHITECTURE - DESIGN (P/V, L/T, A/R) 88 042 967 377

Project THE SCOTS SCHOOL - STAGE 1 393 PERRY STREET ALBURY				Title HYDRAULIC SERVICES GROUND FLOOR PLAN - STAGE 1A HOT & COLD WATER LAYOUT			
Scale	Creation Date	Drafter	Engineer	Director	Stage Description	Job No	Dwg No
1:100 @ A1	21/03/2024	DG	DW	AG	TI-TENDER ISSUE	12132	H200

Stage	Rev.
TI	01