



IF A RAINWATER HARVESTING SYSTEM HAS BEEN NOMINATED ON THESE PLANS, THE DESIGN HAS BEEN DOCUMENTED TO COMPLY WITH COUNCIL REQUIREMENTS AND THE ESD CERTIFICATE (IF APPLICABLE) WHICH WAS PROVIDED TO PARTRIDGE AT THE TIME OF PREPARING THIS DOCUMENTATION. WE RECOMMEND THAT THE RE-USE REQUIREMENTS FOR THE RAINWATER SYSTEM BE VERIFIED BY THE PRINCIPAL CERTIFYING AUTHORITY **PRE-TO ANY CONSTRUCTION WORKS COMMENCING ON SITE**. PARTRIDGE TAKES NO RESPONSIBILITY FOR ANY RAINWATER RE-USE DESIGN ALTERATIONS CAUSED BY CHANGES DIRECTED BY OTHERS OR AMENDMENTS TO THE ESD CERTIFICATE AFTER THE RELEASE OF THE STORMWATER DOCUMENTATION.


TENDER ISSUE		F.S.	A.H.	14.08.26
Rev.	Issue / Amendment	By	App.	Date
 partridge.com.au partridge@partridge.com.au Partridge Hydraulic Pty Ltd ABN 71 124 297 883 Copyright: The design and details shown on this drawing are specific to this project only and may not be reproduced in whole or in part or be used for any other project or purpose without the written consent of Partridge Structural Pty Ltd.				
Client ZOOS VICTORIA				
architect INNOVA GROUP 475C SAINT KILDA STREET, VIC.3184 TEL 1300308059				
Project SOUTHWEST WILDLIFE HOSPITAL 75 LAKE ROAD KYABRAM, VIC 3620				
Title COVER PAGE				
DO NOT SCALE: USE FIGURED DIMENSIONS				
The presence of this signature signifies that this is the certified drawing issued for construction.	Designed A.H.		Drawn F.S.	
	Job No. 2020SA0498		Scale at A1 N/A	
Date AUG 2026	Drawing No. SW1.0			
FOR TENDER -NOT FOR CONSTRUCTION				

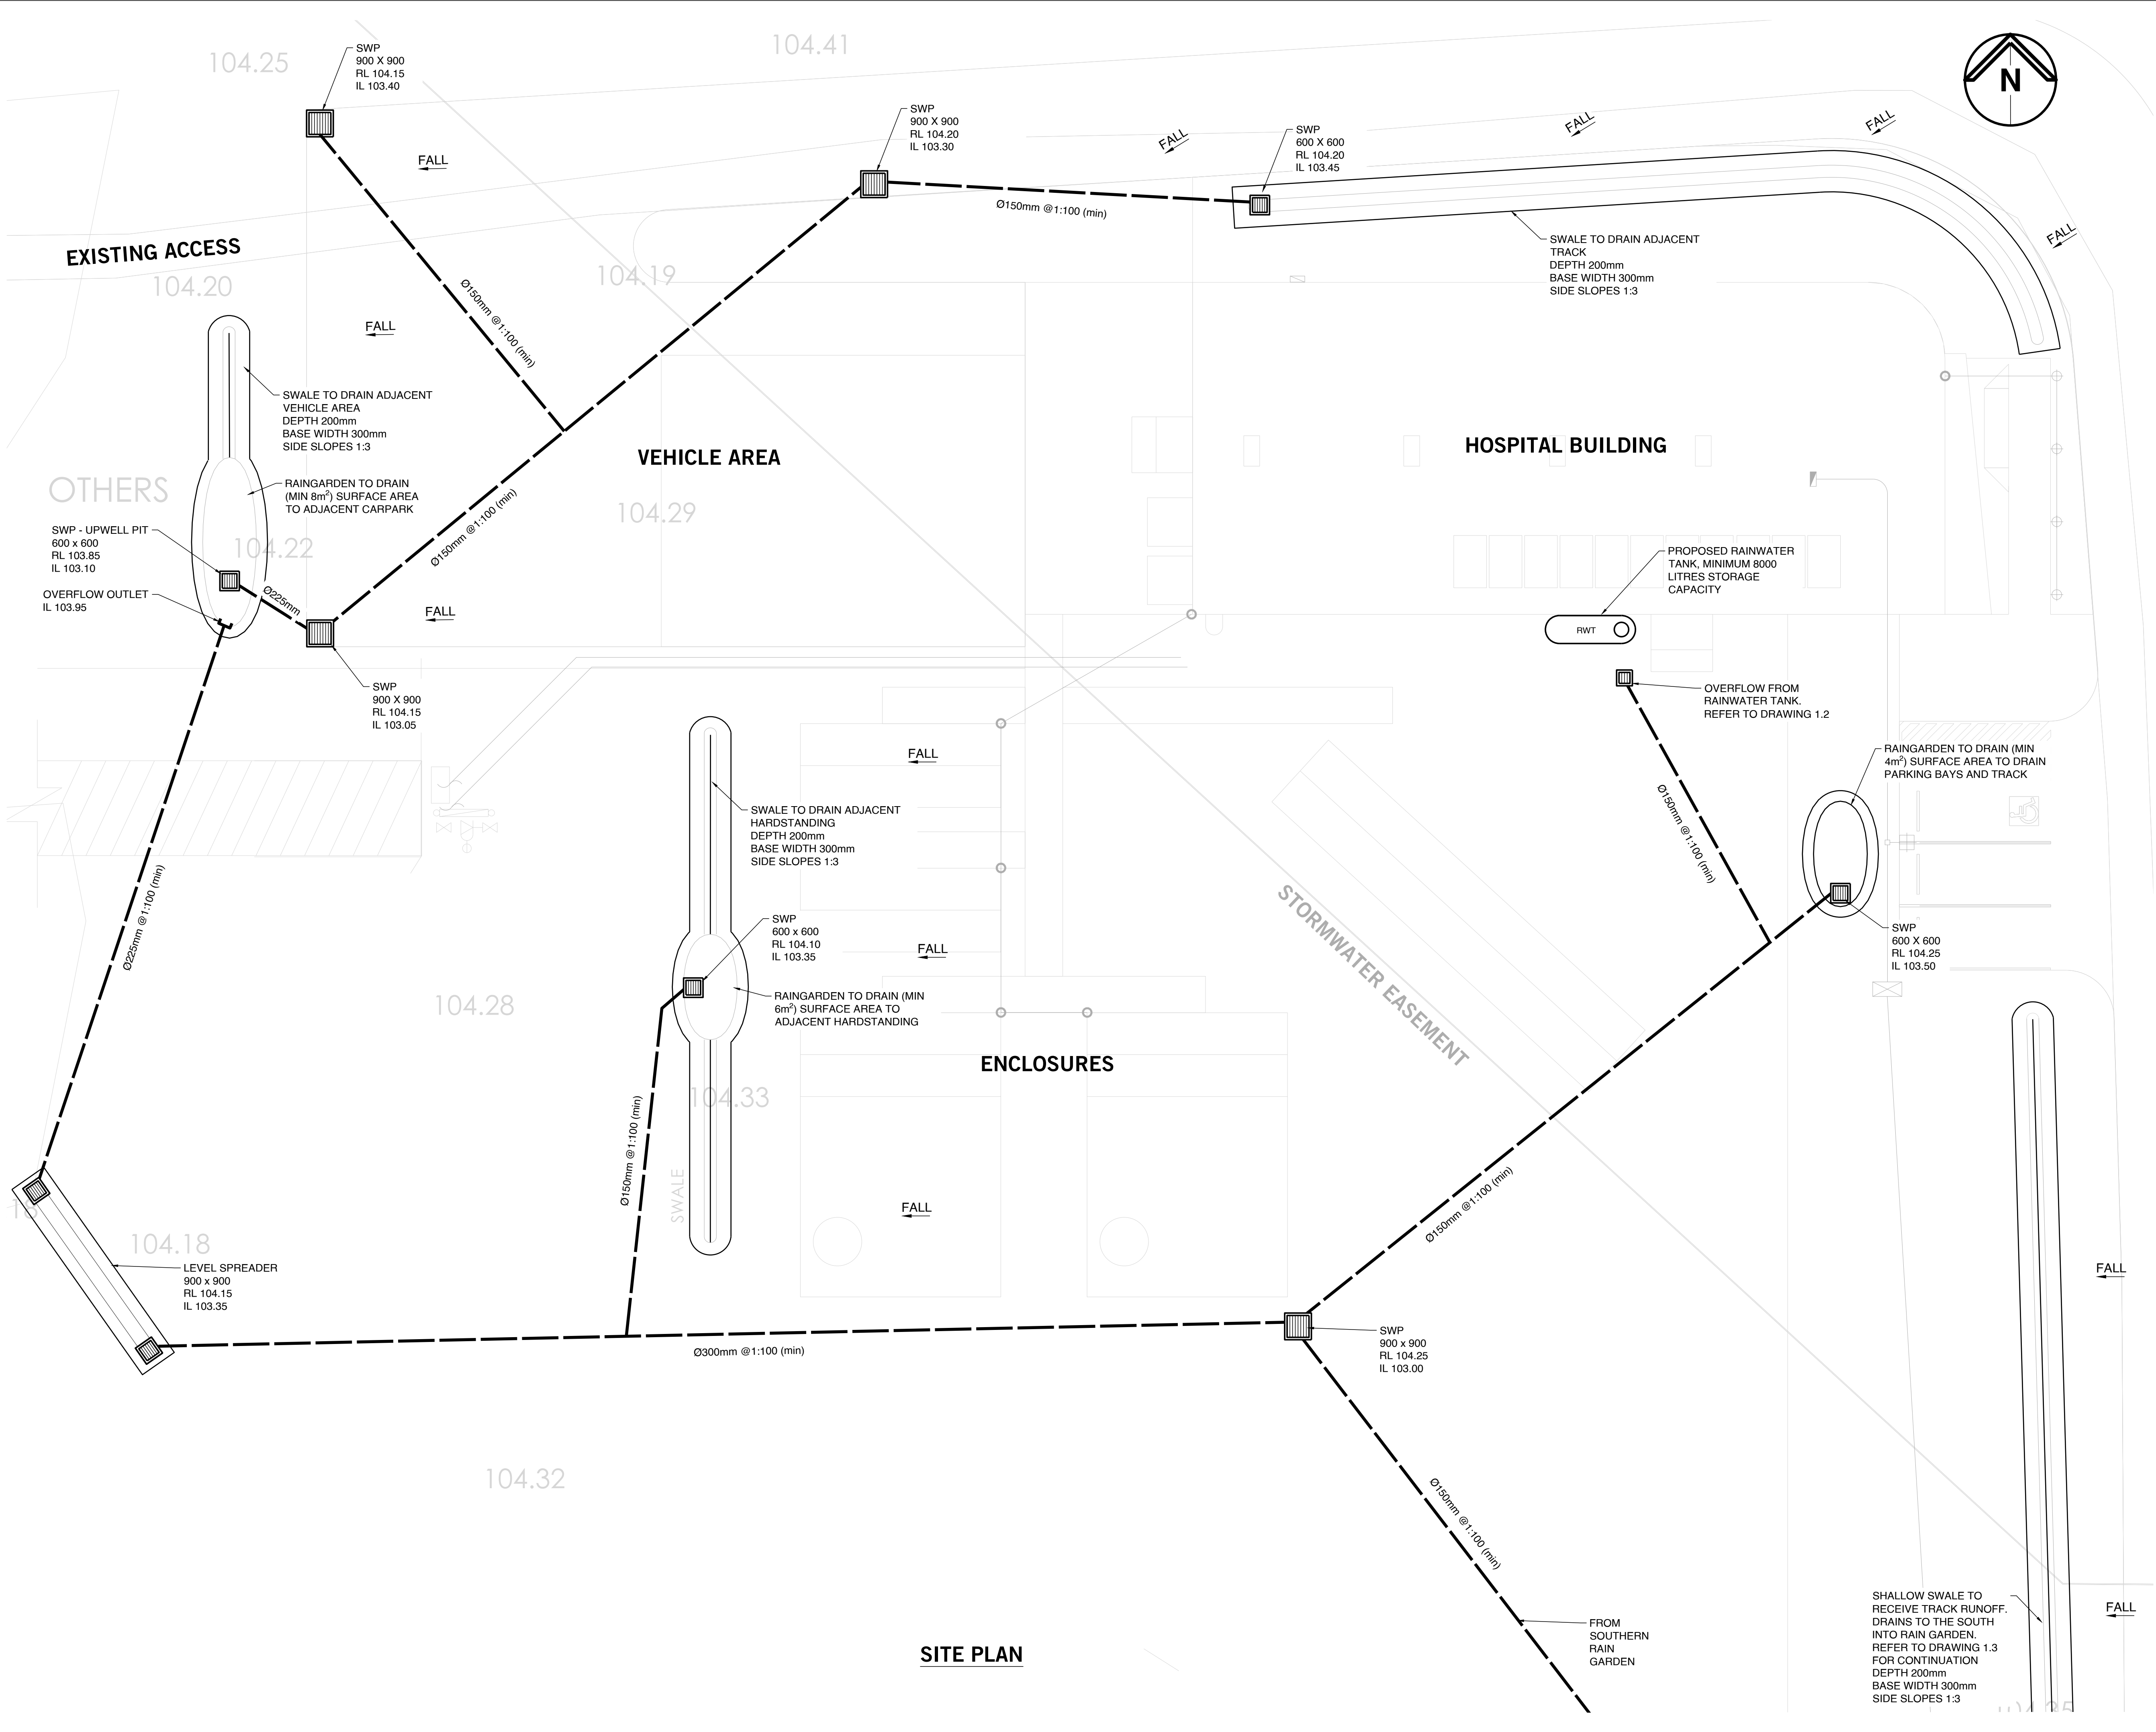

TENDER ISSUE		F.S.	A.H.	14.08.26
Rev.	Issue / Amendment	By	App.	Date
PARTRIDGE				
partridge.com.au partridge@partridge.com.au Partridge Hydraulic Pty Ltd ABN 71 124 297 883		Copyright: The design and details shown on this drawing are specific to this project only and may not be reproduced in whole or in part or be used for any other project or purpose without the written consent of Partridge Structural Pty Ltd.		
Client ZOOS VICTORIA				
architect INNOVA GROUP 475C SAINT KILDA STREET, VIC.3184 TEL 130030859				
Project SOUTHWEST WILDLIFE HOSPITAL 75 LAKE ROAD KYABRAM, VIC 3620				
Title SITE PLAN				
DO NOT SCALE: USE FIGURED DIMENSIONS				
The presence of this signature signifies that this is the certified drawing issued for construction.		Designed A.H. Job No. 2024S0498	Drawn F.S. Scale at A1 1:125	
Date AUG 2026		Drawing No. SW1.1	Revision A	
FOR TENDER - NOT FOR CONSTRUCTION				

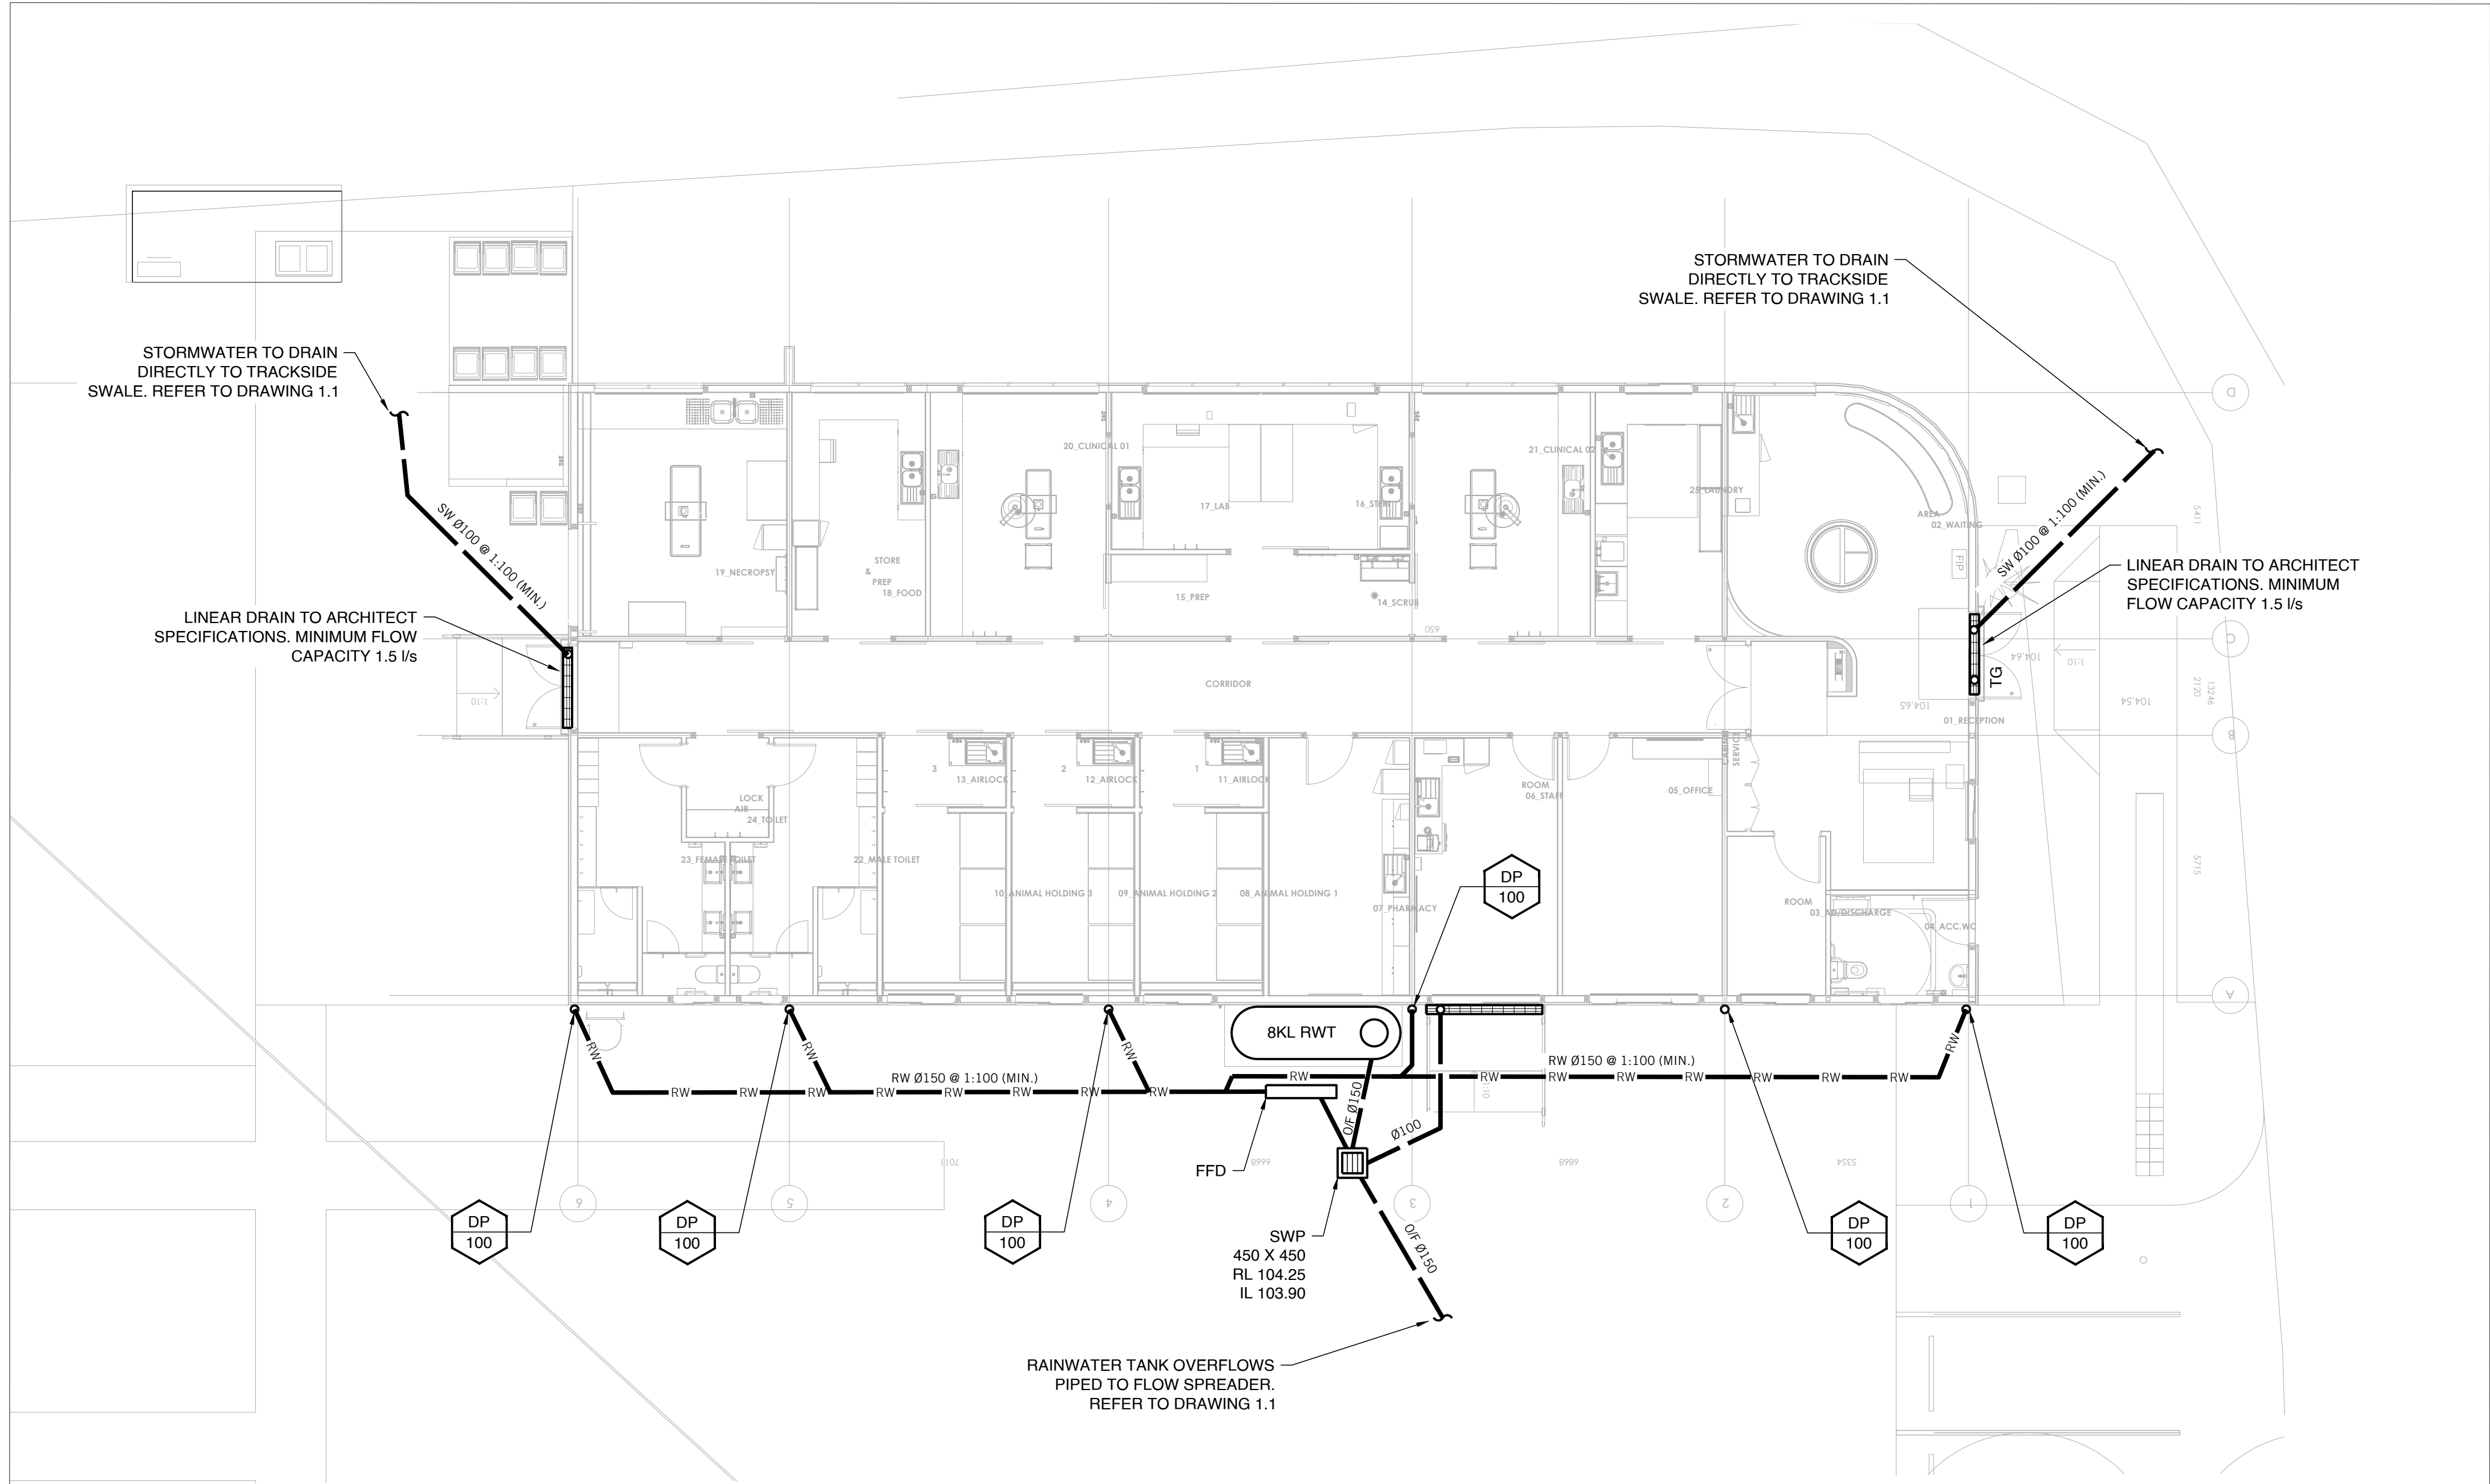


BUILDING LAYOUT

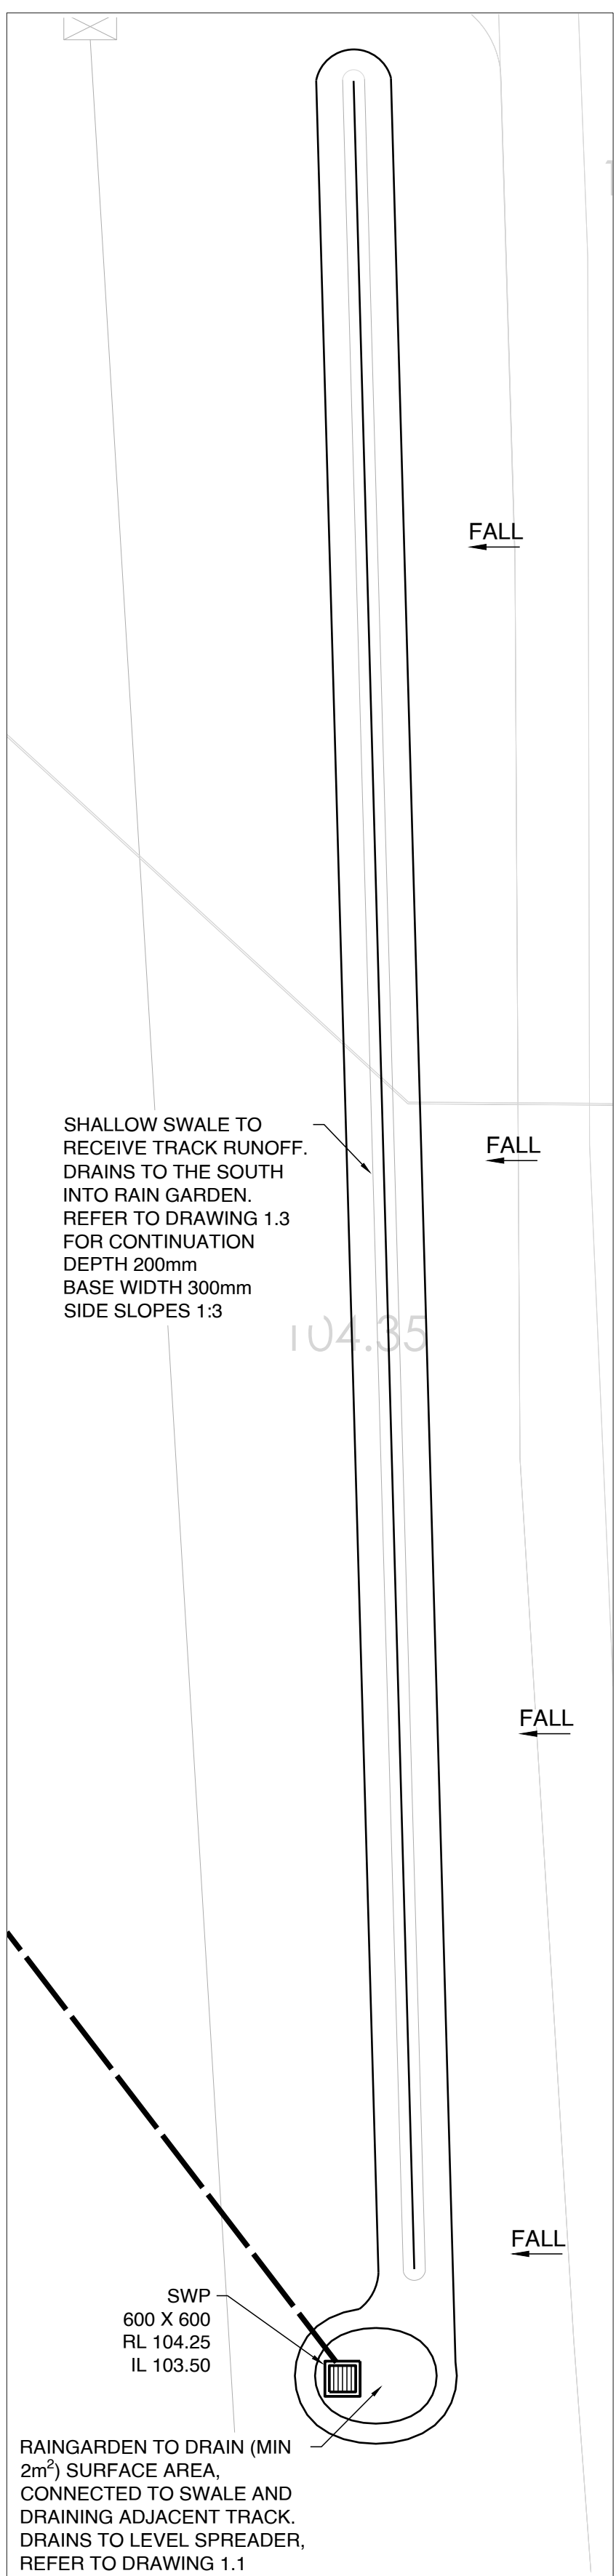


SOUTHERN RAIN GARDEN

TENDER ISSUE		F.S.	A.H.	14.08.26
Rev.	Issue / Amendment	By	App.	Date
PARTRIDGE				
partridge.com.au partridge@partridge.com.au Partridge Hydraulic Pty Ltd ABN 71 124 297 883		Copyright: The design and details shown on this drawing are specific to this project only and may not be reproduced in whole or in part or be used for any other project or purpose without the written consent of Partridge Structural Pty Ltd.		
Client ZOOS VICTORIA				
architect INNOVA GROUP 475C SAINT KILDA STREET, VIC.3184 TEL 130030859				
Project SOUTHWEST WILDLIFE HOSPITAL 75 LAKE ROAD KYABRAM, VIC 3620				
Title GROUND FLOOR LAYOUT				
DO NOT SCALE: USE FIGURED DIMENSIONS				
The presence of this signature signifies that this is the certified drawing issued for construction.		Designed A.H.	Drawn F.S.	
		Job No. 2024S0498	Scale at A1 1:100	
Date AUG 2026	Drawing No SW1.2	Revision A		
FOR TENDER - NOT FOR CONSTRUCTION				

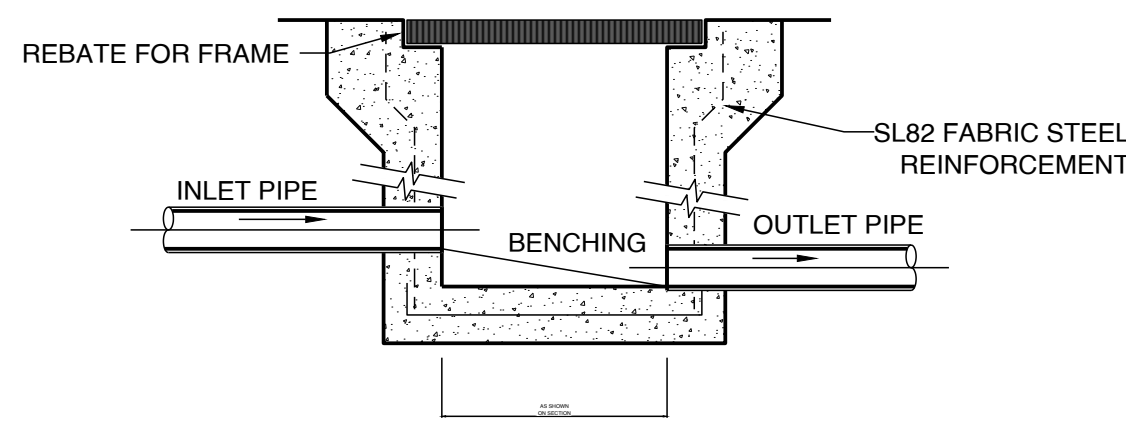


SECTION

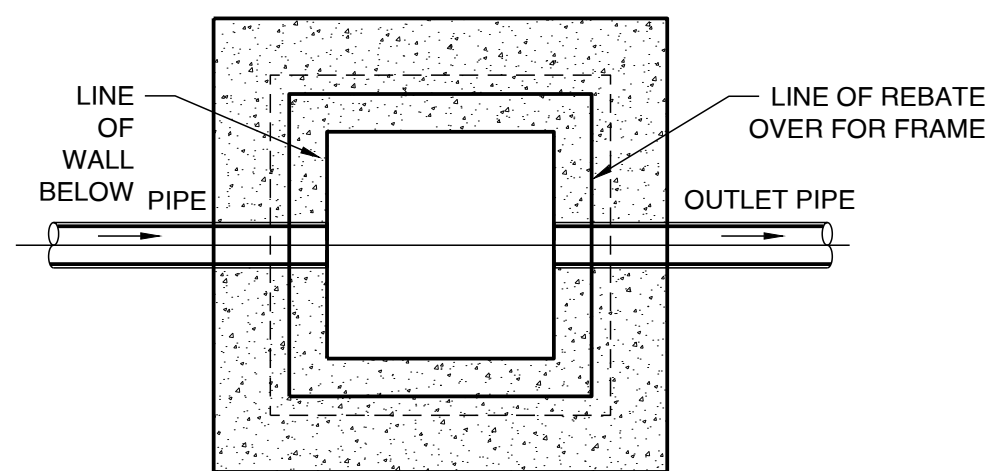


PLAN WITHOUT GRATE

TYPICAL GRATED INLET PIT
N.T.S

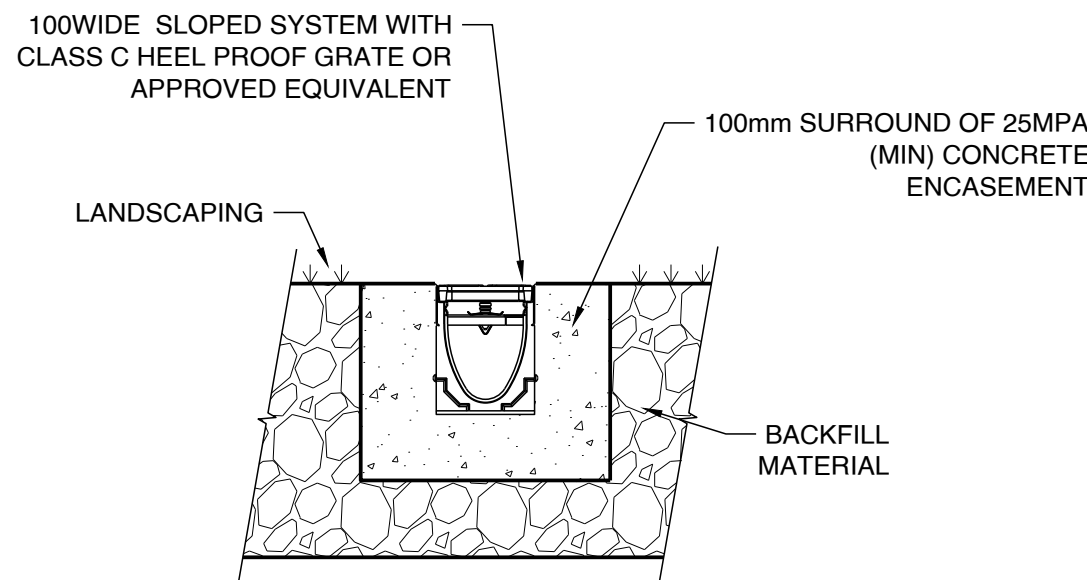


SECTION
VIEW

TYPICAL TRENCH GRATE (100mm WIDE) CLASS C
N.T.S

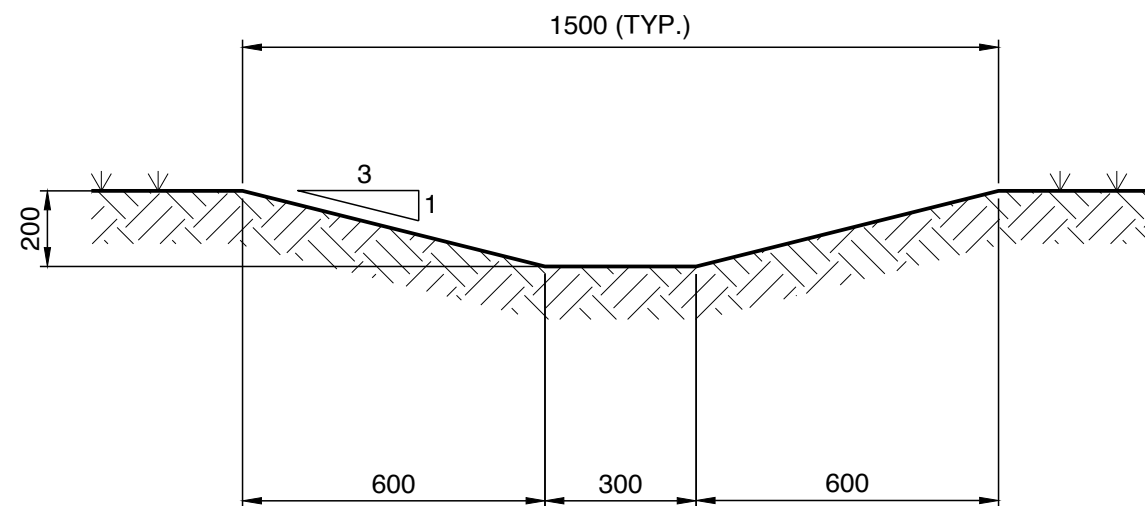


SECTION VIEW


TYPICAL GRASSED SWALE
N.T.S

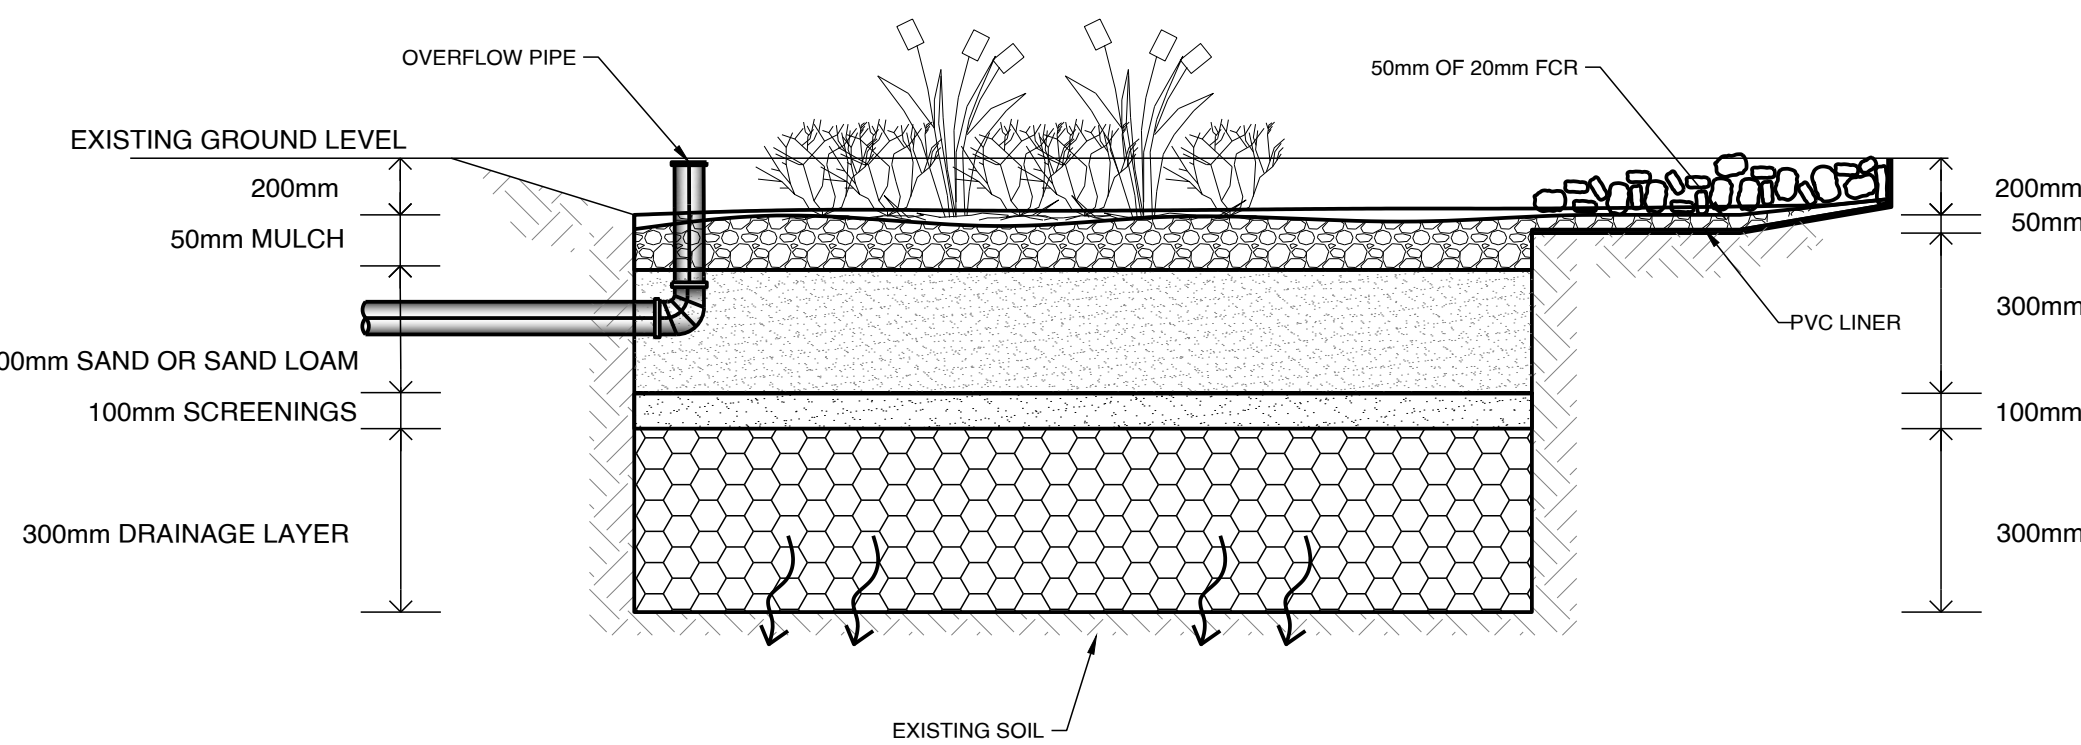

TYPICAL RAINGARDEN
N.T.S

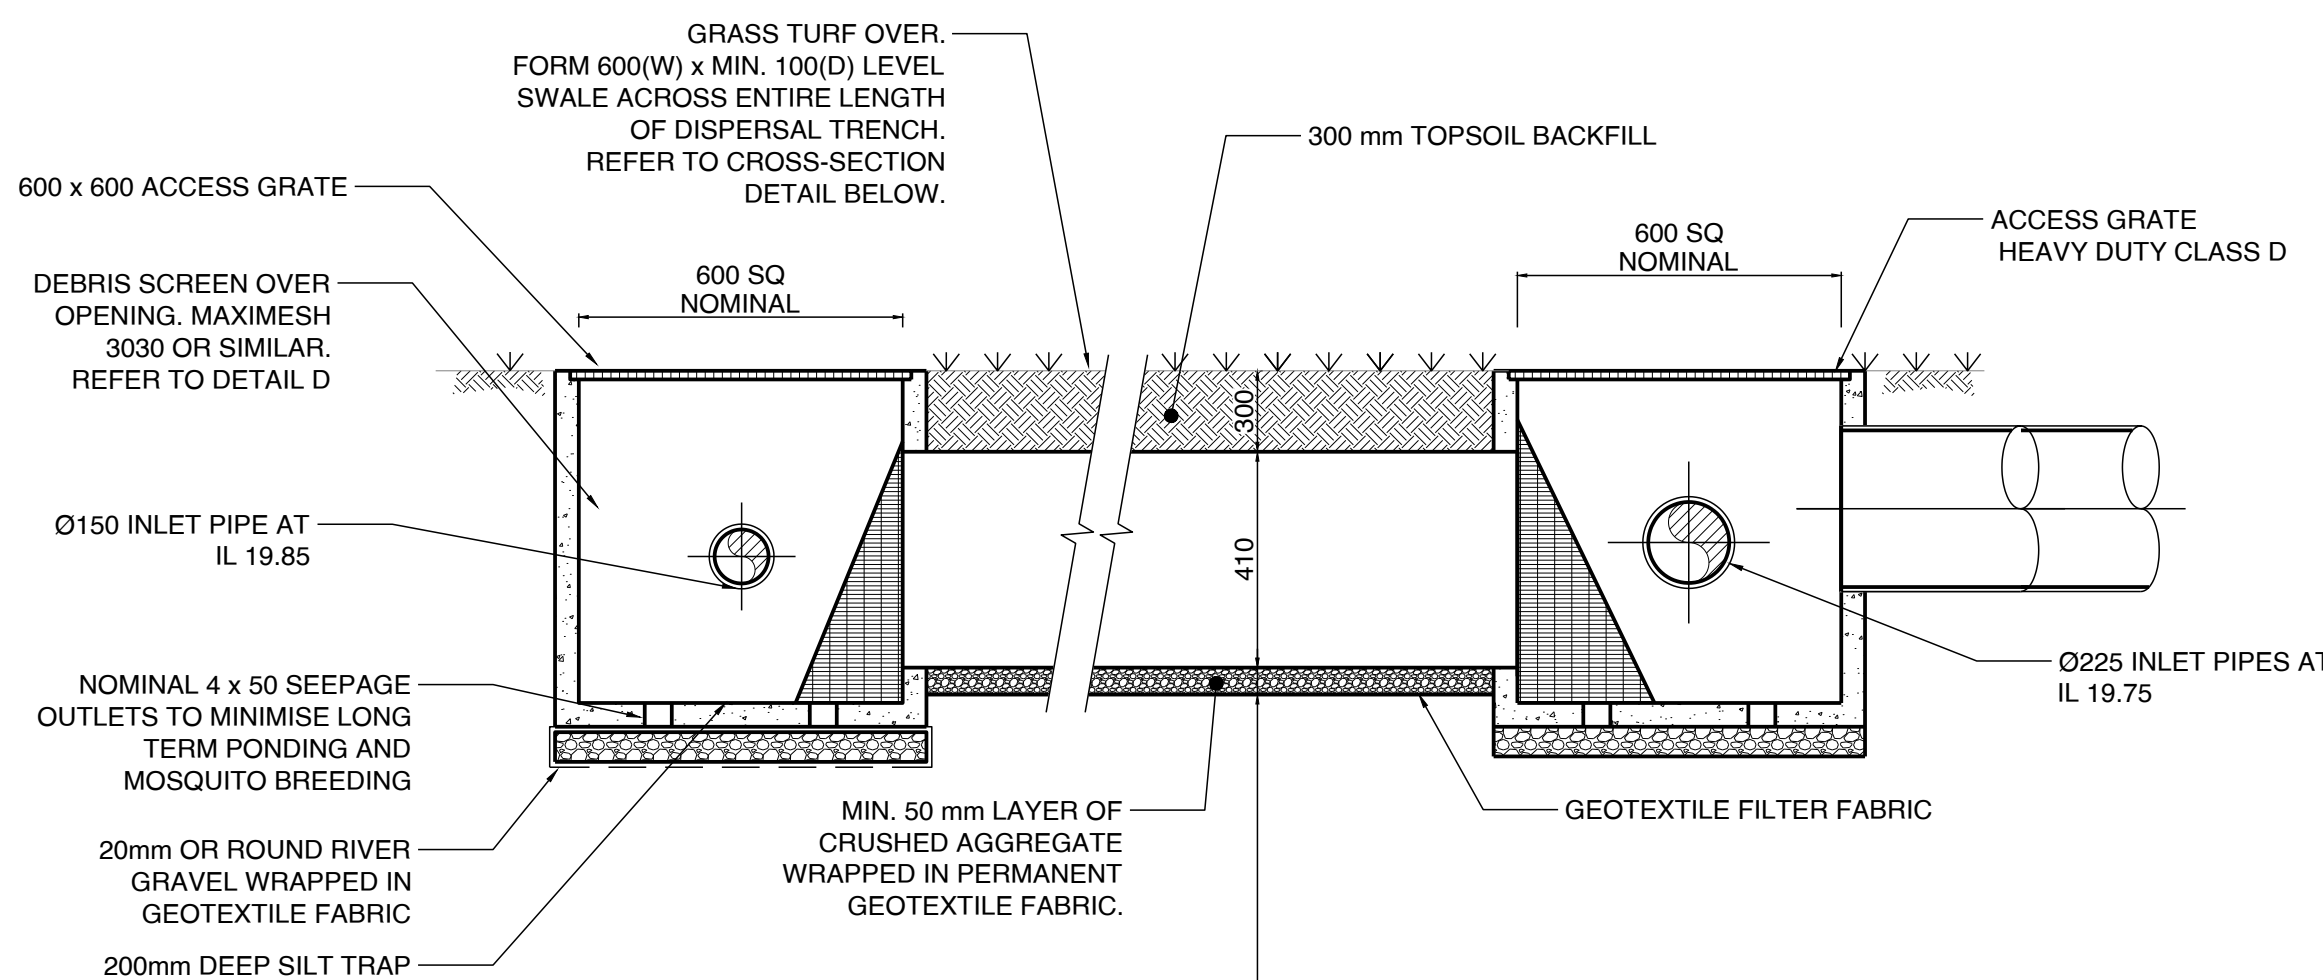


**TYPICAL LEVEL SPREADER DISPERSAL TRENCH LONGITUDINAL
SECTION**
N.T.S

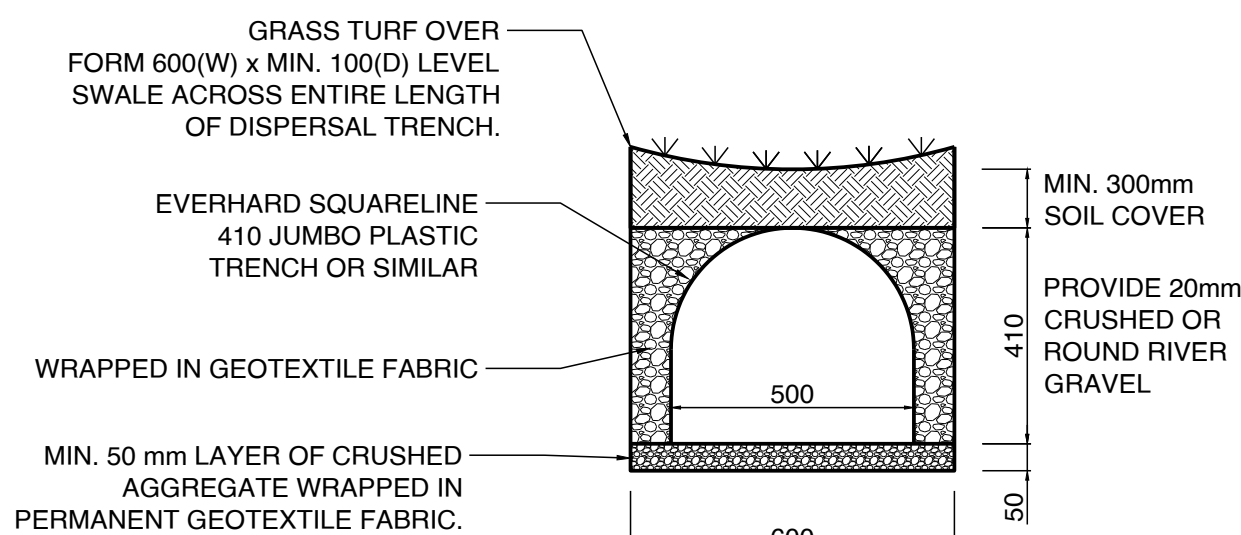

**TYPICAL LEVEL SPREADER DISPERSAL TRENCH
CROSS-SECTION**
N.T.S

NOTE

ALL TRENCHES MUST BE A MINIMUM OF 5 METERS AND PREFERABLY 8 METERS FROM THE DOWN SLOPE BOUNDARY. 3 METERS FROM FOOTINGS OF ANY STRUCTURE AND MUST RUN ALONG THE CONTOUR LINE.

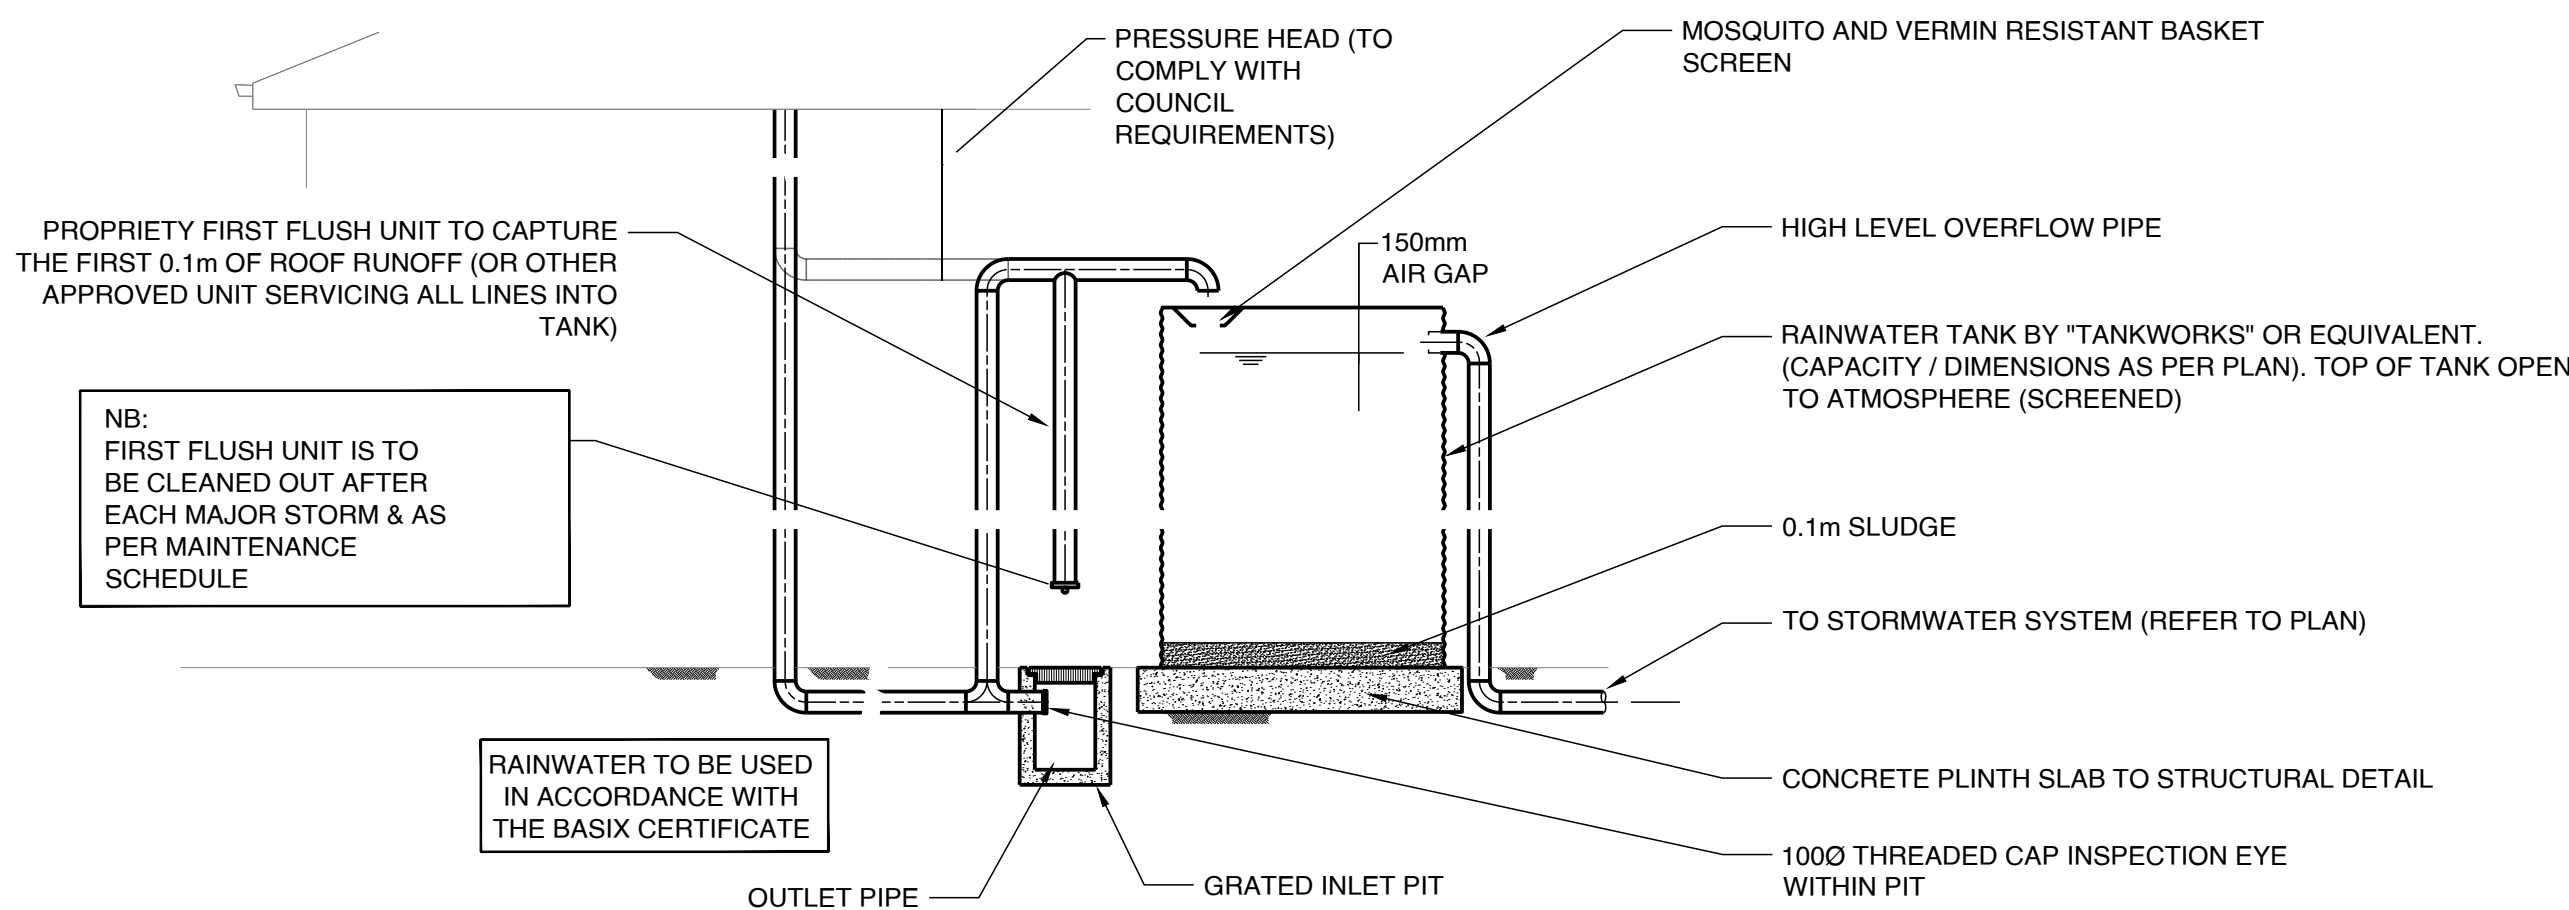

TYPICAL ABOVE GROUND RAINWATER STORAGE TANK

N.T.S

TENDER ISSUE		F.S.	A.H.	14.08.26
Rev.	Issue / Amendment	By	App.	Date
PARTRIDGE				
partridge.com.au partridge@partridge.com.au Partridge Hydraulic Pty Ltd ABN 71 124 297 883		Copyright: The design and details shown on this drawing are specific to this project only and may not be reproduced in whole or in part or be used for any other project or purpose without the written consent of Partridge Structural Pty Ltd.		
Client ZOOS VICTORIA				
architect INNOVA GROUP 475C SAINT KILDA STREET, VIC.3184 TEL 130030859				
Project SOUTHWEST WILDLIFE HOSPITAL 75 LAKE ROAD KYABRAM, VIC 3620				
Title DETAILS SHEET				
DO NOT SCALE: USE FIGURED DIMENSIONS				
The presence of this signature signifies that this is the certified drawing issued for construction.		Designed A.H.	Drawn F.S.	
		Job No. 2024S0498	Scale at A1 N/A	
Date AUG 2026		Drawing No SW1.3	Revision A	
FOR TENDER - NOT FOR CONSTRUCTION				