



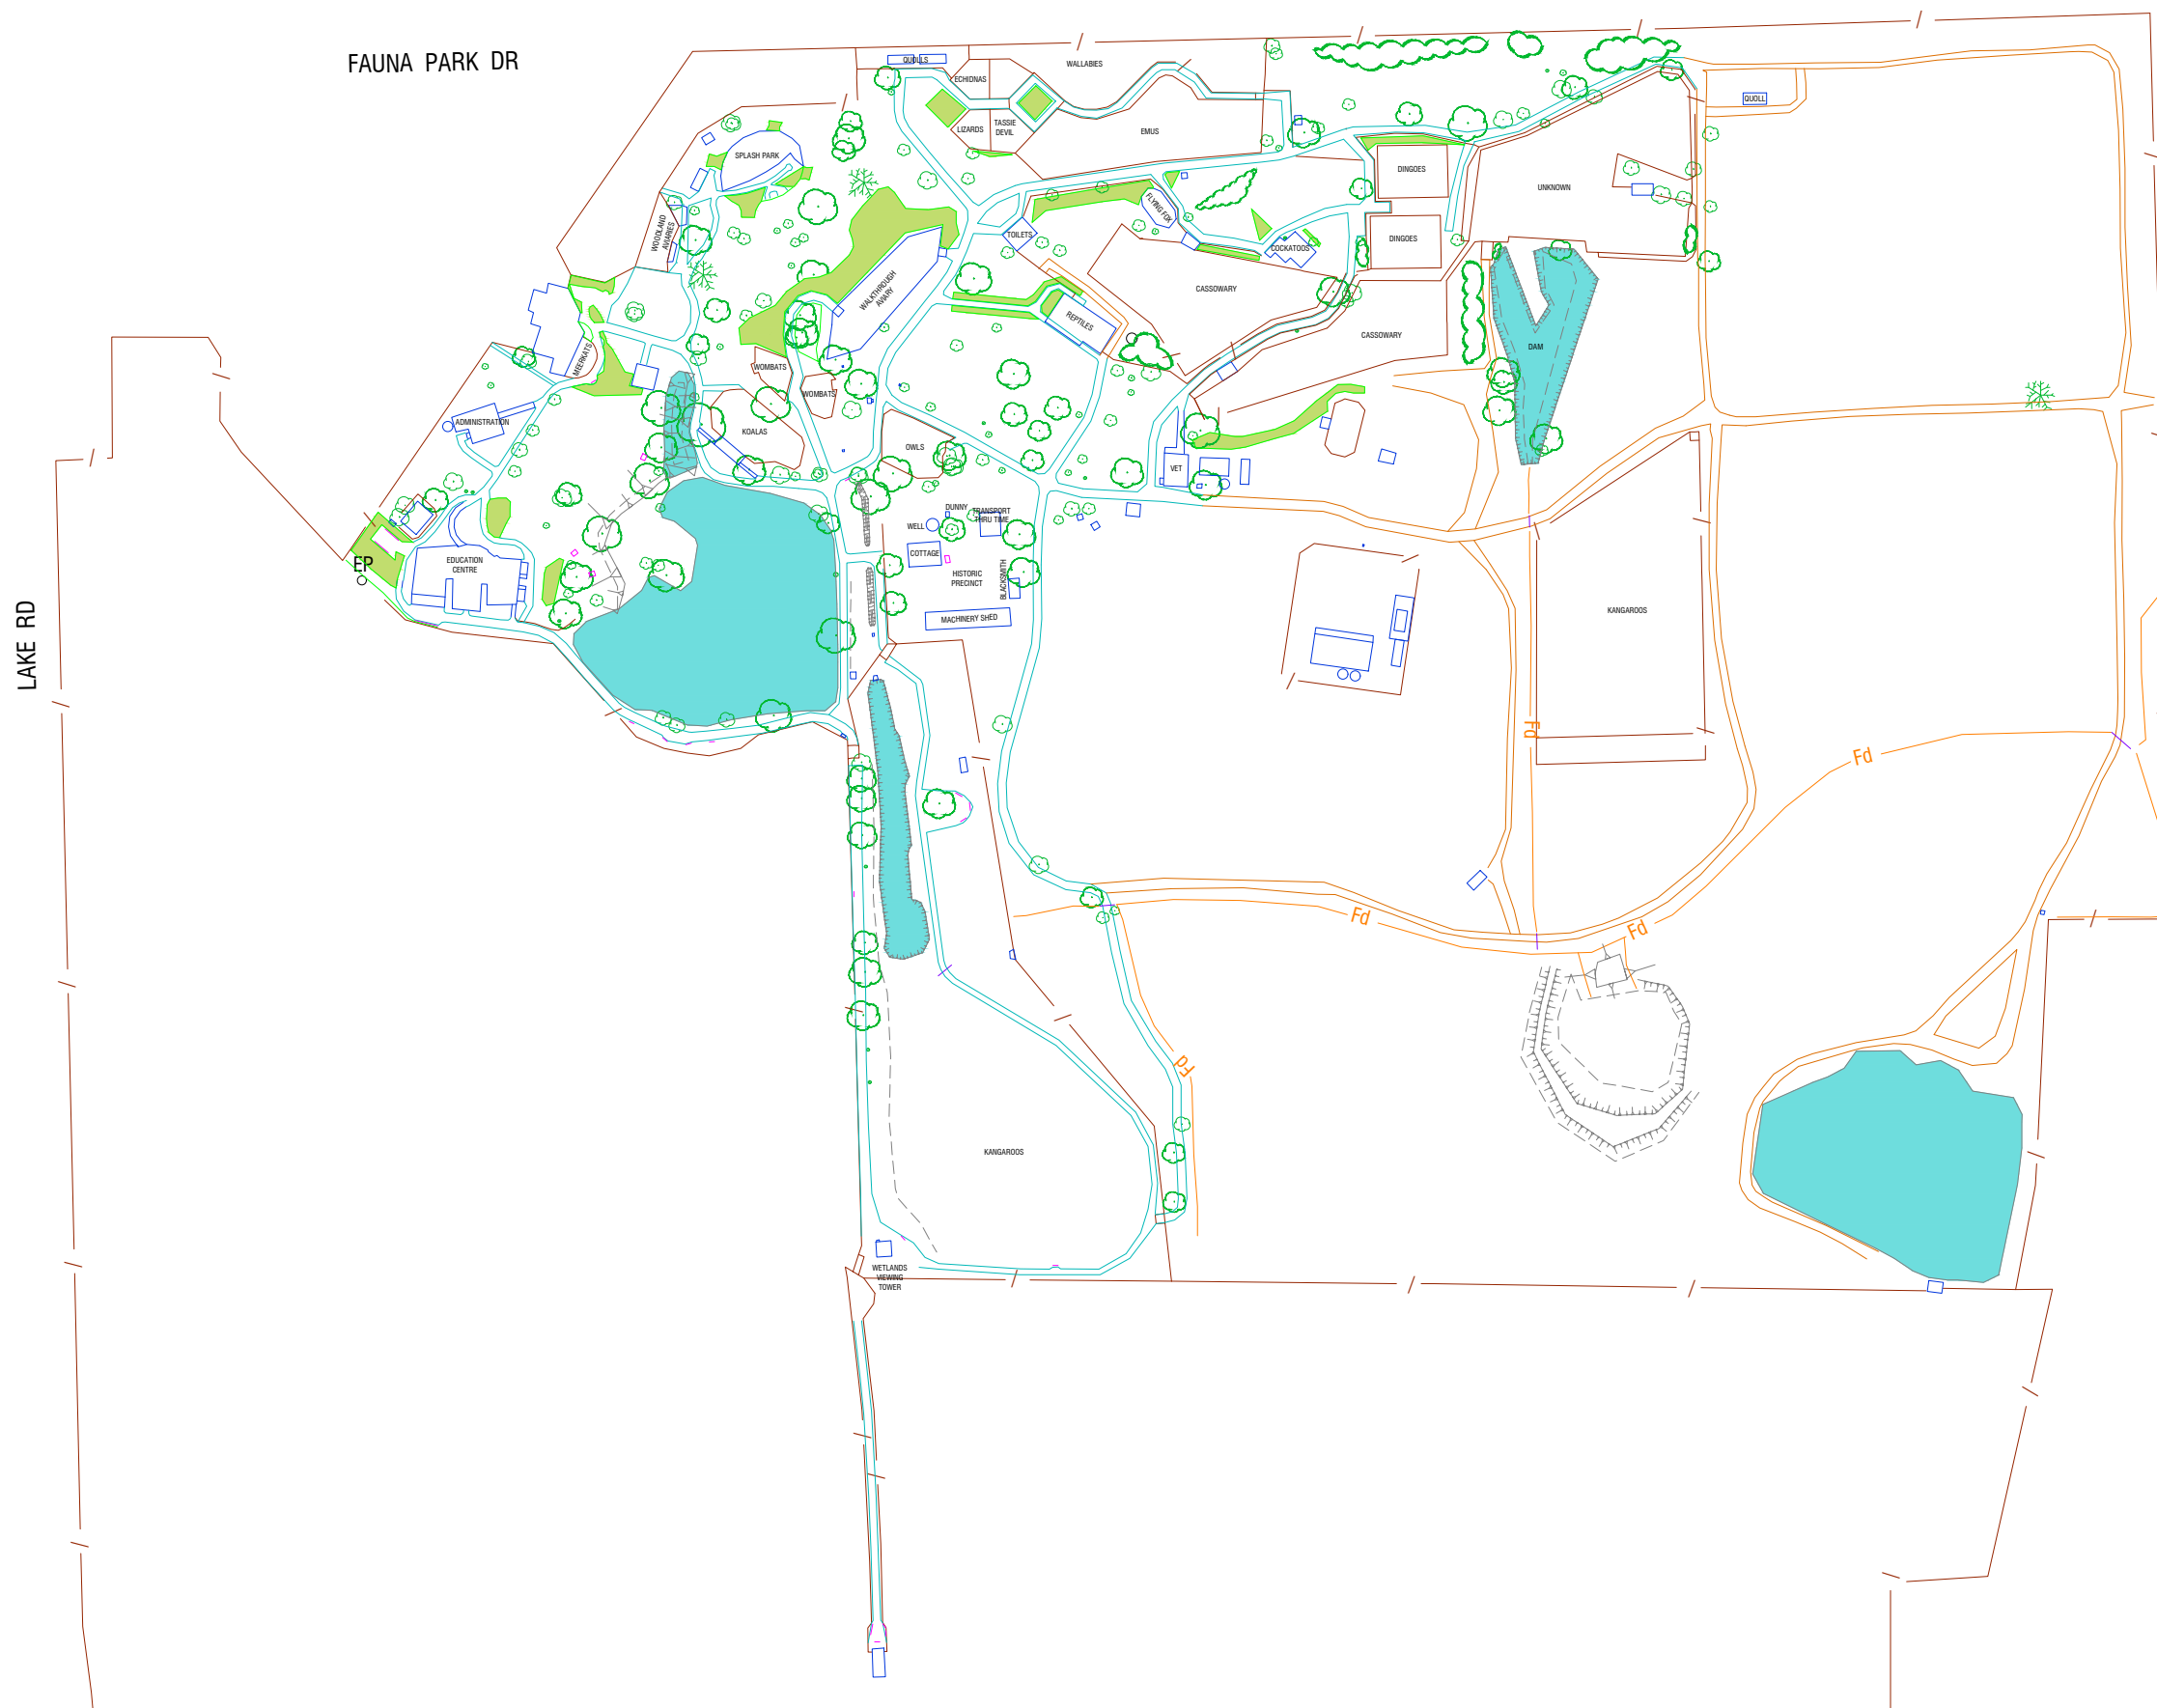

0m 20 40 60 80 100
SCALE: 1:2500

ISSUED FOR REVIEW			WARNING BEWARE OF UNDERGROUND SERVICES THE LOCATION OF UNDERGROUND SERVICES WHERE SHOWN ARE APPROXIMATE ONLY.		 advance SURVEY DESIGN 157 FENAUGHTY STREET, KYABRAM, VIC, 3620 PH. (03) 58523923		 DIAL BEFORE YOU DIG www.1100.com.au PARISH OF KYABRAM EAST CA: 2\LP70737 2\LP70738 PRINT DATE: 8/04/2026		DRAWING NAME: 5683 KY FAUNA PARK INITIAL W-DAY3.dwg DATUM: KY EAST 32 EL.: 108.178 M.G.A. ZONE 55 FOR A.H.D. ADD - m TO ALL VALUES. SURVEYED: BM, GM, GE MARCH 26 DESIGNED: - - DRAWN: GM, GE MARCH 26 CHECKED: - -			KYABRAM FAUNA PARK ZOOS VICTORIA LAYOUT AND TOPOGRAPHICAL PLAN EXISTING FEATURE PLAN				JOB NUMBER 5683 SHEET No. 2		REVISION No. A SHEET SIZE A3	
-	-	-	ALL AUTHORITIES MUST BE CONTACTED PRIOR TO CONSTRUCTION TO DETERMINE THE EXACT LOCATION OF ALL UNDERGROUND SERVICES.		CONFIRM T.B.M. FROM BENCHMARK PRIOR TO COMMENCEMENT OF WORKS.														
-	-	-																	
-	-	-																	
A	19/3/26	ISSUE FOR REVIEW																	
REV	DATE	REVISIONS																	

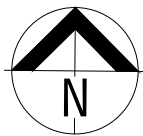

EXISTING FEATURE PLAN

ISSUED FOR REVIEW		
-	-	-
-	-	-
-	-	-
A	19/3/26	ISSUE FOR REVIEW
REV	DATE	REVISIONS

WARNING
BEWARE OF UNDERGROUND SERVICES
THE LOCATION OF UNDERGROUND SERVICES
WHERE SHOWN ARE APPROXIMATE ONLY.

ALL AUTHORITIES MUST BE CONTACTED PRIOR TO
CONSTRUCTION TO DETERMINE THE EXACT
LOCATION OF ALL UNDERGROUND SERVICES.

CONFIRM T.B.M. FROM BENCHMARK PRIOR TO
COMMENCEMENT OF WORKS.



advance
SURVEY DESIGN

157 FENAUGHTY STREET,
KYABRAM, VIC. 3620
PH. (03) 58523923





**DIAL BEFORE
YOU DIG**
www.1100.com.au

PARISH OF KYABRAM EAST
CA: 2\LP70737
2\LP70738
PRINT DATE: 8/04/2026

DRAWING NAME: 5683 KY FAUNA PARK INITIAL W-DAY3.dwg		
DATUM: KY EAST 32	EL.: 108.178	M.G.A. ZONE 55
FOR A.H.D. ADD - m TO ALL VALUES.		
SURVEYED: BM, GM, GE	MARCH 26	
DESIGNED: -	-	
DRAWN: GM, GE	MARCH 26	
CHECKED: -	-	

KYABRAM FAUNA PARK
ZOOS VICTORIA
LAYOUT AND TOPOGRAPHICAL PLAN
EXISTING FEATURE PLAN



JOB NUMBER	REVISION No.
5683	A
SHEET No.	SHEET SIZE
3	A3

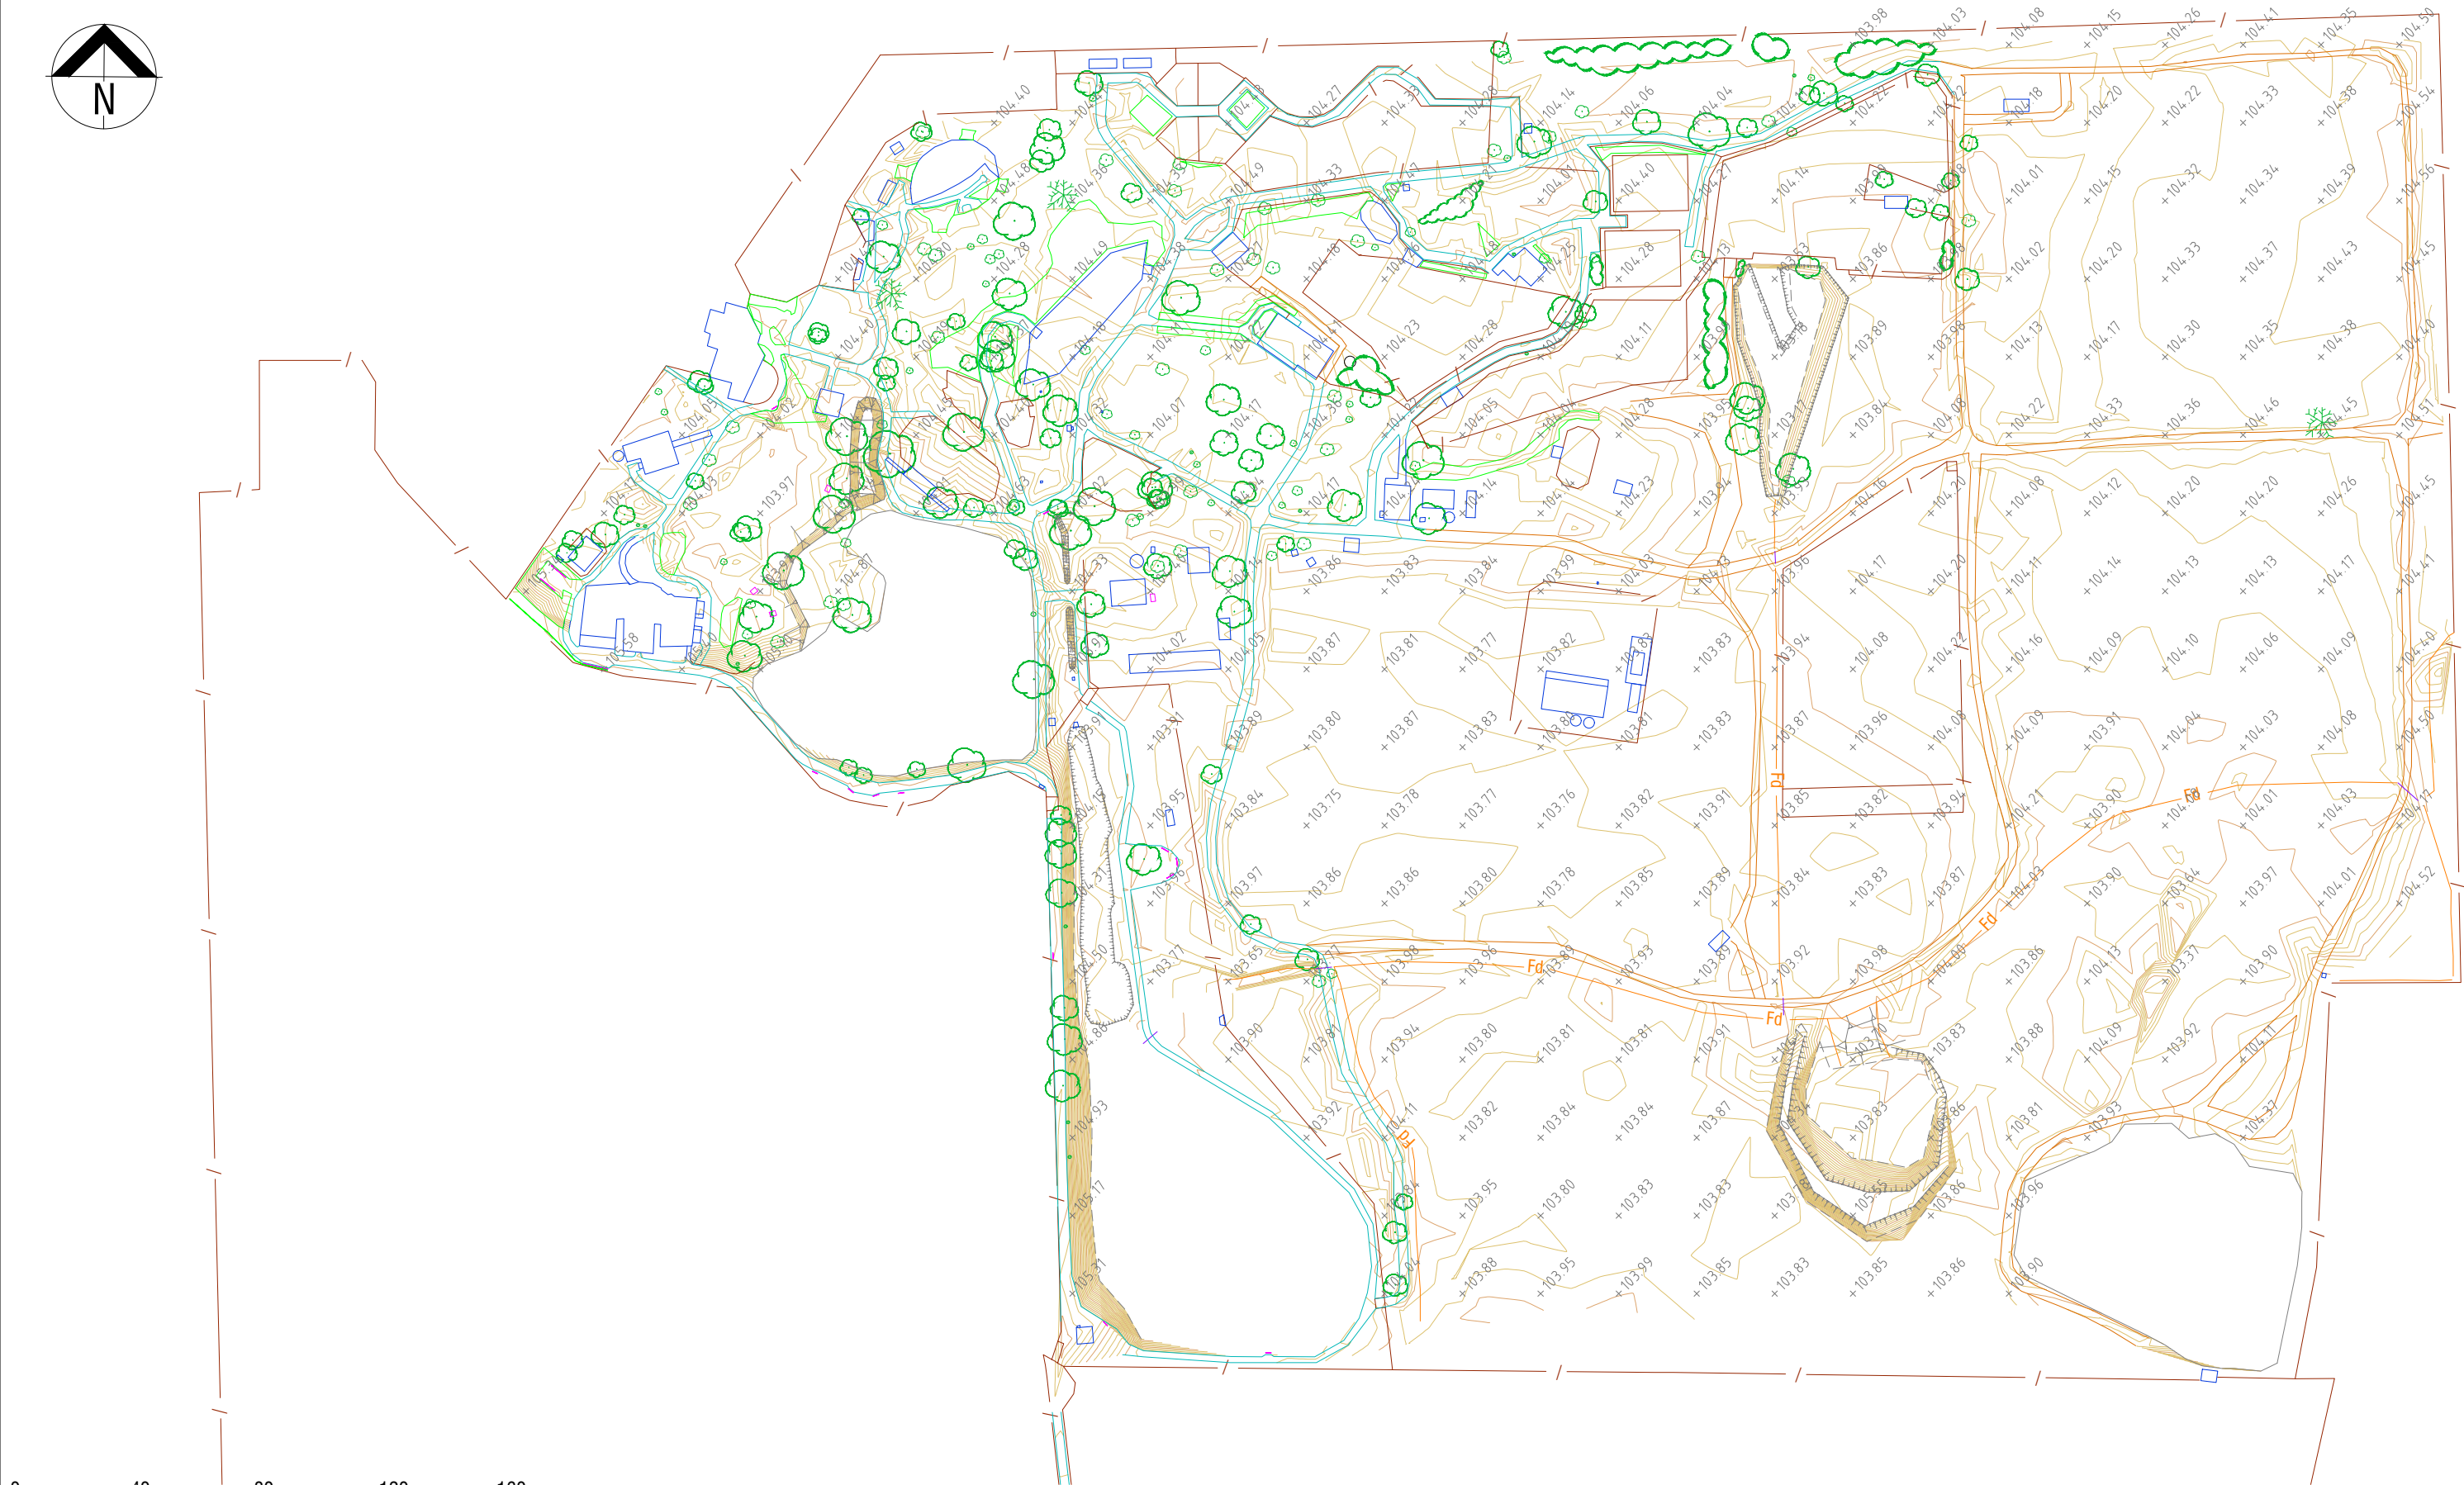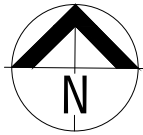

0m 40 80 120 160
HOR: 1:2,000

EXISTING LEVEL PLAN

ISSUED FOR REVIEW			WARNING BEWARE OF UNDERGROUND SERVICES THE LOCATION OF UNDERGROUND SERVICES WHERE SHOWN ARE APPROXIMATE ONLY.			 157 FENAUGHTY STREET, KYABRAM, VIC, 3620 PH. (03) 58523923			 PARISH OF KYABRAM EAST CA: 2\LP70737 2\LP70738 PRINT DATE: 8/04/2026			DRAWING NAME: 5683 KY FAUNA PARK INITIAL W-DAY3.dwg DATUM: KY EAST 32 EL.: 108.178 M.G.A. ZONE 55 FOR A.H.D. ADD - m TO ALL VALUES. SURVEYED: BM, GM, GE MARCH 26 DESIGNED: - - DRAWN: GM, GE MARCH 26 CHECKED: - -			KYABRAM FAUNA PARK ZOOS VICTORIA LAYOUT AND TOPOGRAPHICAL PLAN EXISTING LEVEL PLAN						JOB NUMBER 5683 SHEET No. 4		REVISION No. A SHEET SIZE A3	
-	-	-	ALL AUTHORITIES MUST BE CONTACTED PRIOR TO CONSTRUCTION TO DETERMINE THE EXACT LOCATION OF ALL UNDERGROUND SERVICES.			CONFIRM T.B.M. FROM BENCHMARK PRIOR TO COMMENCEMENT OF WORKS.																		
-	-	-																						
-	-	-																						
A	19/3/26	ISSUE FOR REVIEW																						
REV	DATE	REVISIONS																						

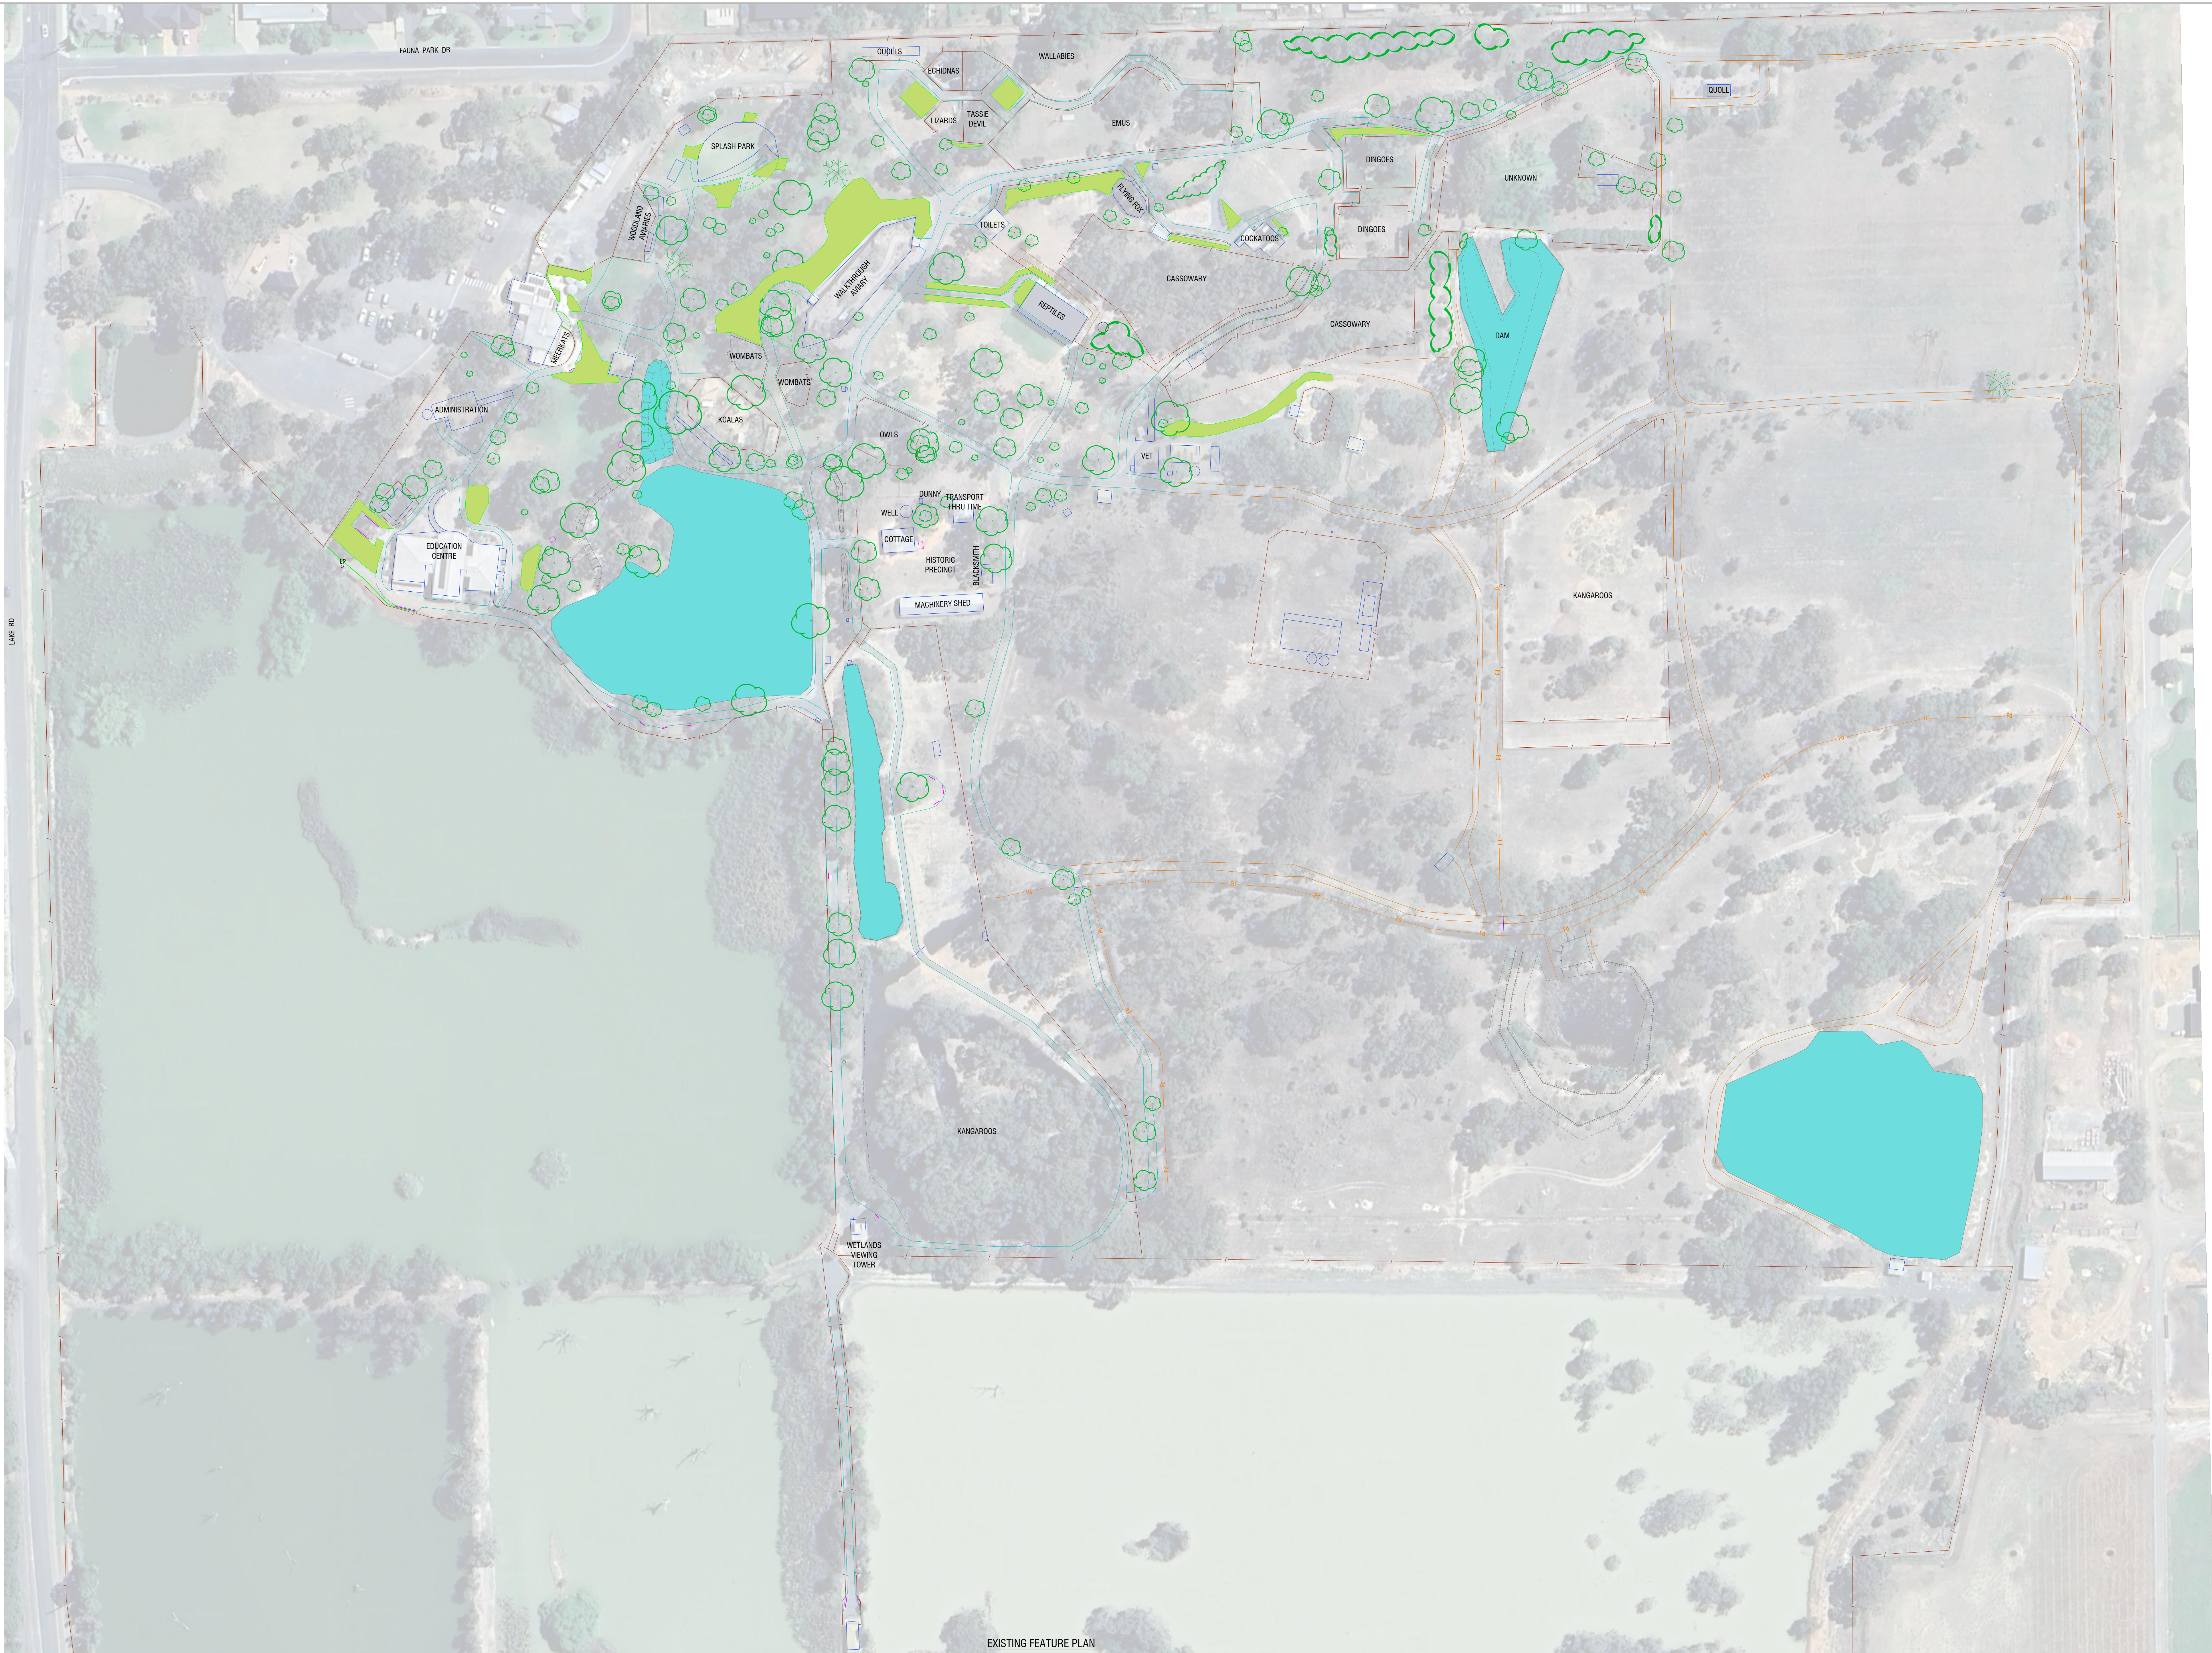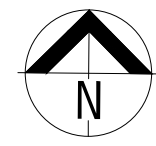


LEGEND	
GENERAL INFRASTRUCTURE	
EXISTING FENCE	
NEW FENCE	
OVERHEAD POWER LINE	
UNDERGROUND POWER LINE	
ELECTRICITY POLE	
GAS LINE	
TELEPHONE LINE	
FIBRE OPTIC	
TELEPHONE MARKER POST/POST	
EXISTING LANDWAY	
DESIGN LANDWAY	
EXISTING CHANNEL/DRAIN/CULVERT	
EXISTING SUBWAY/SEWAGE	
DUMPSY PEGS	
PERMANENT MARK	
TEMPORARY BENCH MARK	
BONE	
GATE	
WATER TROUGH	
WATER VALVE (STOP VALVE)	
TITLE	
TOE	
TOP OF BANK	
LEVEL BANK	
EXISTING TREE PLANTATION	
NON REMANENT TREE	
REMANENT TREE AREA	
REMANENT TREE	
EXISTING PIPELINE	
EXISTING RIVER	
CONTIGUOUS DISTANCE ARE 0.1m UNLESS OTHERWISE SPECIFIED	

DISCLAIMER
NOTWITHSTANDING ANY DESCRIPTION CONTAINED IN THE PLANS OR SPECIFICATION, THE CONTRACTOR SHALL BE RESPONSIBLE FOR SATISFYING THEMSELVES AS TO THE NATURE AND EXTENT OF THE SPECIFIED WORKS, AND THE PHYSICAL AND LEGAL CONDITIONS UNDER WHICH THE WORKS WILL BE CARRIED OUT, INCLUDING MEANS OF ACCESS, EXTENT OF CLEARING, NATURE OF MATERIAL TO BE EXCAVATED, TYPE AND SIZE OF MECHANICAL PLANT REQUIRED AND ANY LIKE MATTERS AFFECTING THE CONSTRUCTION OF WORKS.

-	-	-	-
-	-	-	-
-	-	-	-
-	-	-	-
-	-	-	-
A	ISSUE FOR REVIEW	25/3/26	
REF.1	REVISION	DATE	APPD.

WARNING
BEWARE OF UNDERGROUND SERVICES
THE LOCATION OF UNDERGROUND SERVICES, WHERE SHOWN, ARE APPROXIMATE ONLY.
ALL AUTHORITIES MUST BE CONTACTED PRIOR TO CONSTRUCTION TO DETERMINE THE EXACT LOCATION OF ALL UNDERGROUND SERVICES.
CONFRONT 1.8 M. RL FROM BENCHMARK PRIOR TO COMMENCEMENT OF WORKS.
TITLE BOUNDARIES ARE SHOWN AS (APPROXIMATE) LOCATION ONLY AND MUST BE RE-ESTABLISHED BY A LICENCED SURVEYOR.

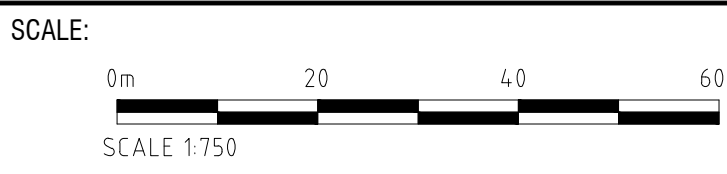

PARISH OF KYABRAM EAST
CROWN ALLOTMENT: 2/LP70737
2/LP70738

SURVEY METHOD:	G.P.S.
INTERPOLATED GRID:	30m x 30m
DATUM:	KY EAST 32
FOR A.H.D. ADD	0.00 TO ALL VALUES.
SURVEYED:	BM, GM, GE
INITIAL PLAN:	GM, GE
FINAL PLAN:	-

advance
SURVEY DESIGN
157 FENAUGHTY STREET,
KYABRAM, VIC. 3620
PH. (03) 56523923



DIAL BEFORE YOU DIG
www.1100.com.au
DESIGNED: -
CHECKED: BM

APPROVED:
AREA: -
PRINT DATE: 8/04/2026

CLIENT:
ZOO VICTORIA

KYABRAM FAUNA PARK
ZOO VICTORIA
LAYOUT PLAN
EXISTING FEATURE PLAN

ORIGINAL SHEET SIZE	A0
SCALE:	1:750
REF:	REV:
5683	A
SHEET A0-1	
5683 KY FAUNA PARK INITIAL W-DAYS	

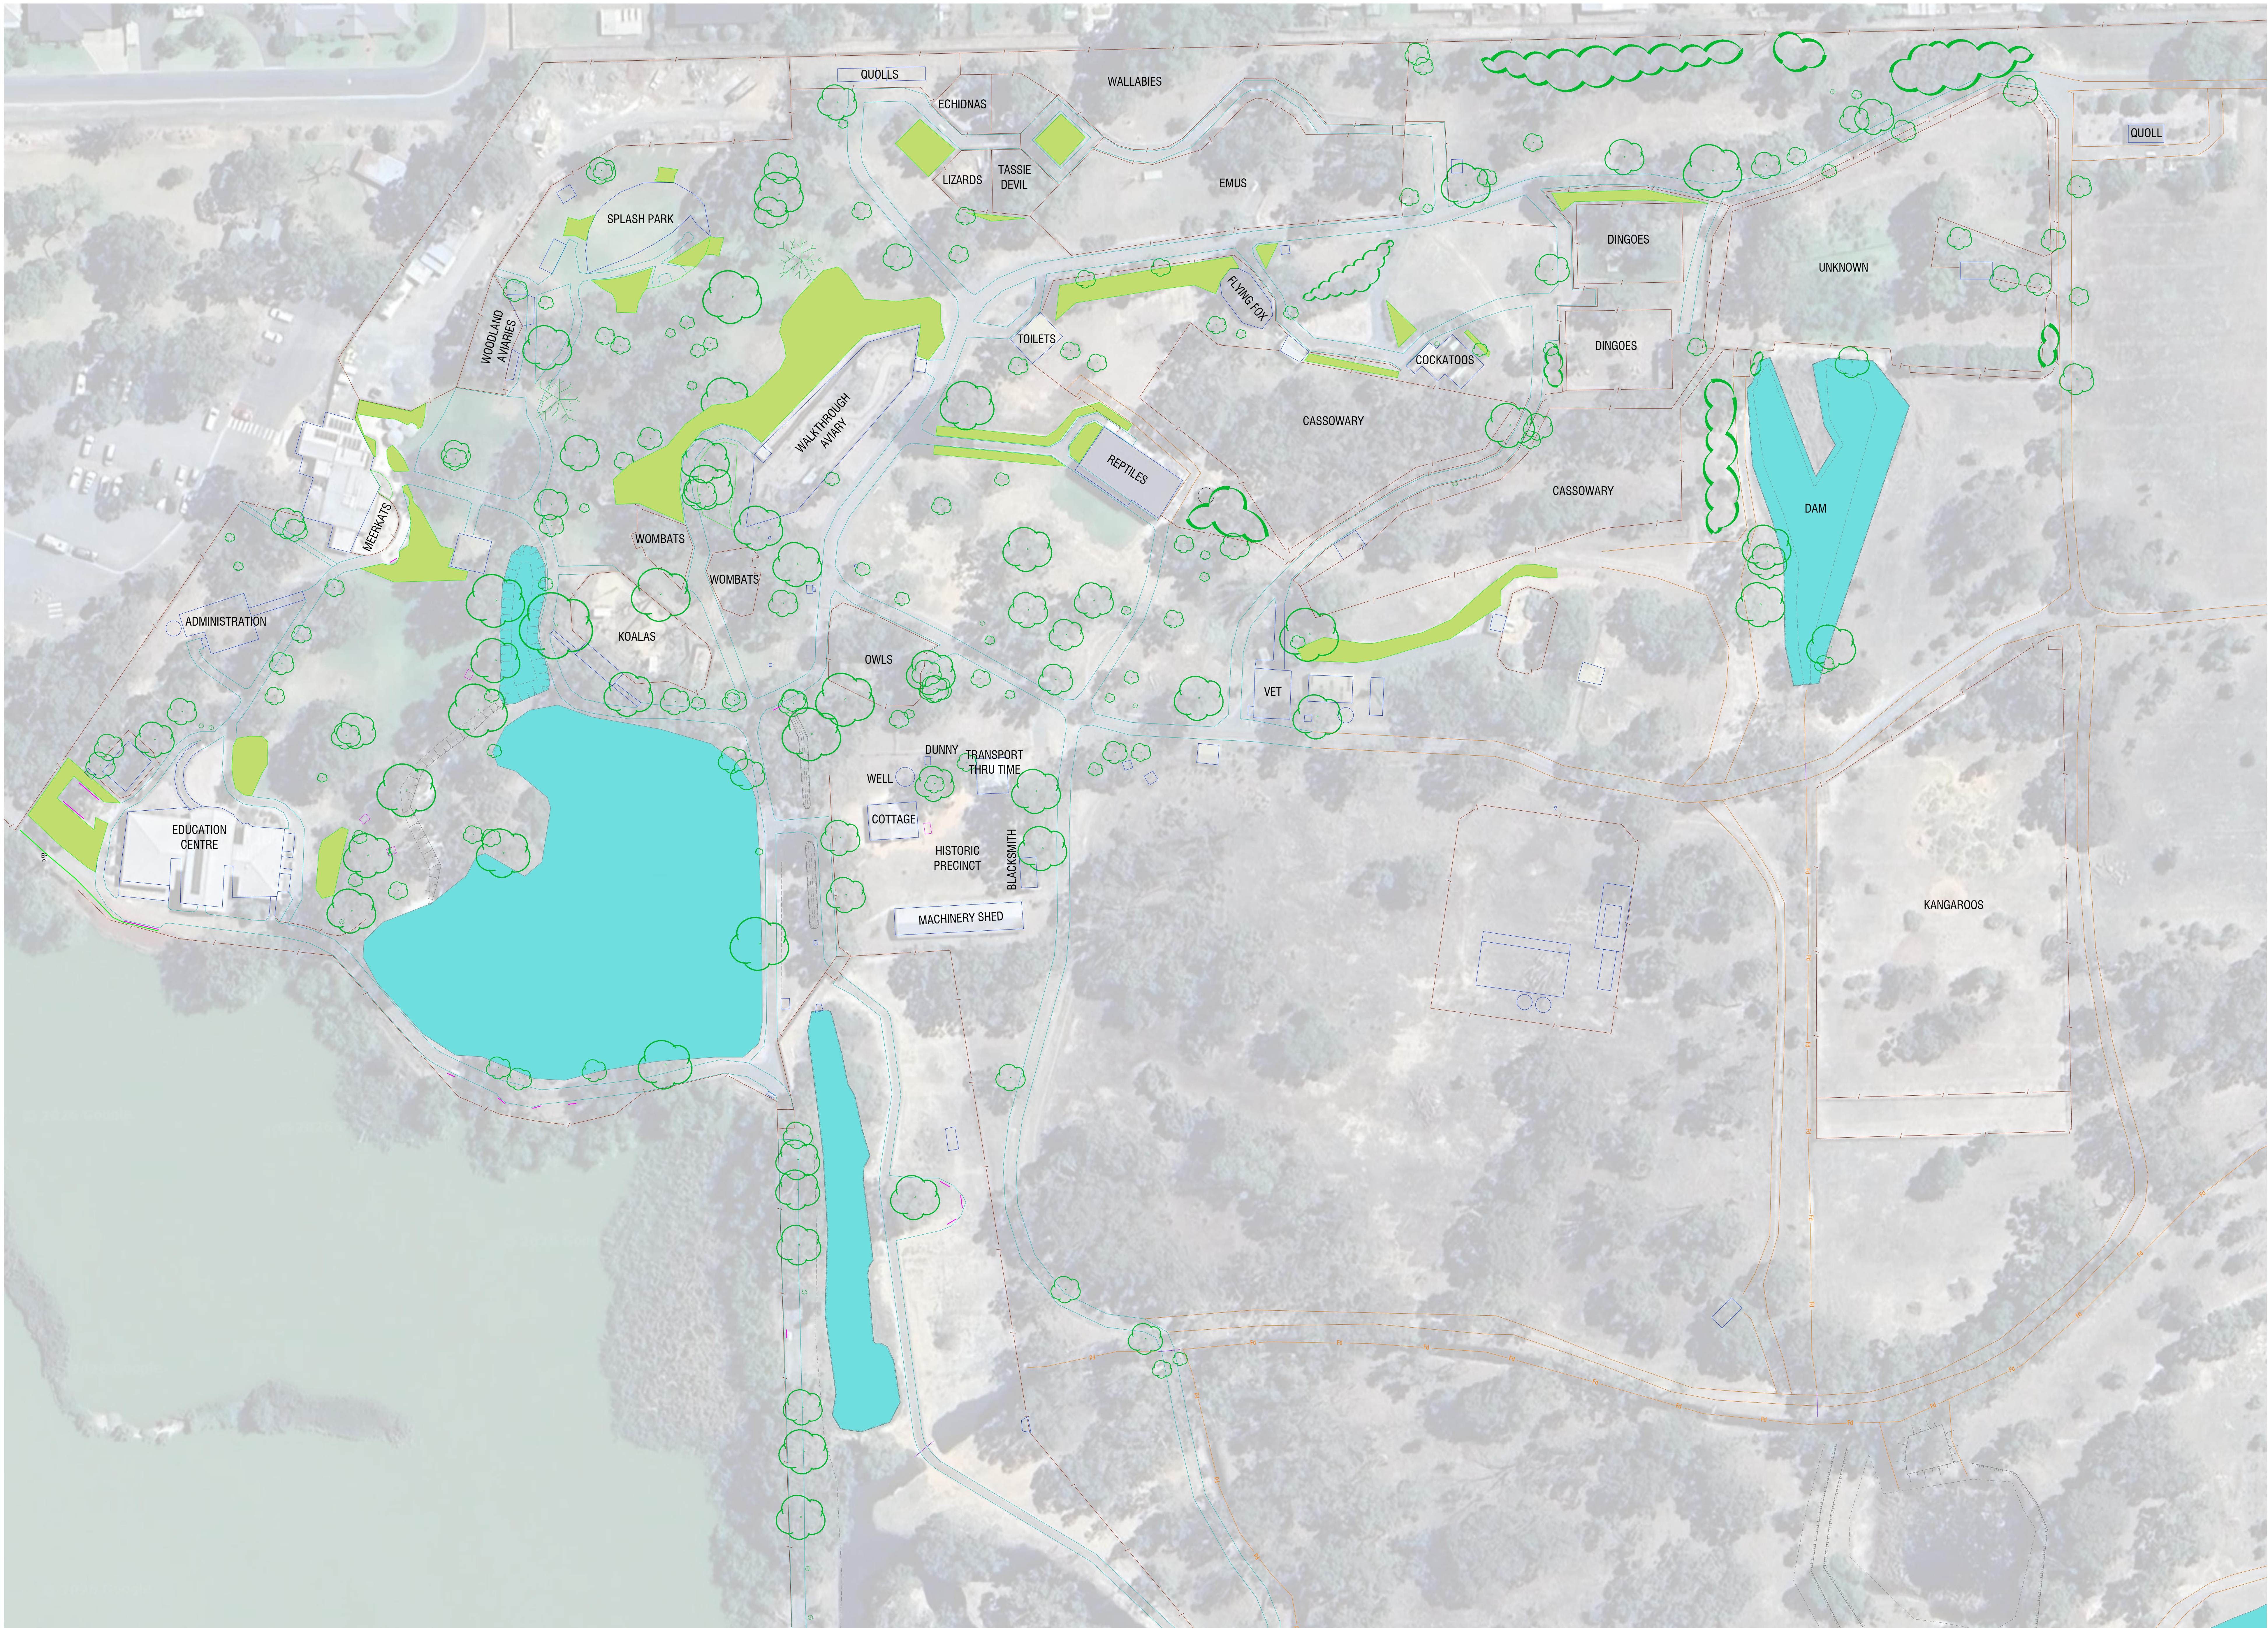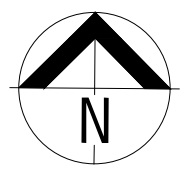

LEGEND	
GENERAL INFRASTRUCTURE	
EXISTING FENCE	
NEW FENCE	
OVERHEAD POWER LINE	
UNDERGROUND POWER LINE	
ELECTRICITY POLE	
GAS LINE	
TELEPHONE LINE	
FIBRE OPTIC	
TELEPHONE MARKER POST/POST	
EXISTING LANDWAY	
DESIGN LANDWAY	
EXISTING CHANNEL/DRAIN/CULVERT	
EXISTING SUBWAY/SPHON	
DUMPY PESS	
PERMANENT MARK	
TEMPORARY BENCH MARK	
BONE	
GATE	
WATER TROUGH	
WATER VALVE (STOP VALVE)	
TIDE	
TOP OF BANK	
LEVEE BANK	
EXISTING TREE PLANTATION	
NON MORNANT TREE	
REMANANT TREE AREA	
DEAD TREE	
EXISTING PIPELINE	
EXISTING RIVER	
CONTIGUOUS INTERVALS ARE 0.1m UNLESS OTHERWISE SPECIFIED	

EXISTING FEATURE PLAN

DISCLAIMER NOTWITHSTANDING ANY DESCRIPTION CONTAINED IN THE PLANS OR SPECIFICATION, THE CONTRACTOR SHALL BE RESPONSIBLE FOR SATISFYING THEMSELVES AS TO THE NATURE AND EXTENT OF THE SPECIFIED WORKS, AND THE PHYSICAL AND LEGAL CONDITIONS UNDER WHICH THE WORKS WILL BE CARRIED OUT, INCLUDING MEANS OF ACCESS, EXTENT OF CLEARING, NATURE OF MATERIAL TO BE EXCAVATED, TYPE AND SIZE OF MECHANICAL PLANT REQUIRED AND ANY LIKE MATTERS AFFECTING THE CONSTRUCTION OF WORKS.		WARNING BEWARE OF UNDERGROUND SERVICES THE LOCATION OF UNDERGROUND SERVICES, WHERE SHOWN, ARE APPROXIMATE ONLY. ALL AUTHORITIES MUST BE CONTACTED PRIOR TO CONSTRUCTION TO DETERMINE THE EXACT LOCATION OF ALL UNDERGROUND SERVICES. CONFIRM T.B.M. R.L. FROM BENCHMARK PRIOR TO COMMENCEMENT OF WORKS. TITLE BOUNDARIES ARE SHOWN AS (APPROXIMATE) LOCATION ONLY AND MUST BE RE-ESTABLISHED BY A LICENCED SURVEYOR.		SCALE: 0m 10 20 30 40 HOR: 1:500	SURVEY METHOD: G.P.S. INTERPOLATED GRID: 30m x 30m DATUM: KY EAST 32 EL: 108.178 M.G.A. ZONE 55 FOR A.H.D. ADD 0.00 TO ALL VALUES. SURVEYED: BM, GM, GE MARCH 26 INITIAL PLAN: GM, GE MARCH 2026 FINAL PLAN: -	 157 FENAUGHTY STREET, KYABRAM, VIC. 3620 PH. (03) 56523923	 DESIGNED: - CHECKED: BM	APPROVED: AREA: - PRINT DATE: 8/04/2026	KYABRAM FAUNA PARK ZOOS VICTORIA LAYOUT PLAN EXISTING FEATURE PLAN ZOOS VICTORIA	ORIGINAL SHEET SIZE A0 SCALE: 1:750 REF: 5683 REV: A SHEET A0-2 5683 KY FAUNA PARK INITIAL W-DAYS
REF.1	ISSUE FOR REVIEW	25/3/26		PARISH OF KYABRAM EAST CROWN ALLOTMENT: 2/LP70737 2/LP70738						
	REVISION	DATE	APPD.							