

NEW WAREHOUSE

28 PLATINUM COURT THRUGOONA NSW 2640

FIRE SERVICES

DRAWING SCHEDULE:	
NUMBER	TITLE
FC000	COVERSHEET, LEGENDS, NOTES AND DRAWING LIST
FC001	SITE SERVICES
FC100	LEVEL G FLOOR PLAN FIRE HYDRANT COVERAGE LAYOUT
FC101	LEVEL M FLOOR PLAN FIRE HYDRANT COVERAGE LAYOUT
FC200	LEVEL G FLOOR PLAN FIRE HOSE REEL COVERAGE LAYOUT
FC201	LEVEL M FLOOR PLAN FIRE HOSE REEL COVERAGE LAYOUT

PIPEWORK		SYMBOLS	
	FIRE HYDRANT		FIRE HYDRANT
	FIRE HOSE REEL		DOUBLE FIRE HYDRANT
			FIRE HOSE REEL
			STREET HYDRANT



CENTRIC
Building Services Engineers

© CENTRIC BUILDING SERVICES ENGINEERS PTY LTD
This drawing is the property of Centric Building Services PTY Limited and must not be used, reproduced or copied wholly or in part without the written permission of Centric Building Services Pty Limited. The elements shown on this drawing are prototypical design only. The contractor shall produce workshop drawings for construction purposes. The contractor shall not scale from this drawing and all measurements shall be carried out on site.

P1 30.05.2025 100% FINAL COORDINATION

FIRE SERVICES

NEW WAREHOUSE

32 PLATINUM COURT
THRUGOONA NSW 2640

Project Number:
24071

Drawing Number:
FC000

Revision:
P1



Sydney: (02) 9052 6460
Newcastle: (02) 9052 6461



Sydney Suite 1, 401 Pacific Hwy
Artarmon, NSW 2064
Newcastle Suite 4, 102 Glebe Road
The Junction, NSW 2291



info@centricengineers.com.au
www.centricengineers.com





CENTRIC
Building Services Engineers


© CENTRIC BUILDING SERVICES ENGINEERS PTY LTD
This drawing is the property of Centric Building Services PTY Limited and must not be used, reproduced or copied wholly or in part without the written permission of Centric Building Services PTY Limited. The elements shown on this drawing are prototypical design only. The contractor shall produce workshop drawings for construction purposes. The contractor shall not scale from this drawing and all measurements shall be carried out on site.

P1 30.05.2025 100% FINAL COORDINATION

**100%
ISSUE**

**FIRE
SERVICES**

Project North

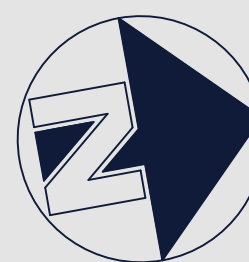

Client: VINCENT JARVIS
Architect:

Project Number: 24071
Drawing Number: FC001
Revision: P1

Drawn by: IB
Designed by: IB
Approved by: JA
Scale: 1:300 @ A1


NEW WAREHOUSE, 28 PLATINUM
COURT, THRUGOONA, NSW.2640

SITE SERVICES

Sydney: (02) 9052 6460
Newcastle: (02) 9052 6461

Sydney: Suite 1, 401 Pacific Hwy
Artarmon, NSW 2064
Newcastle: Suite 4, 102 Glebe Road
The Junction, NSW 2291

info@centricengineers.com.au
www.centricengineers.com

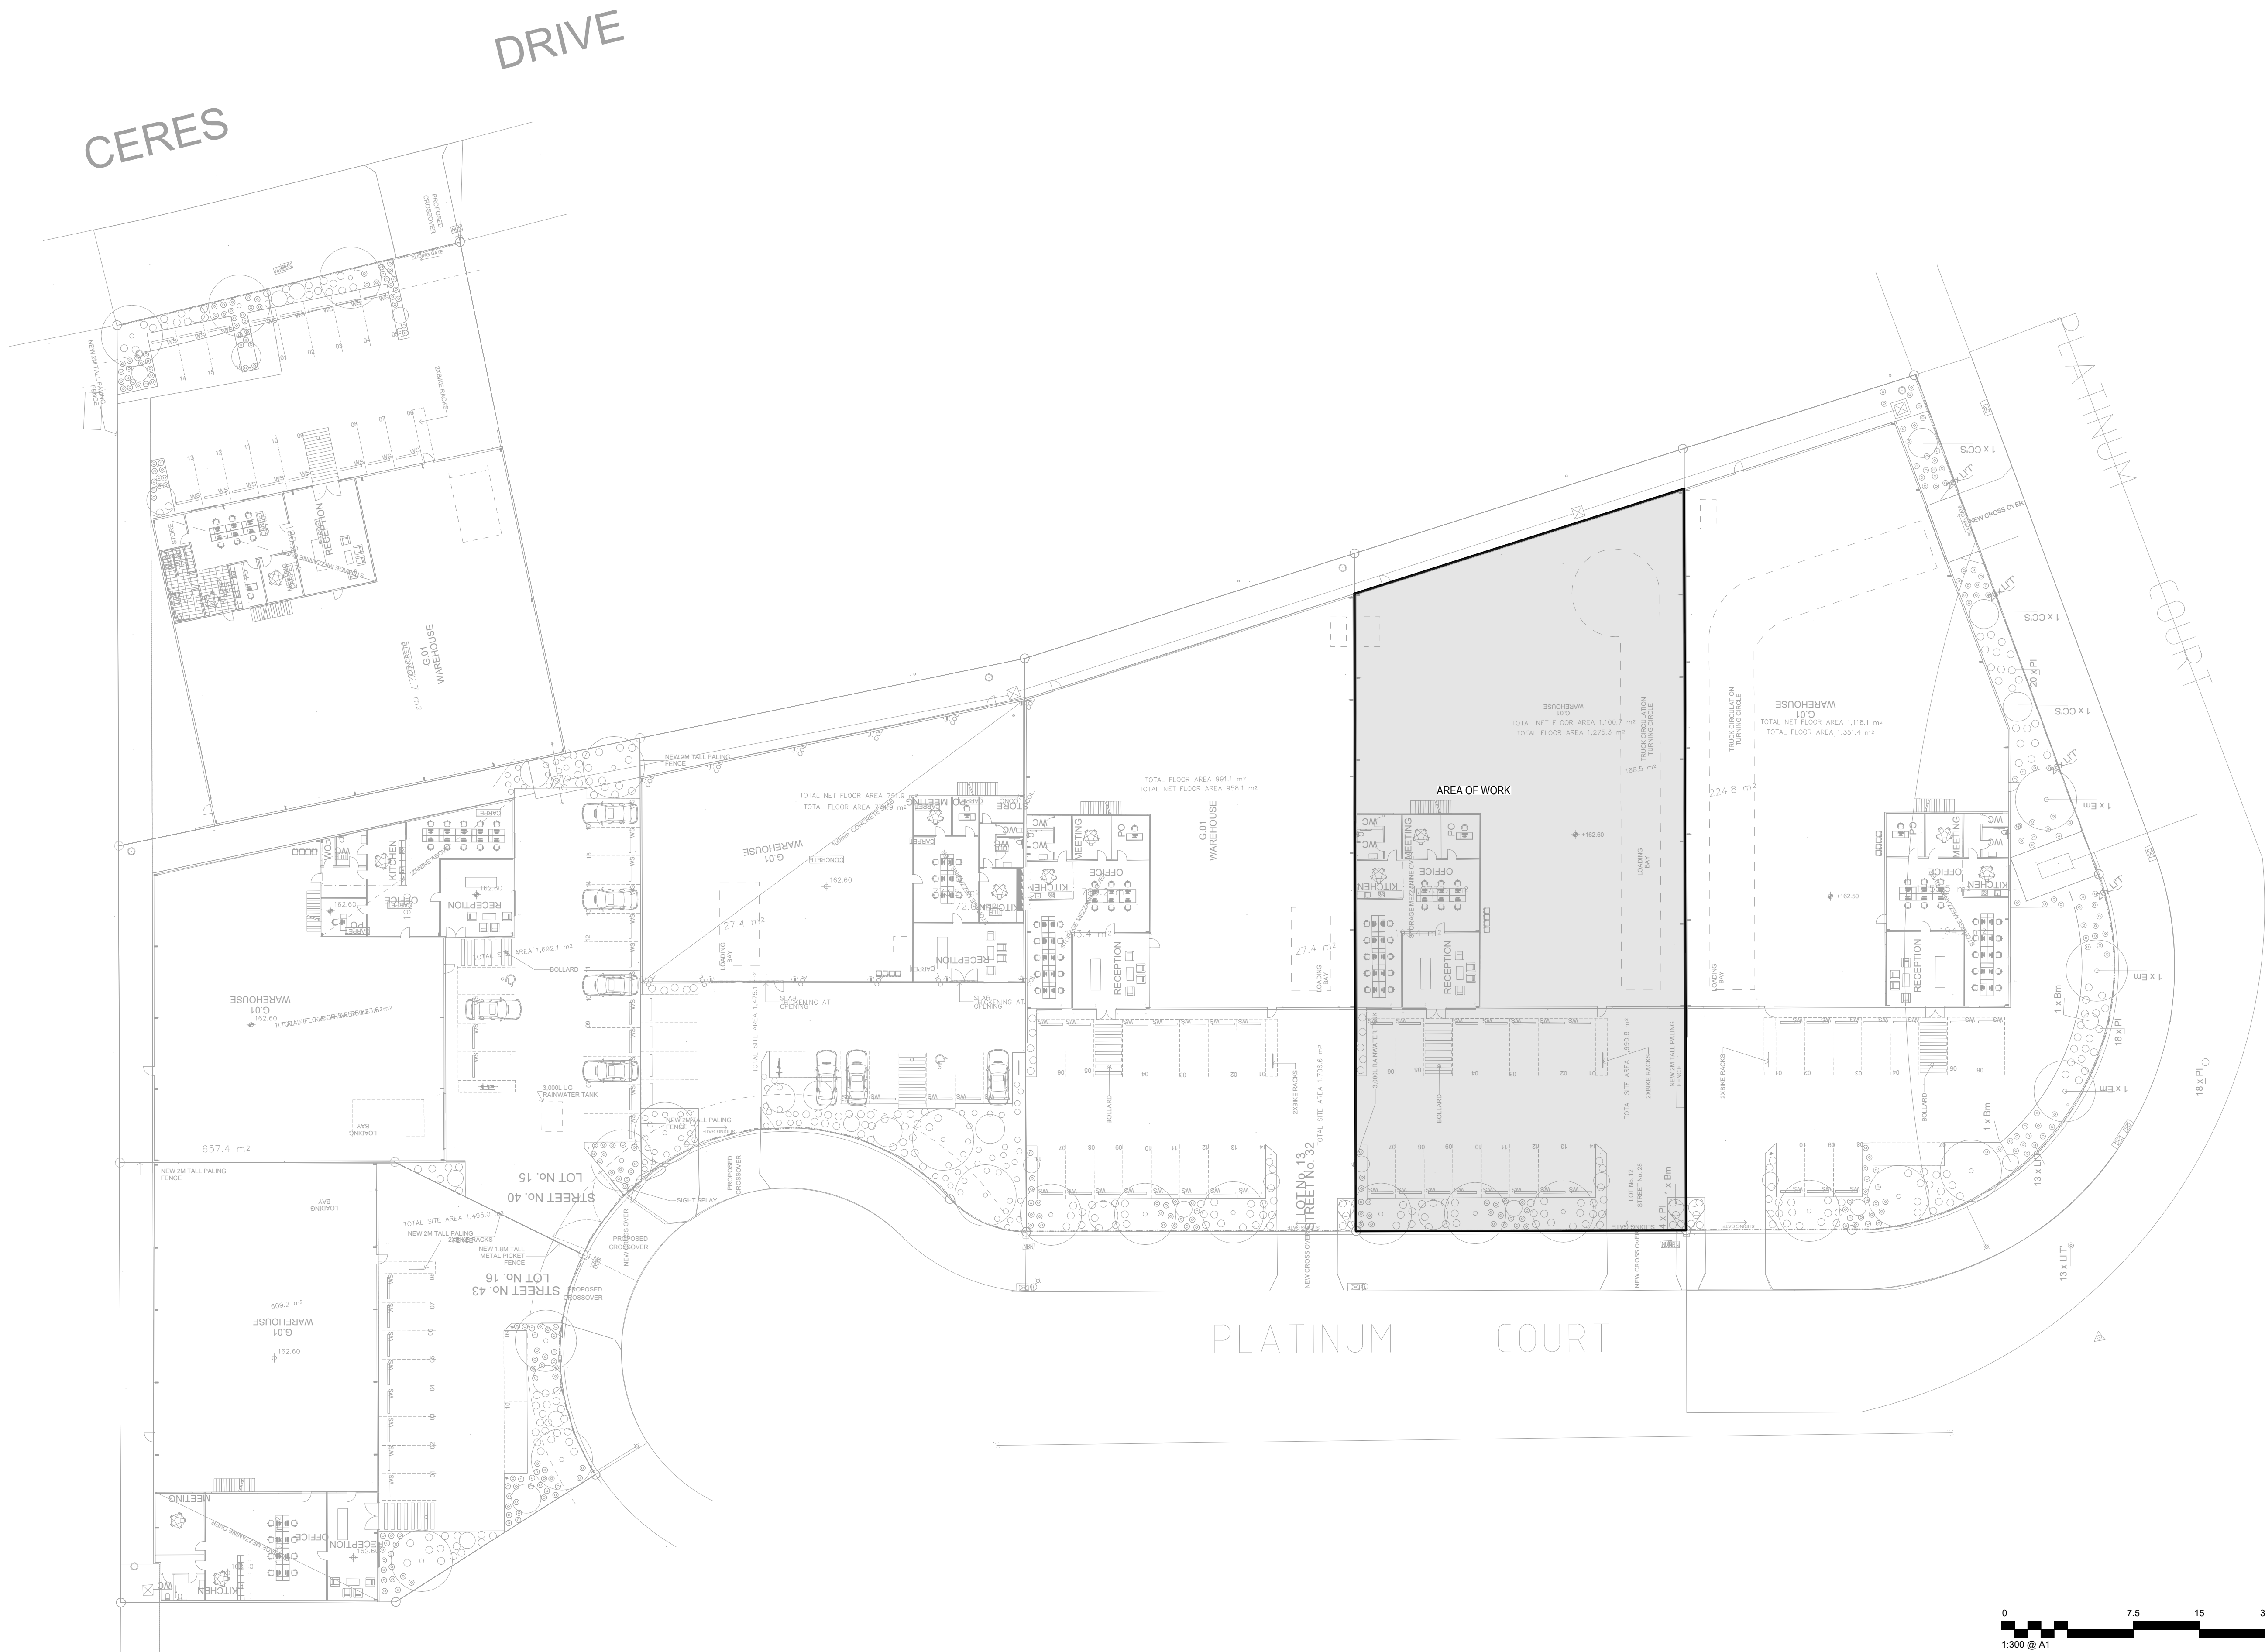



CENTRIC
Building Services Engineers

© **CENTRIC BUILDING SERVICES ENGINEERS PTY LTD**
This drawing is the property of Centric Building Services PTY Limited and must not be used, reproduced or copied wholly or in part without the written permission of Centric Building Services PTY Limited. The elements shown on this drawing are prototypical design only. The contractor shall produce workshop drawings for construction purposes. The contractor shall not scale from this drawing and all measurements shall be carried out on site.

P1 30.05.2025 100% FINAL COORDINATION

**100%
ISSUE**

**FIRE
SERVICES**


Project North



Client:
Architect: VINCENT JARVIS
Project Number: 24071
Drawing Number: FC100
Revision: P1
Drawn by: IB
Designed by: IB
Approved by: JA
Scale: 1:150 @ A1

NEW WAREHOUSE, 28 PLATINUM COURT, THRUGOONA, NSW,2640

LEVEL G FLOOR PLAN FIRE
HYDRANT COVERAGE LAYOUT

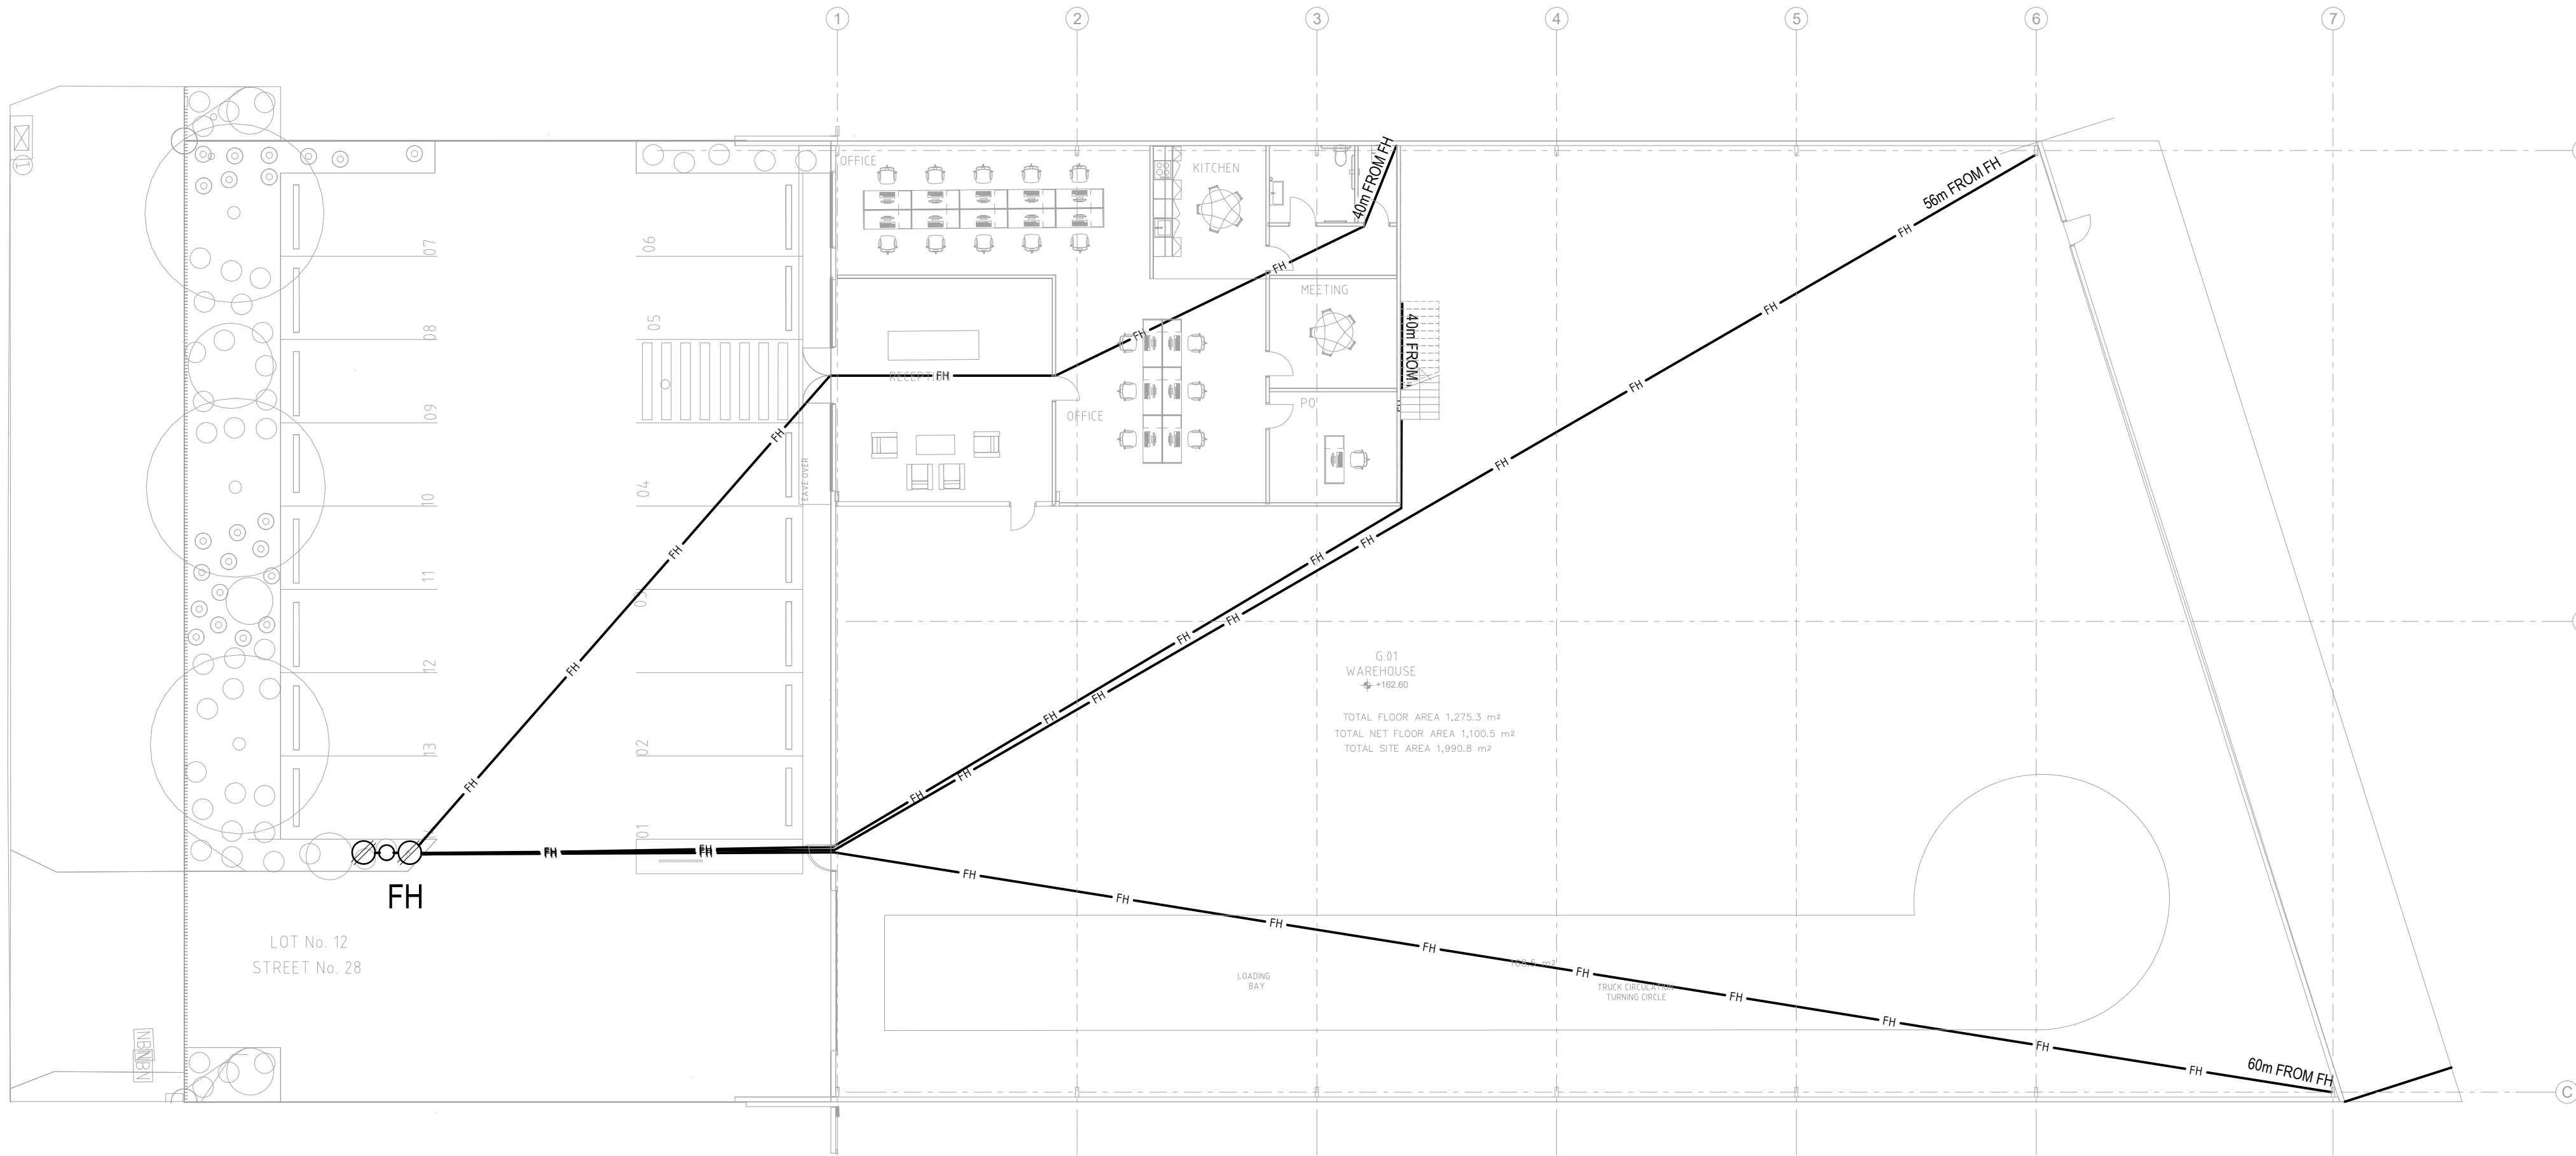

Sydney: (02) 9052 6460
Newcastle: (02) 9052 6461



Sydney: Suite 1, 401 Pacific Hwy
Artarmon, NSW 2064
Newcastle: Suite 4, 102 Glebe Road
The Junction, NSW 2291



info@centricengineers.com.au
www.centricengineers.com





© **CENTRIC BUILDING SERVICES ENGINEERS PTY LTD**
This drawing is the property of Centric Building Services PTY Limited and must not be used, reproduced or copied wholly or in part without the written permission of Centric Building Services PTY Limited. The elements shown on this drawing are prototypical design only. The contractor shall produce workshop drawings for construction purposes. The contractor shall not scale from this drawing and all measurements shall be carried out on site.

P1	30.05.2025	100% FINAL COORDINATION
----	------------	-------------------------

**100%
ISSUE**

FIRE SERVICES



Project North



Client:	
Architect:	VINCENT JARVIS
Project Number:	24071
Drawing Number:	FC101
Revision:	P1
Drawn by:	IB
Designed by:	IB
Approved by:	JA
Scale:	1:150 @ A1

NEW WAREHOUSE, 28 PLATINUM COURT, THRU GOONA, NSW, 2640

  LEVEL M FLOOR PLAN FIRE
HYDRANT COVERAGE LAYOUT





CENTRIC
Building Services Engineers

© **CENTRIC BUILDING SERVICES ENGINEERS PTY LTD**
This drawing is the property of Centric Building Services PTY Limited and must not be used, reproduced or copied wholly or in part without the written permission of Centric Building Services PTY Limited. The elements shown on this drawing are prototypical design only. The contractor shall produce workshop drawings for construction purposes. The contractor shall not scale from this drawing and all measurements shall be carried out on site.

P1 30.05.2025 100% FINAL COORDINATION

**100%
ISSUE**

**FIRE
SERVICES**

Project North



 

Client: VINCENT JARVIS
Architect:

Project Number: 24071
Drawing Number: FC200
Revision: P1

Drawn by: IB
Designed by: IB
Approved by: JA
Scale: 1:150 @ A1

NEW WAREHOUSE, 28 PLATINUM COURT, THRUGOONA, NSW,2640

LEVEL G FLOOR PLAN FIRE HOSE REEL COVERAGE LAYOUT

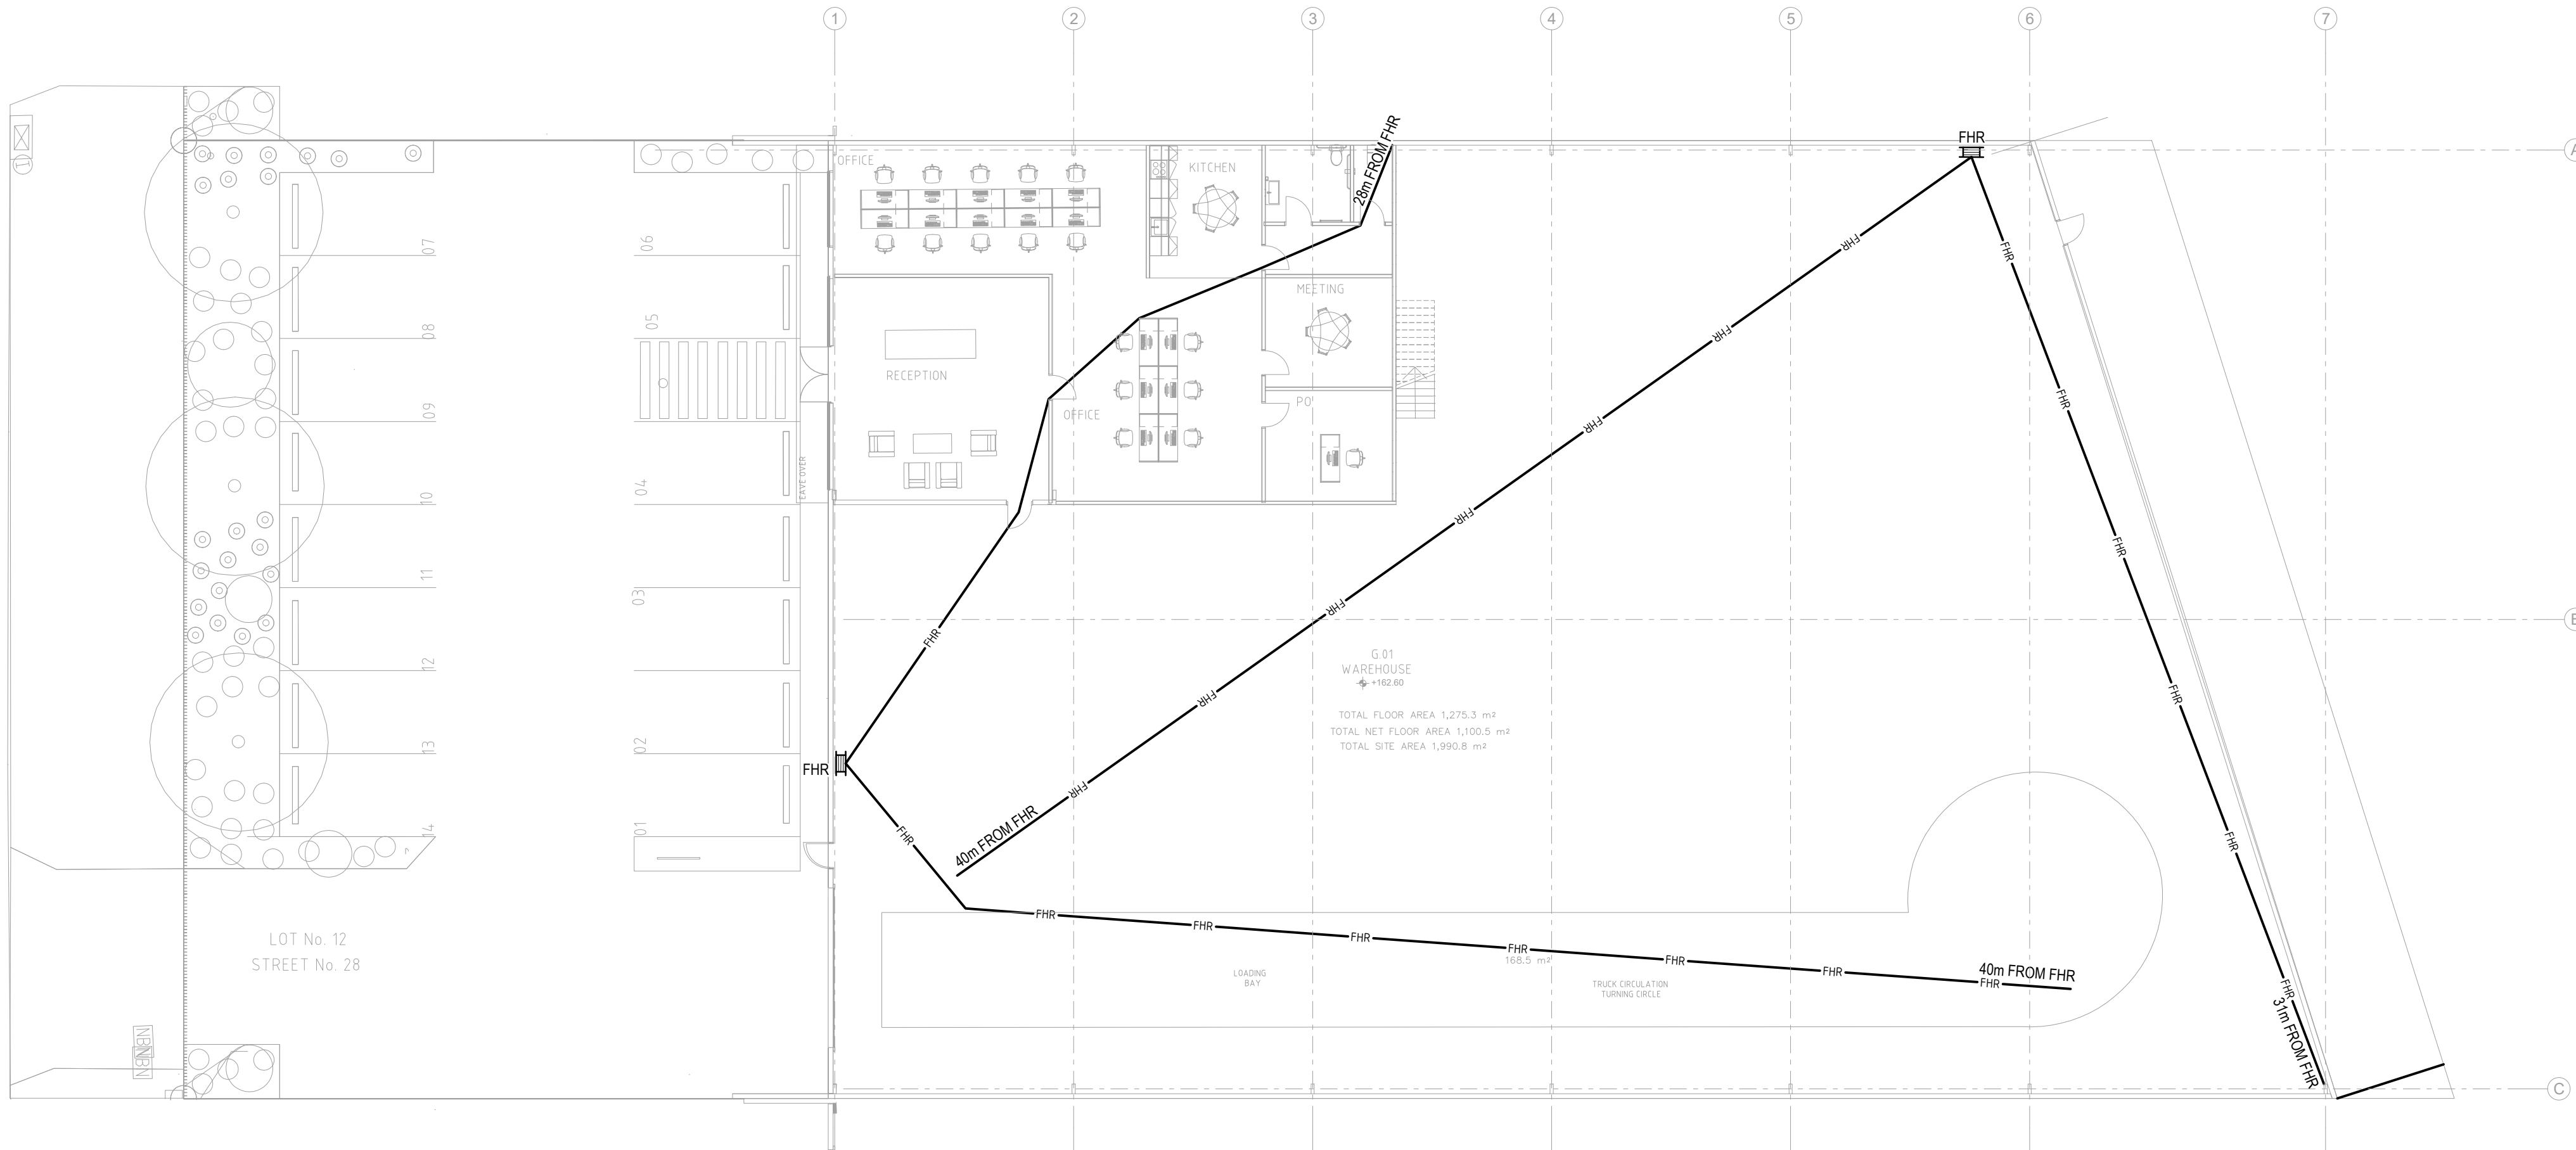

Sydney: (02) 9052 6460
Newcastle: (02) 9052 6461



Sydney: Suite 1, 401 Pacific Hwy
Artarmon, NSW 2064
Newcastle: Suite 4, 102 Glebe Road
The Junction, NSW 2291



info@centricengineers.com.au
www.centricengineers.com



0 3.75 7.5 15 30m
1:150 @ A1



CENTRIC
Building Services Engineers

© CENTRIC BUILDING SERVICES ENGINEERS PTY LTD
This drawing is the property of Centric Building Services PTY Limited and must not be used, reproduced or copied wholly or in part without the written permission of Centric Building Services PTY Limited. The elements shown on this drawing are prototypical design only. The contractor shall produce workshop drawings for construction purposes. The contractor shall not scale from this drawing and all measurements shall be carried out on site.

P1 30.05.2025 100% FINAL COORDINATION

100%
ISSUE

FIRE
SERVICES


Project North



Client:
Architect: VINCENT JARVIS
Project Number: 24071
Drawing Number: FC201
Revision: P1
Drawn by: IB
Designed by: IB
Approved by: JA
Scale: 1:150 @ A1

NEW WAREHOUSE, 28 PLATINUM
COURT, THRUGOONA, NSW,2640

LEVEL M FLOOR PLAN FIRE HOSE
REEL COVERAGE LAYOUT

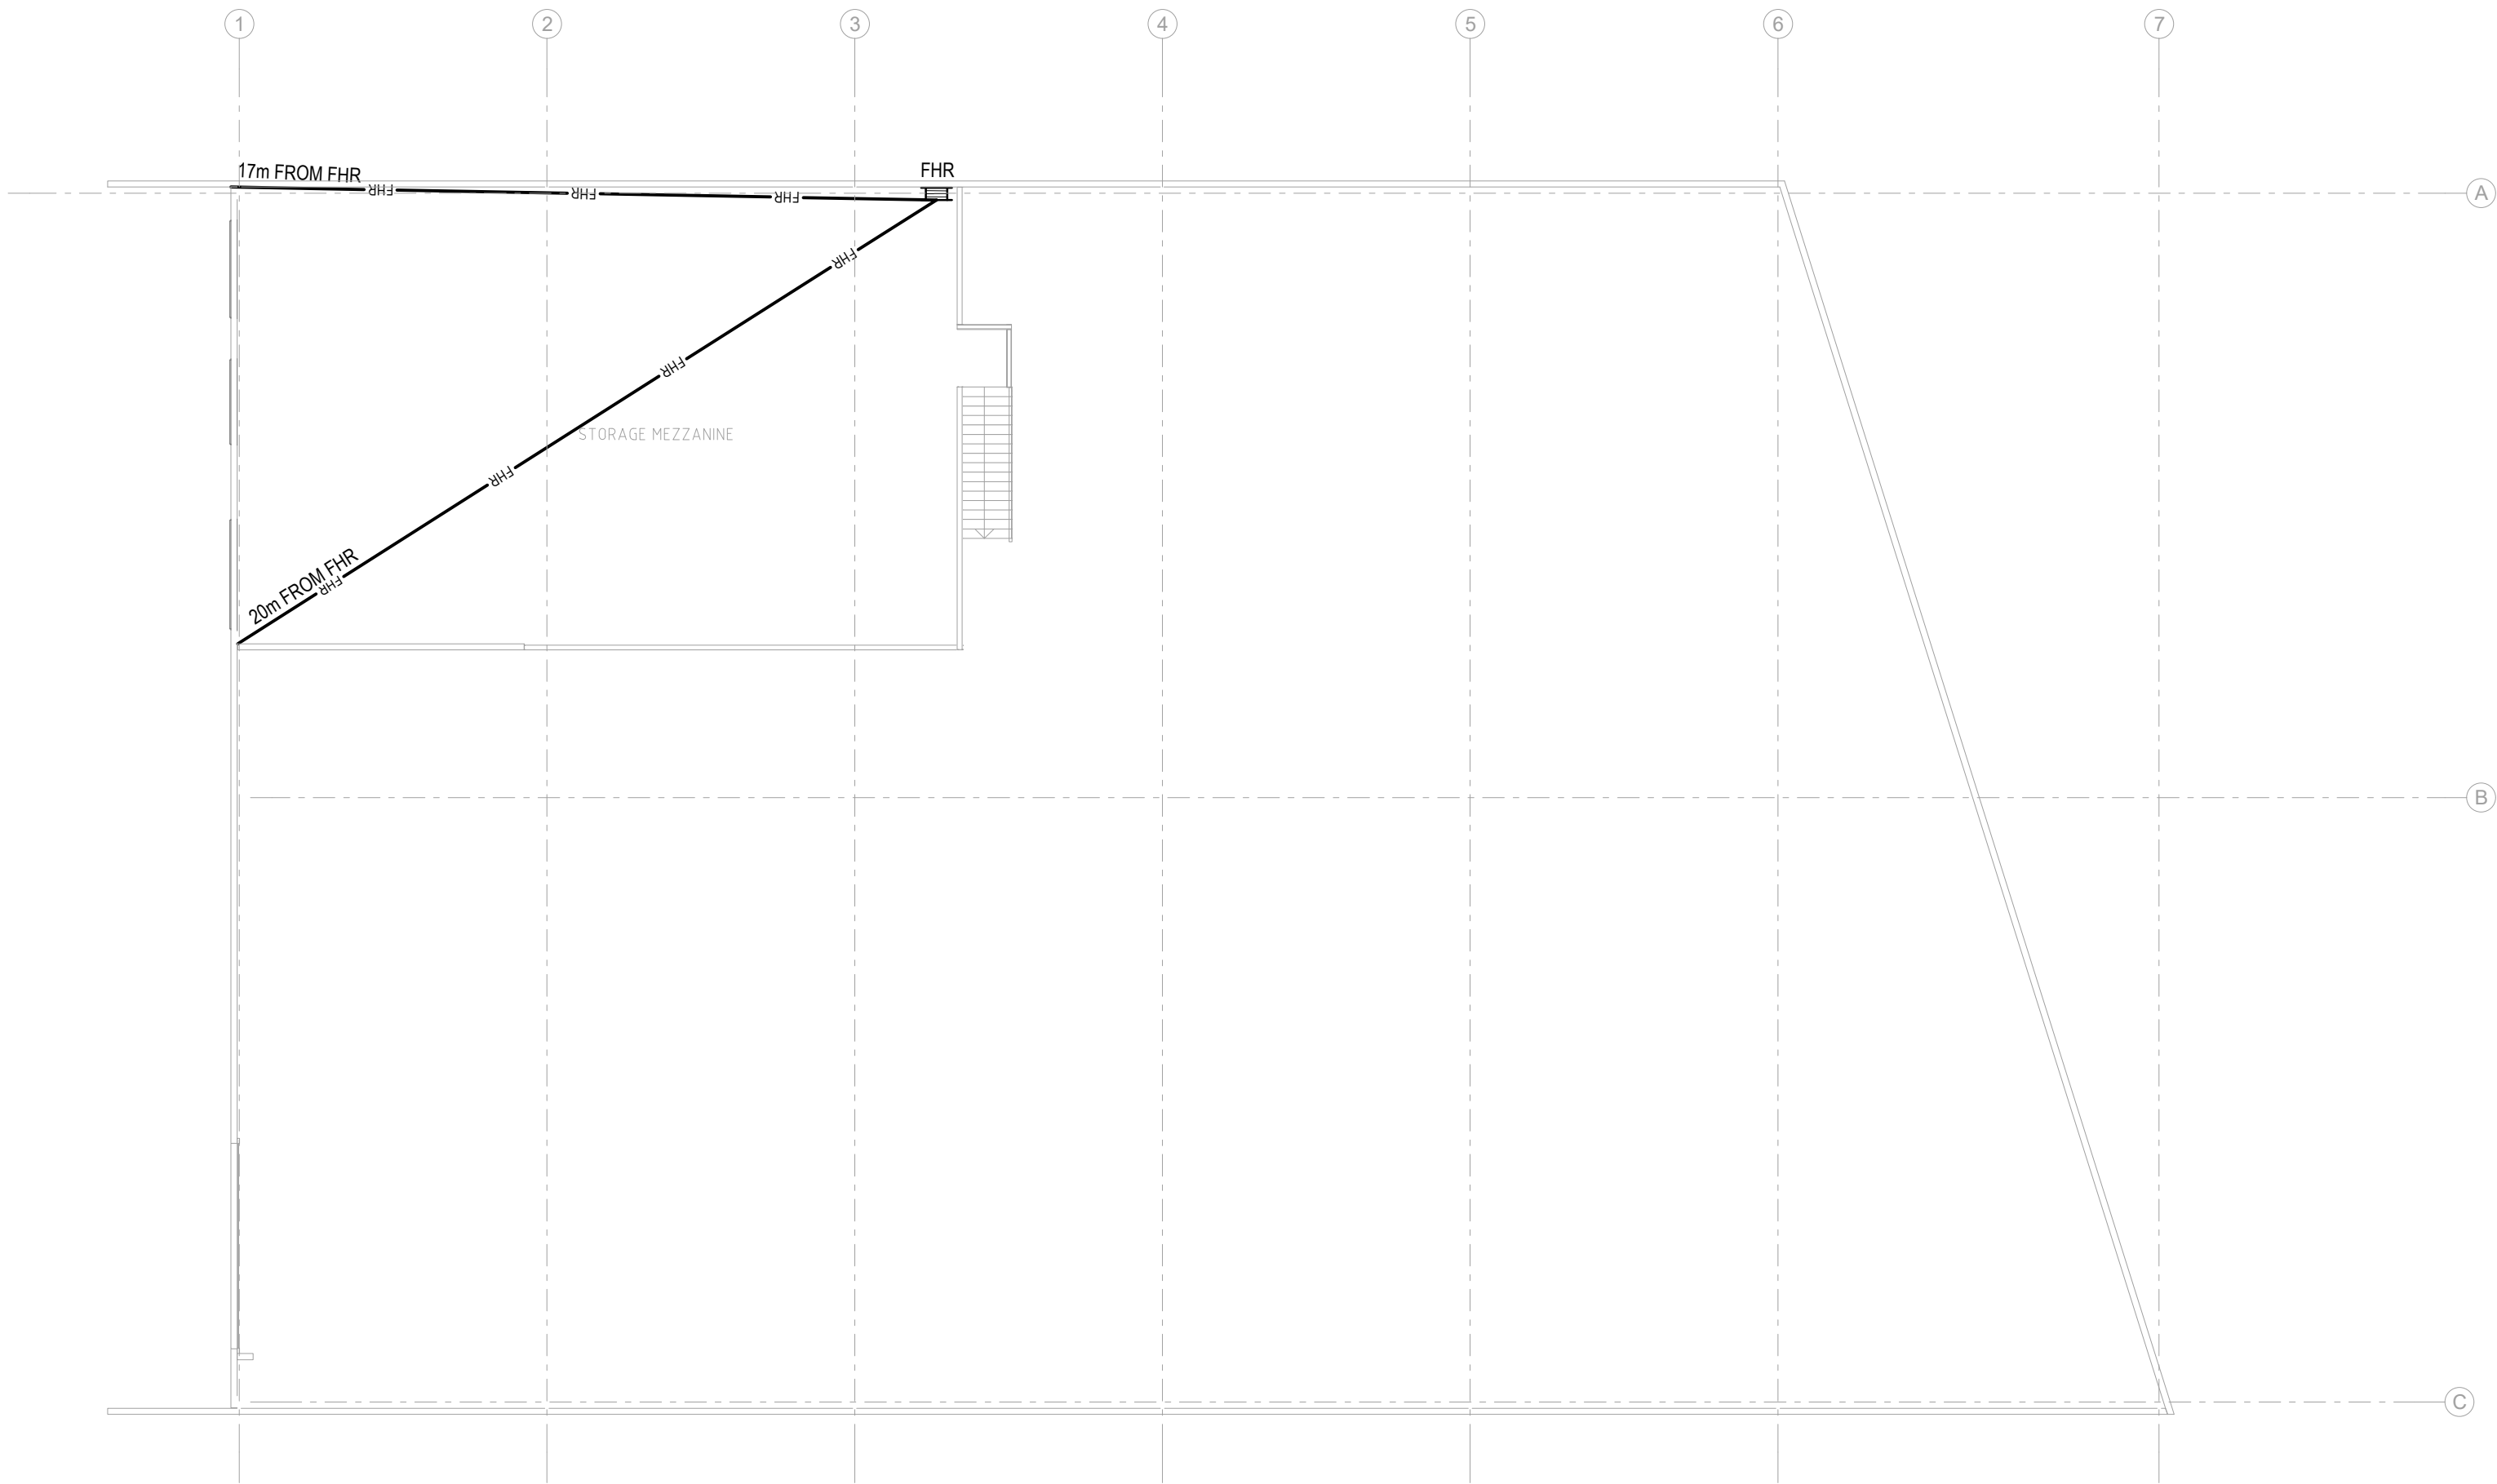

0 3.75 7.5 15 30m
1:150 @ A1



Sydney: (02) 9052 6460
Newcastle: (02) 9052 6461



Sydney: Suite 1, 401 Pacific Hwy
Artarmon, NSW 2064
Newcastle: Suite 4, 102 Glebe Road
The Junction, NSW 2291



info@centricengineers.com.au
www.centricengineers.com



DOCUMENT REGISTER & TRANSMITTAL NOTICE



CENTRIC ENGINEERS
Building Services

Centric Building Services Engineers Pty Ltd
Sydney: Suite 1, 401 Pacific Hwy, Artarmon, NSW 2064
Newcastle: Suite 4, 102 Glebe Road, The Junction, NSW, 2291
Sydney: +61 - (02) 9052 6460 | Newcastle: +61 - (02) 9052 6461
info@centricengineers.com.au
www.centricengineers.com.au

Job Title: NEW WAREHOUSE
Address: 28 PLATINUM COURT THRUGOONA NSW 2640
Job No: 24071
Discipline: Fire Coverage

Distribution		Attention		Number of Copies															
		1																	
Purpose: A = Approval C = Construction I = Info T = Tender P = Prelim		P																	
Format: D = Dwg H = Hard Copy P = Pdf T = Plt		P																	
Method: C = Courier H = Hand M = Mail E = Email W = Website		E																	
Date of Issue:		Day	30																
		Month	05																
		Year	25																
Issued By:		IB																	
Document Title		Document No		Revision															
Cover Sheet, Legend & Drawing Schedule		FC000	P1																
Site Services		FC001	P1																
Ground Floor Plan Fire Hydrant Coverage Layout		FC100	P1																
Mezzanine Floor Plan Fire Hydrant Coverage Layout		FC101	P1																
Ground Floor Plan Fire Hose Reel Coverage Layout		FC200	P1																
Mezzanine Floor Plan Fire Hose Reel Coverage Layout		FC201	P1																
																			</