

NEW WAREHOUSE

36 PLATINUM COURT THRUGOONA NSW 2640

FIRE SERVICES

| DRAWING SCHEDULE: |                                                   |
|-------------------|---------------------------------------------------|
| NUMBER            | TITLE                                             |
| FC000             | COVERSHEET, LEGENDS, NOTES AND DRAWING LIST       |
| FC001             | SITE SERVICES                                     |
| FC100             | LEVEL G FLOOR PLAN FIRE HYDRANT COVERAGE LAYOUT   |
| FC101             | LEVEL M FLOOR PLAN FIRE HYDRANT COVERAGE LAYOUT   |
| FC200             | LEVEL G FLOOR PLAN FIRE HOSE REEL COVERAGE LAYOUT |
| FC201             | LEVEL M FLOOR PLAN FIRE HOSE REEL COVERAGE LAYOUT |

| PIPEWORK                                                                            |                | SYMBOLS                                                                             |                     |
|-------------------------------------------------------------------------------------|----------------|-------------------------------------------------------------------------------------|---------------------|
|  | FIRE HYDRANT   |  | FIRE HYDRANT        |
|  | FIRE HOSE REEL |  | DOUBLE FIRE HYDRANT |
|                                                                                     |                |  | FIRE HOSE REEL      |
|                                                                                     |                |  | STREET HYDRANT      |



CENTRIC  
Building Services Engineers

© CENTRIC BUILDING SERVICES ENGINEERS PTY LTD  
This drawing is the property of Centric Building Services PTY Limited and must not be used, reproduced or copied wholly or in part without the written permission of Centric Building Services Pty Limited. The elements shown on this drawing are prototypical design only. The contractor shall produce workshop drawings for construction purposes. The contractor shall not scale from this drawing and all measurements shall be carried out on site.

P1 30.05.2025 100% FINAL COORDINATION

FIRE SERVICES

NEW WAREHOUSE

36 PLATINUM COURT  
THRUGOONA NSW 2640

Project Number:  
24071

Drawing Number:  
FC000

Revision:  
P1



Sydney: (02) 9052 6460  
Newcastle: (02) 9052 6461



**Sydney:** Suite 1, 401 Pacific Hwy  
Artarmon, NSW 2064  
**Newcastle:** Suite 4, 102 Glebe Road  
The Junction, NSW 2291



info@centricengineers.com.au  
www.centricengineers.com







**CENTRIC**  
Building Services Engineers


© CENTRIC BUILDING SERVICES ENGINEERS PTY LTD  
This drawing is the property of Centric Building Services PTY Limited and must not be used, reproduced or copied wholly or in part without the written permission of Centric Building Services PTY Limited. The elements shown on this drawing are prototypical design only. The contractor shall produce workshop drawings for construction purposes. The contractor shall not scale from this drawing and all measurements shall be carried out on site.

P1 30.05.2025 100% FINAL COORDINATION

**100%  
ISSUE**

**FIRE  
SERVICES**

Project North

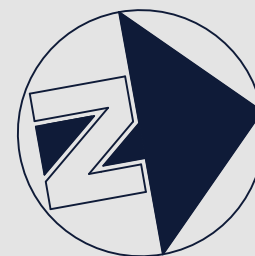

Client: VINCENT JARVIS  
Architect:

Project Number: 24071  
Drawing Number: FC100  
Revision: P1

Drawn by: IB  
Designed by: IB  
Approved by: JA  
Scale: 1:300 @ A1

NEW WAREHOUSE, 36 PLATINUM COURT, THRUGOONA, NSW.2640

SITE SERVICES

Sydney: (02) 9052 6460  
Newcastle: (02) 9052 6461

Sydney: Suite 1, 401 Pacific Hwy  
Artarmon, NSW 2064  
Newcastle: Suite 4, 102 Glebe Road  
The Junction, NSW 2291

info@centricengineers.com.au  
www.centricengineers.com







**CENTRIC**  
Building Services Engineers

© CENTRIC BUILDING SERVICES ENGINEERS PTY LTD  
This drawing is the property of Centric Building Services PTY Limited and must not be used, reproduced or copied wholly or in part without the written permission of Centric Building Services PTY Limited. The elements shown on this drawing are prototypical design only. The contractor shall produce workshop drawings for construction purposes. The contractor shall not scale from this drawing and all measurements shall be carried out on site.

P1 30.05.2025 100% FINAL COORDINATION

**100%  
ISSUE**

**FIRE  
SERVICES**

Project North



Client:  
Architect: VINCENT JARVIS  
Project Number: 24071  
Drawing Number: FC100  
Revision: P1  
Drawn by: IB  
Designed by: IB  
Approved by: JA  
Scale: 1:100 @ A1

NEW WAREHOUSE, 36 PLATINUM  
COURT, THRUGOONA, NSW.2640

LEVEL G FLOOR PLAN  
FIRE HYDRANT COVERAGE LAYOUT



Sydney: (02) 9052 6460  
Newcastle: (02) 9052 6461

**Sydney:** Suite 1, 401 Pacific Hwy  
Artarmon, NSW 2064  
**Newcastle:** Suite 4, 102 Glebe Road  
The Junction, NSW 2291

info@centricengineers.com.au  
www.centricengineers.com



0 2 4 6 8 10 m  
1:100 @ A1





CENTRIC  
Building Services Engineers


© CENTRIC BUILDING SERVICES ENGINEERS PTY LTD  
This drawing is the property of Centric Building Services PTY Limited and must not be used, reproduced or copied wholly or in part without the written permission of Centric Building Services Pty Limited. The elements shown on this drawing are prototypical design only. The contractor shall produce workshop drawings for construction purposes. The contractor shall not scale from this drawing and all measurements shall be carried out on site.

P1 30.05.2025 100% FINAL COORDINATION

100%  
ISSUE

FIRE  
SERVICES

Project North

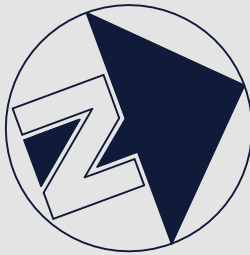


Client:  
Architect: VINCENT JARVIS

Project Number: 24071  
Drawing Number: FC101  
Revision: P1

Drawn by: IB  
Designed by: IB  
Approved by: JA  
Scale: 1:100 @ A1

NEW WAREHOUSE, 36 PLATINUM  
COURT, THRUGOONA, NSW.2640

LEVEL M FLOOR PLAN  
FIRE HYDRANT COVERAGE LAYOUT

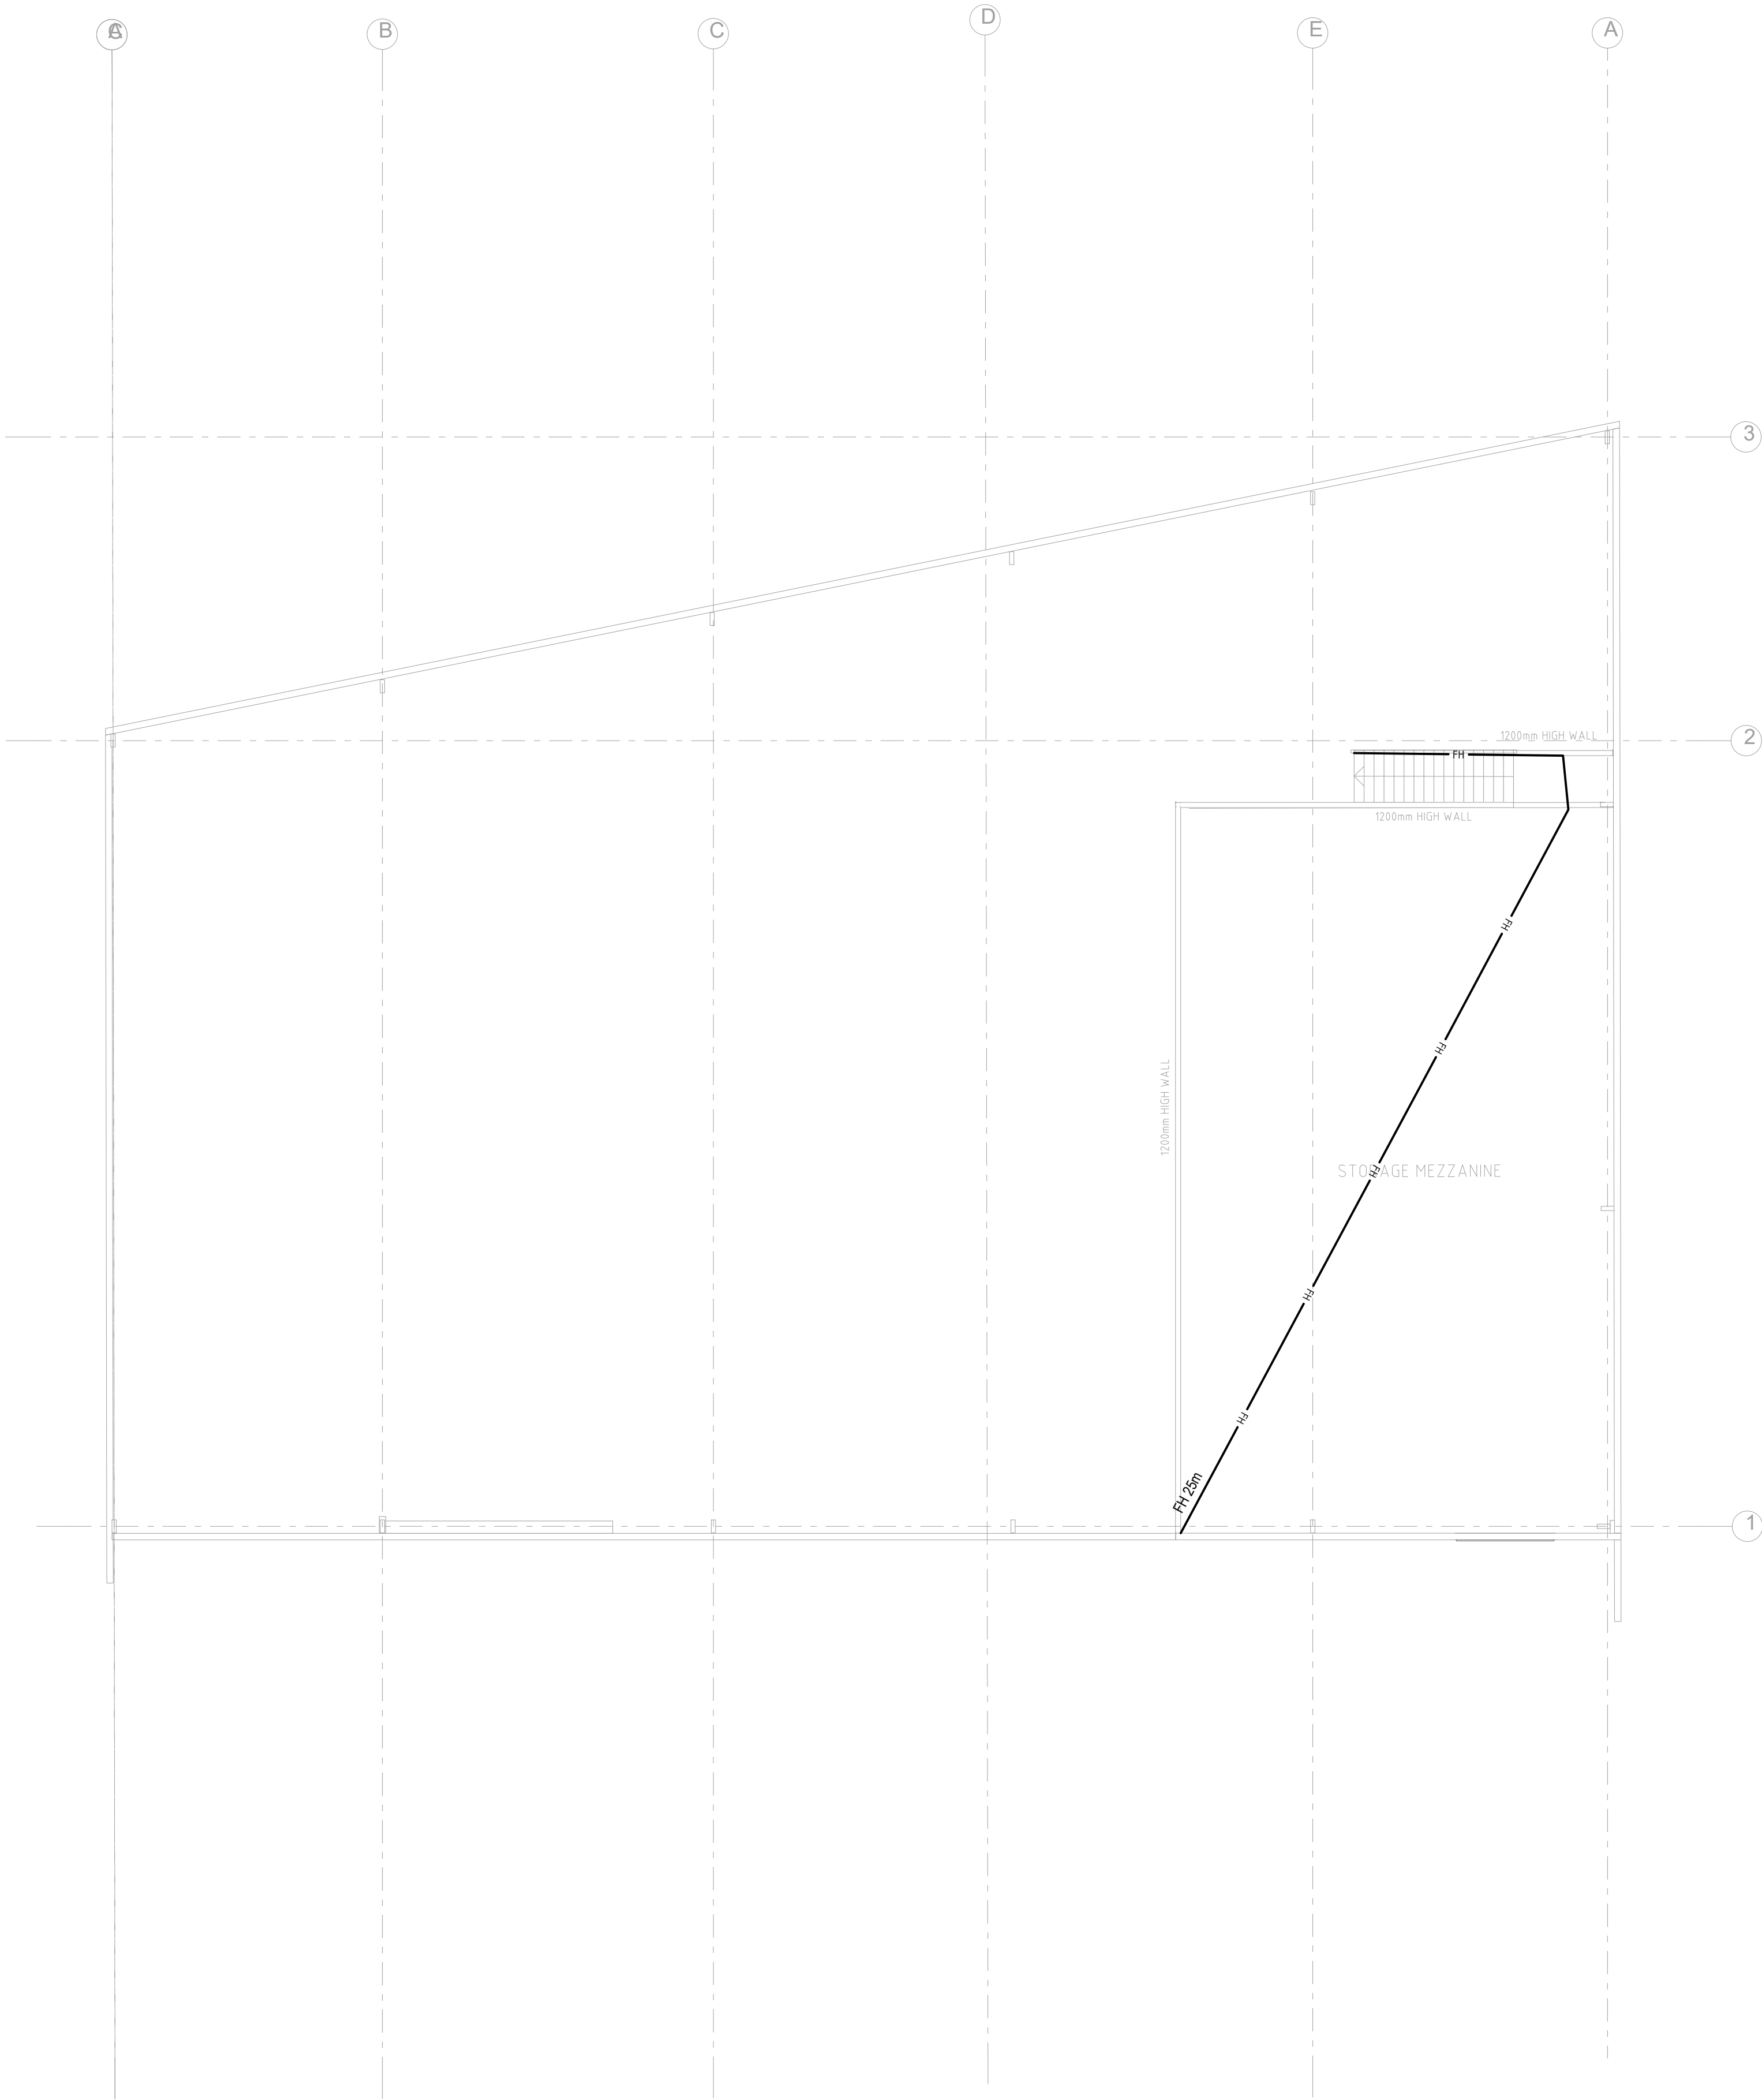

Sydney: (02) 9052 6460  
Newcastle: (02) 9052 6461



**Sydney:** Suite 1, 401 Pacific Hwy  
Artarmon, NSW 2064  
**Newcastle:** Suite 4, 102 Glebe Road  
The Junction, NSW 2291



info@centricengineers.com.au  
www.centricengineers.com







**CENTRIC**  
Building Services Engineers


© CENTRIC BUILDING SERVICES ENGINEERS PTY LTD  
This drawing is the property of Centric Building Services PTY Limited and must not be used, reproduced or copied wholly or in part without the written permission of Centric Building Services PTY Limited. The elements shown on this drawing are prototypical design only. The contractor shall produce workshop drawings for construction purposes. The contractor shall not scale from this drawing and all measurements shall be carried out on site.

P1 30.05.2025 100% FINAL COORDINATION

**100%  
ISSUE**

**FIRE  
SERVICES**

Project North

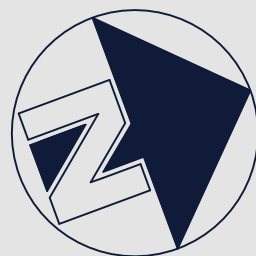

Client: VINCENT JARVIS

Project Number: 24071  
Drawing Number: FC200  
Revision: P1

Drawn by: IB  
Designed by: IB  
Approved by: JA  
Scale: 1:100 @ A1

NEW WAREHOUSE, 36 PLATINUM  
COURT, THRUGOONA, NSW.2640

LEVEL G FLOOR PLAN  
FIRE HOSE REEL COVERAGE LAYOUT





Sydney: (02) 9052 6460  
Newcastle: (02) 9052 6461



**Sydney:** Suite 1, 401 Pacific Hwy  
Artarmon, NSW 2064  
**Newcastle:** Suite 4, 102 Glebe Road  
The Junction, NSW 2291



info@centricengineers.com.au  
www.centricengineers.com

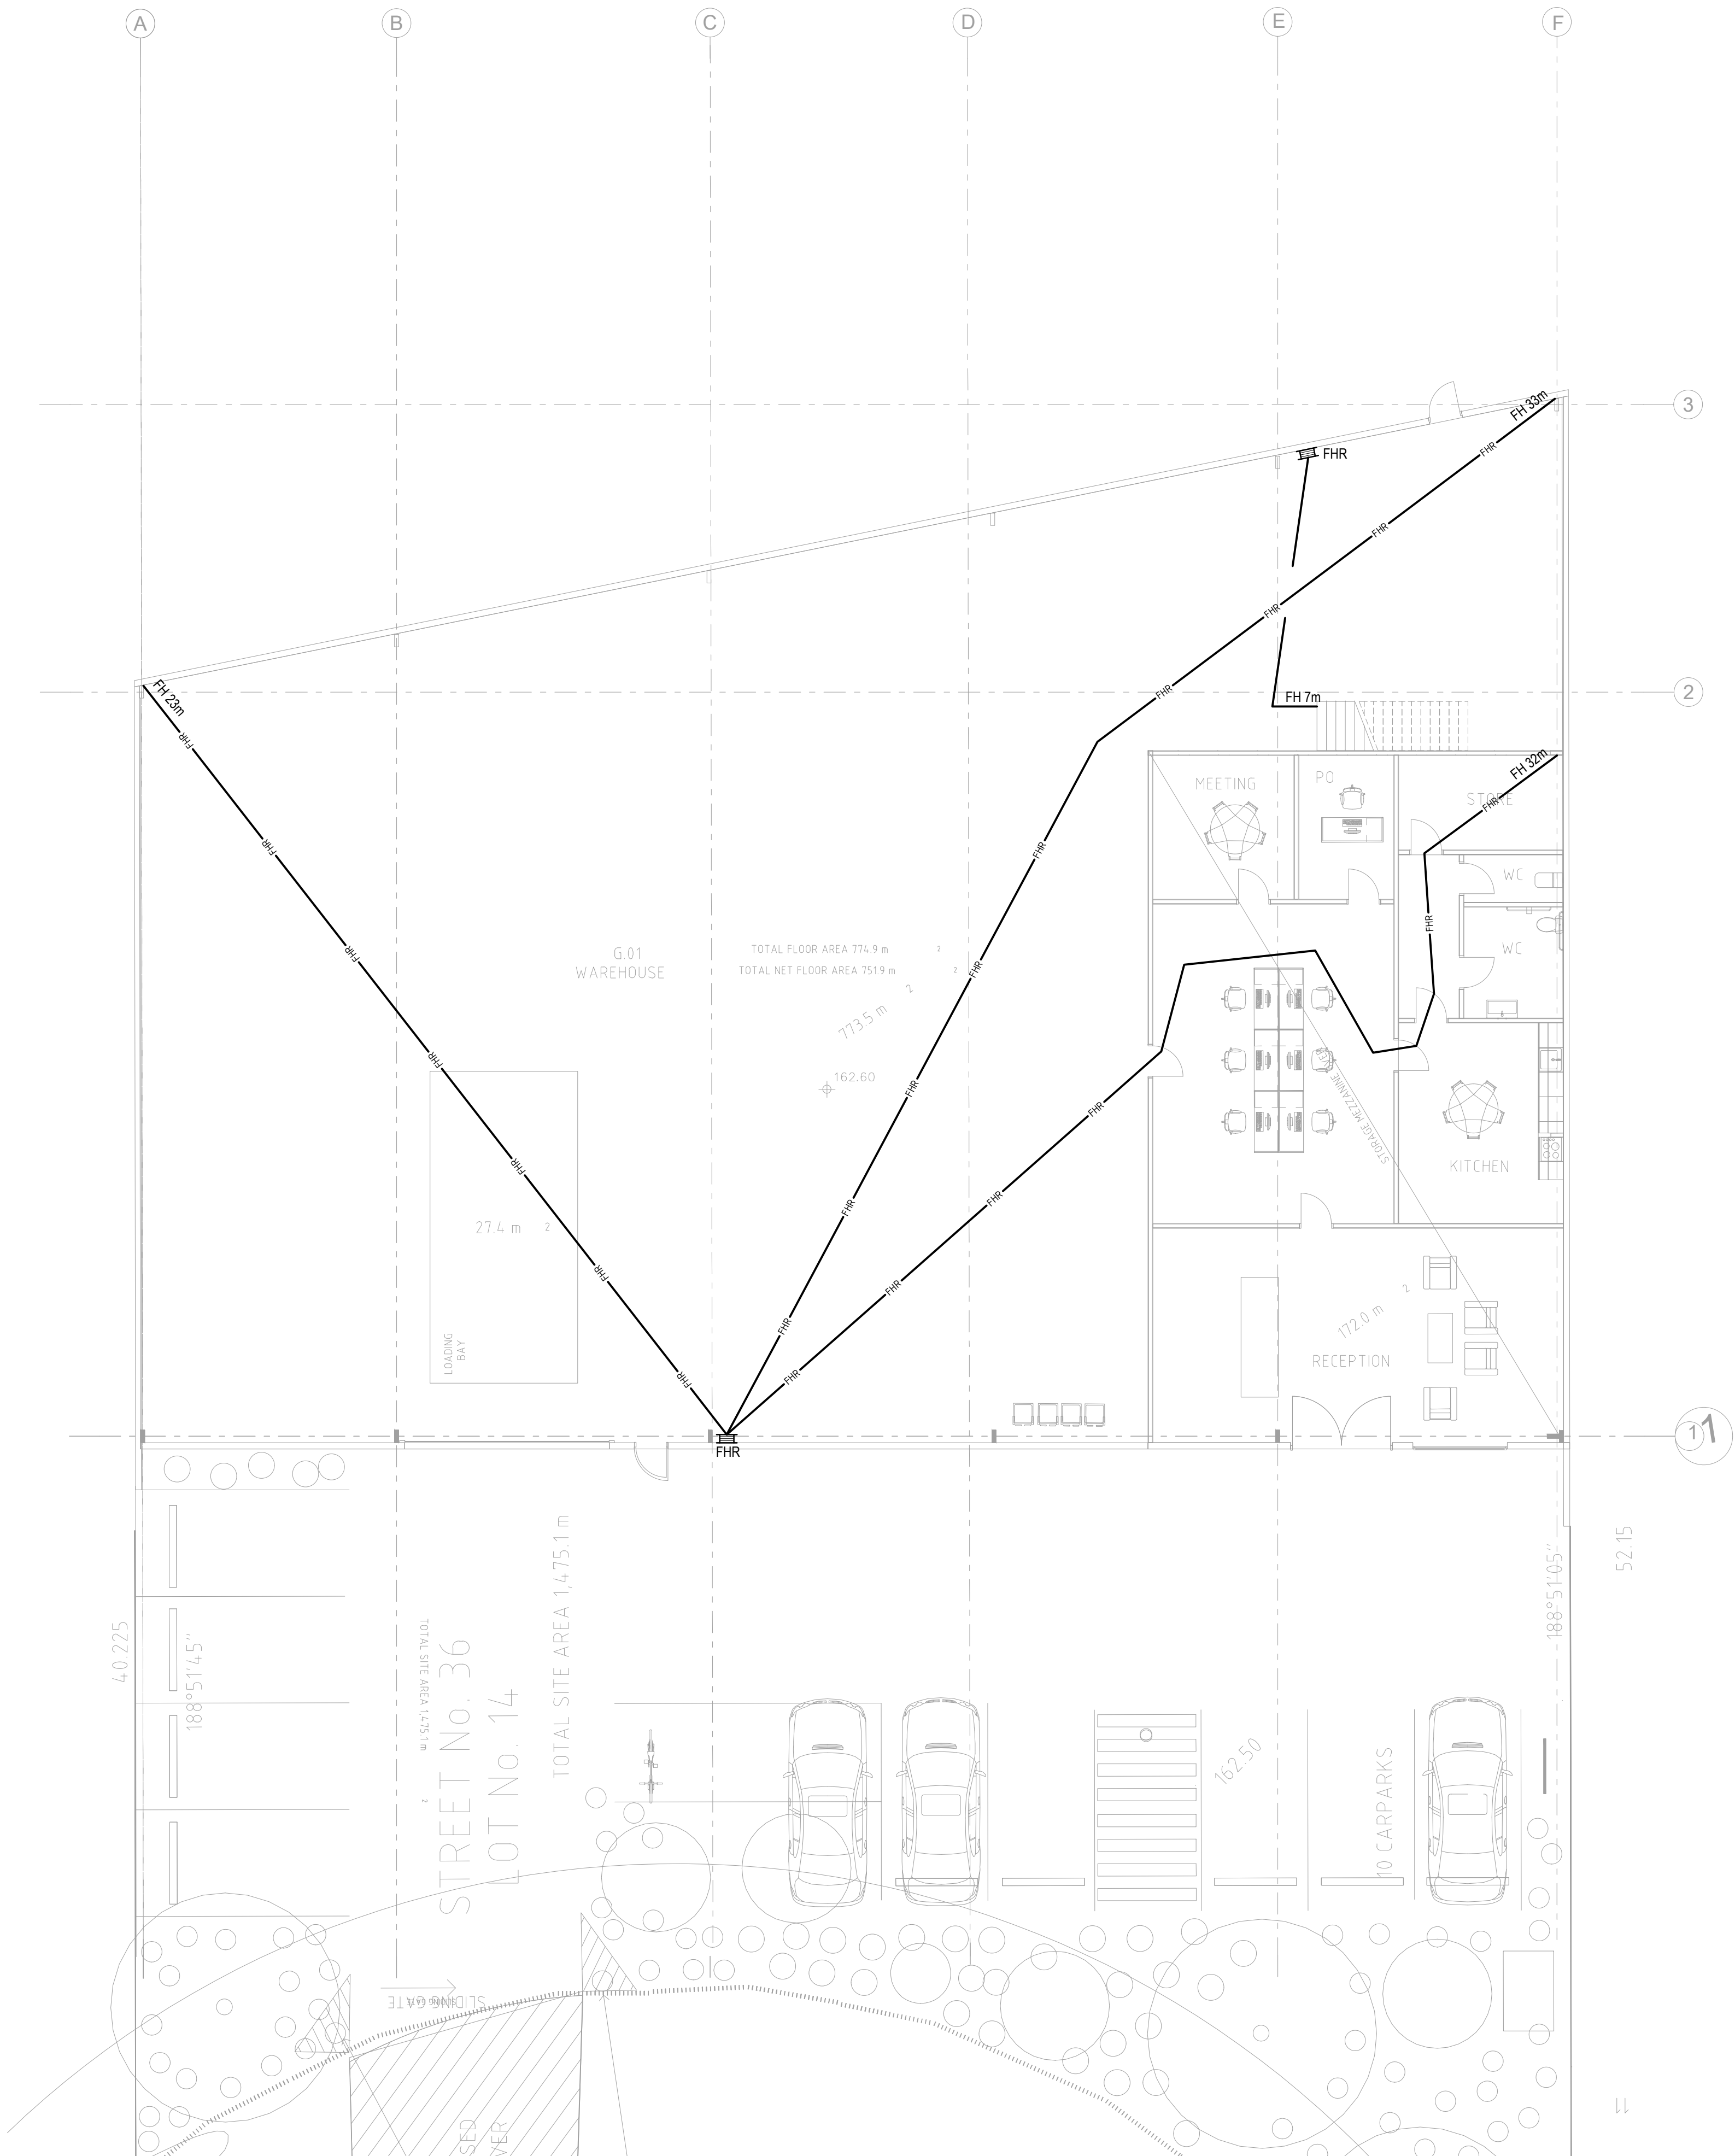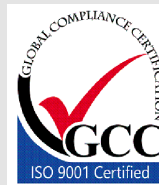






© **CENTRIC BUILDING SERVICES ENGINEERS PTY LTD**  
This drawing is the property of Centric Building Services PTY Limited and must not be used, reproduced or copied wholly or in part without the written permission of Centric Building Services PTY Limited. The elements shown on this drawing are prototypical design only. The contractor shall produce workshop drawings for construction purposes. The contractor shall not scale from this drawing and all measurements shall be carried out on site.

|    |            |                         |
|----|------------|-------------------------|
| P1 | 30.05.2025 | 100% FINAL COORDINATION |
|----|------------|-------------------------|

**100%  
ISSUE**

## FIRE SERVICES

## Project North

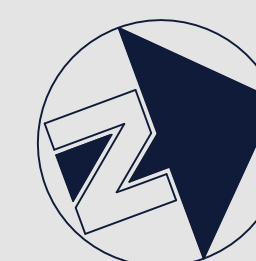




Client:  
Architect: VINCENT JARVIS

Project Number: 24071  
Drawing Number: FC201  
Revision: P1

Drawn by: IB  
Designed by: IB  
Approved by: JA  
Scale: 1:100 @ A1

NEW WAREHOUSE, 36 PLATINUM COURT, THRUGOONA, NSW, 2640

  LEVEL M FLOOR PLAN  
FIRE HOSE REEL COVERAGE LAYOUT

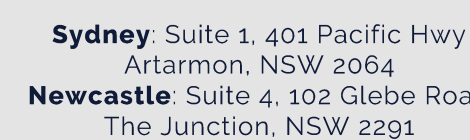



## DOCUMENT REGISTER & TRANSMITTAL NOTICE



**Centric Building Services Engineers Pty Ltd**  
 Sydney: Suite 1, 401 Pacific Hwy, Artarmon, NSW 2064  
 Newcastle: Suite 4, 102 Glebe Road, The Junction, NSW, 2291  
 Sydney: +61 - (02) 9052 6460 | Newcastle: +61 - (02) 9052 6461  
[info@centricengineers.com.au](mailto:info@centricengineers.com.au)  
[www.centricengineers.com.au](http://www.centricengineers.com.au)

**Job Title: NEW WAREHOUSE**  
**Address: 36 PLATINUM COURT THRU GOONA NSW 2640**  
**Job No: 24071**  
**Discipline: Fire Coverage**

[illegible]