

NEW WAREHOUSE

39 CERES DRIVE THURGOONA NSW 2640

FIRE SERVICES

DRAWING SCHEDULE:	
NUMBER	TITLE
FC000	COVERSHEET, LEGENDS, NOTES AND DRAWING LIST
FC001	SITE SERVICES
FC100	LEVEL G FLOOR PLAN FIRE HYDRANT COVERAGE LAYOUT
FC101	LEVEL M FLOOR PLAN FIRE HYDRANT COVERAGE LAYOUT
FC200	LEVEL G FLOOR PLAN FIRE HOSE REEL COVERAGE LAYOUT
FC201	LEVEL M FLOOR PLAN FIRE HOSE REEL COVERAGE LAYOUT

PIPEWORK		SYMBOLS	
	FH		FIRE HYDRANT
	FHR		DOUBLE FIRE HYDRANT
			FHR
			SFH
			FIRE HOSE REEL
			STREET HYDRANT



CENTRIC
Building Services Engineers

© CENTRIC BUILDING SERVICES ENGINEERS PTY LTD
This drawing is the property of Centric Building Services PTY Limited and must not be used, reproduced or copied wholly or in part without the written permission of Centric Building Services Pty Limited. The elements shown on this drawing are prototypical design only. The contractor shall produce workshop drawings for construction purposes. The contractor shall not scale from this drawing and all measurements shall be carried out on site.

P1	01.04.2025	100% CLIENT REVIEW
P2	30.05.2025	100% FINAL COORDINATION

FIRE SERVICES

NEW WAREHOUSE

39 CERES DRIVE
THURGOONA NSW 2640

Project Number:	24071
Drawing Number:	FC000
Revision:	P2



Sydney: (02) 9052 6460
Newcastle: (02) 9052 6461



Sydney Suite 1, 401 Pacific Hwy
Artarmon, NSW 2064
Newcastle Suite 4, 102 Glebe Road
The Junction, NSW 2291



info@centricengineers.com.au
www.centricengineers.com





CENTRIC
Building Services Engineers


© CENTRIC BUILDING SERVICES ENGINEERS PTY LTD
This drawing is the property of Centric Building Services PTY Limited and must not be used, reproduced or copied wholly or in part without the written permission of Centric Building Services PTY Limited. The elements shown on this drawing are prototypical design only. The contractor shall produce workshop drawings for construction purposes. The contractor shall not scale from this drawing and all measurements shall be carried out on site.

P1 01.04.2025 100% CLIENT REVIEW
P2 30.05.2025 100% FINAL COORDINATION

**100%
ISSUE**

**FIRE
SERVICES**

Project North

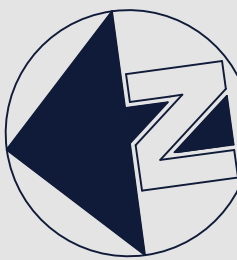

Client: VINCENT JARVIS
Architect:

Project Number: 24071
Drawing Number: FC100
Revision: P2

Drawn by: IB
Designed by: IB
Approved by: JA
Scale: 1:300 @ A1


NEW WAREHOUSE, 39 CERES
DRIVE, THURGOONA, NSW.2640

SITE SERVICES

Sydney: (02) 9052 6460
Newcastle: (02) 9052 6461

Sydney: Suite 1, 401 Pacific Hwy
Artarmon, NSW 2064
Newcastle: Suite 4, 102 Glebe Road
The Junction, NSW 2291

info@centricengineers.com.au
www.centricengineers.com

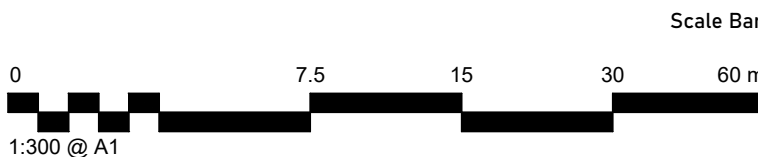



CENTRIC
Building Services Engineers

© **CENTRIC BUILDING SERVICES ENGINEERS PTY LTD**
This drawing is the property of Centric Building Services PTY Limited and must not be used, reproduced or copied wholly or in part without the written permission of Centric Building Services PTY Limited. The elements shown on this drawing are prototypical design only. The contractor shall produce workshop drawings for construction purposes. The contractor shall not scale from this drawing and all measurements shall be carried out on site.

P1 01.04.2025 100% CLIENT REVIEW
P2 30.05.2025 100% FINAL COORDINATION

**100%
ISSUE**

**FIRE
SERVICES**

Project North



Client: VINCENT JARVIS

Project Number: 24071
Drawing Number: FC100
Revision: P2

Drawn by: IB
Designed by: IB
Approved by: JA
Scale: 1:100 @ A1

NEW WAREHOUSE, 39 CERES
DRIVE, THRUGOONA, NSW,2640

LEVEL G FLOOR PLAN FIRE
HYDRANT COVERAGE LAYOUT




Sydney: (02) 9052 6460
Newcastle: (02) 9052 6461



Sydney: Suite 1, 401 Pacific Hwy
Artarmon, NSW 2064
Newcastle: Suite 4, 102 Glebe Road
The Junction, NSW 2291



info@centricengineers.com.au
www.centricengineers.com

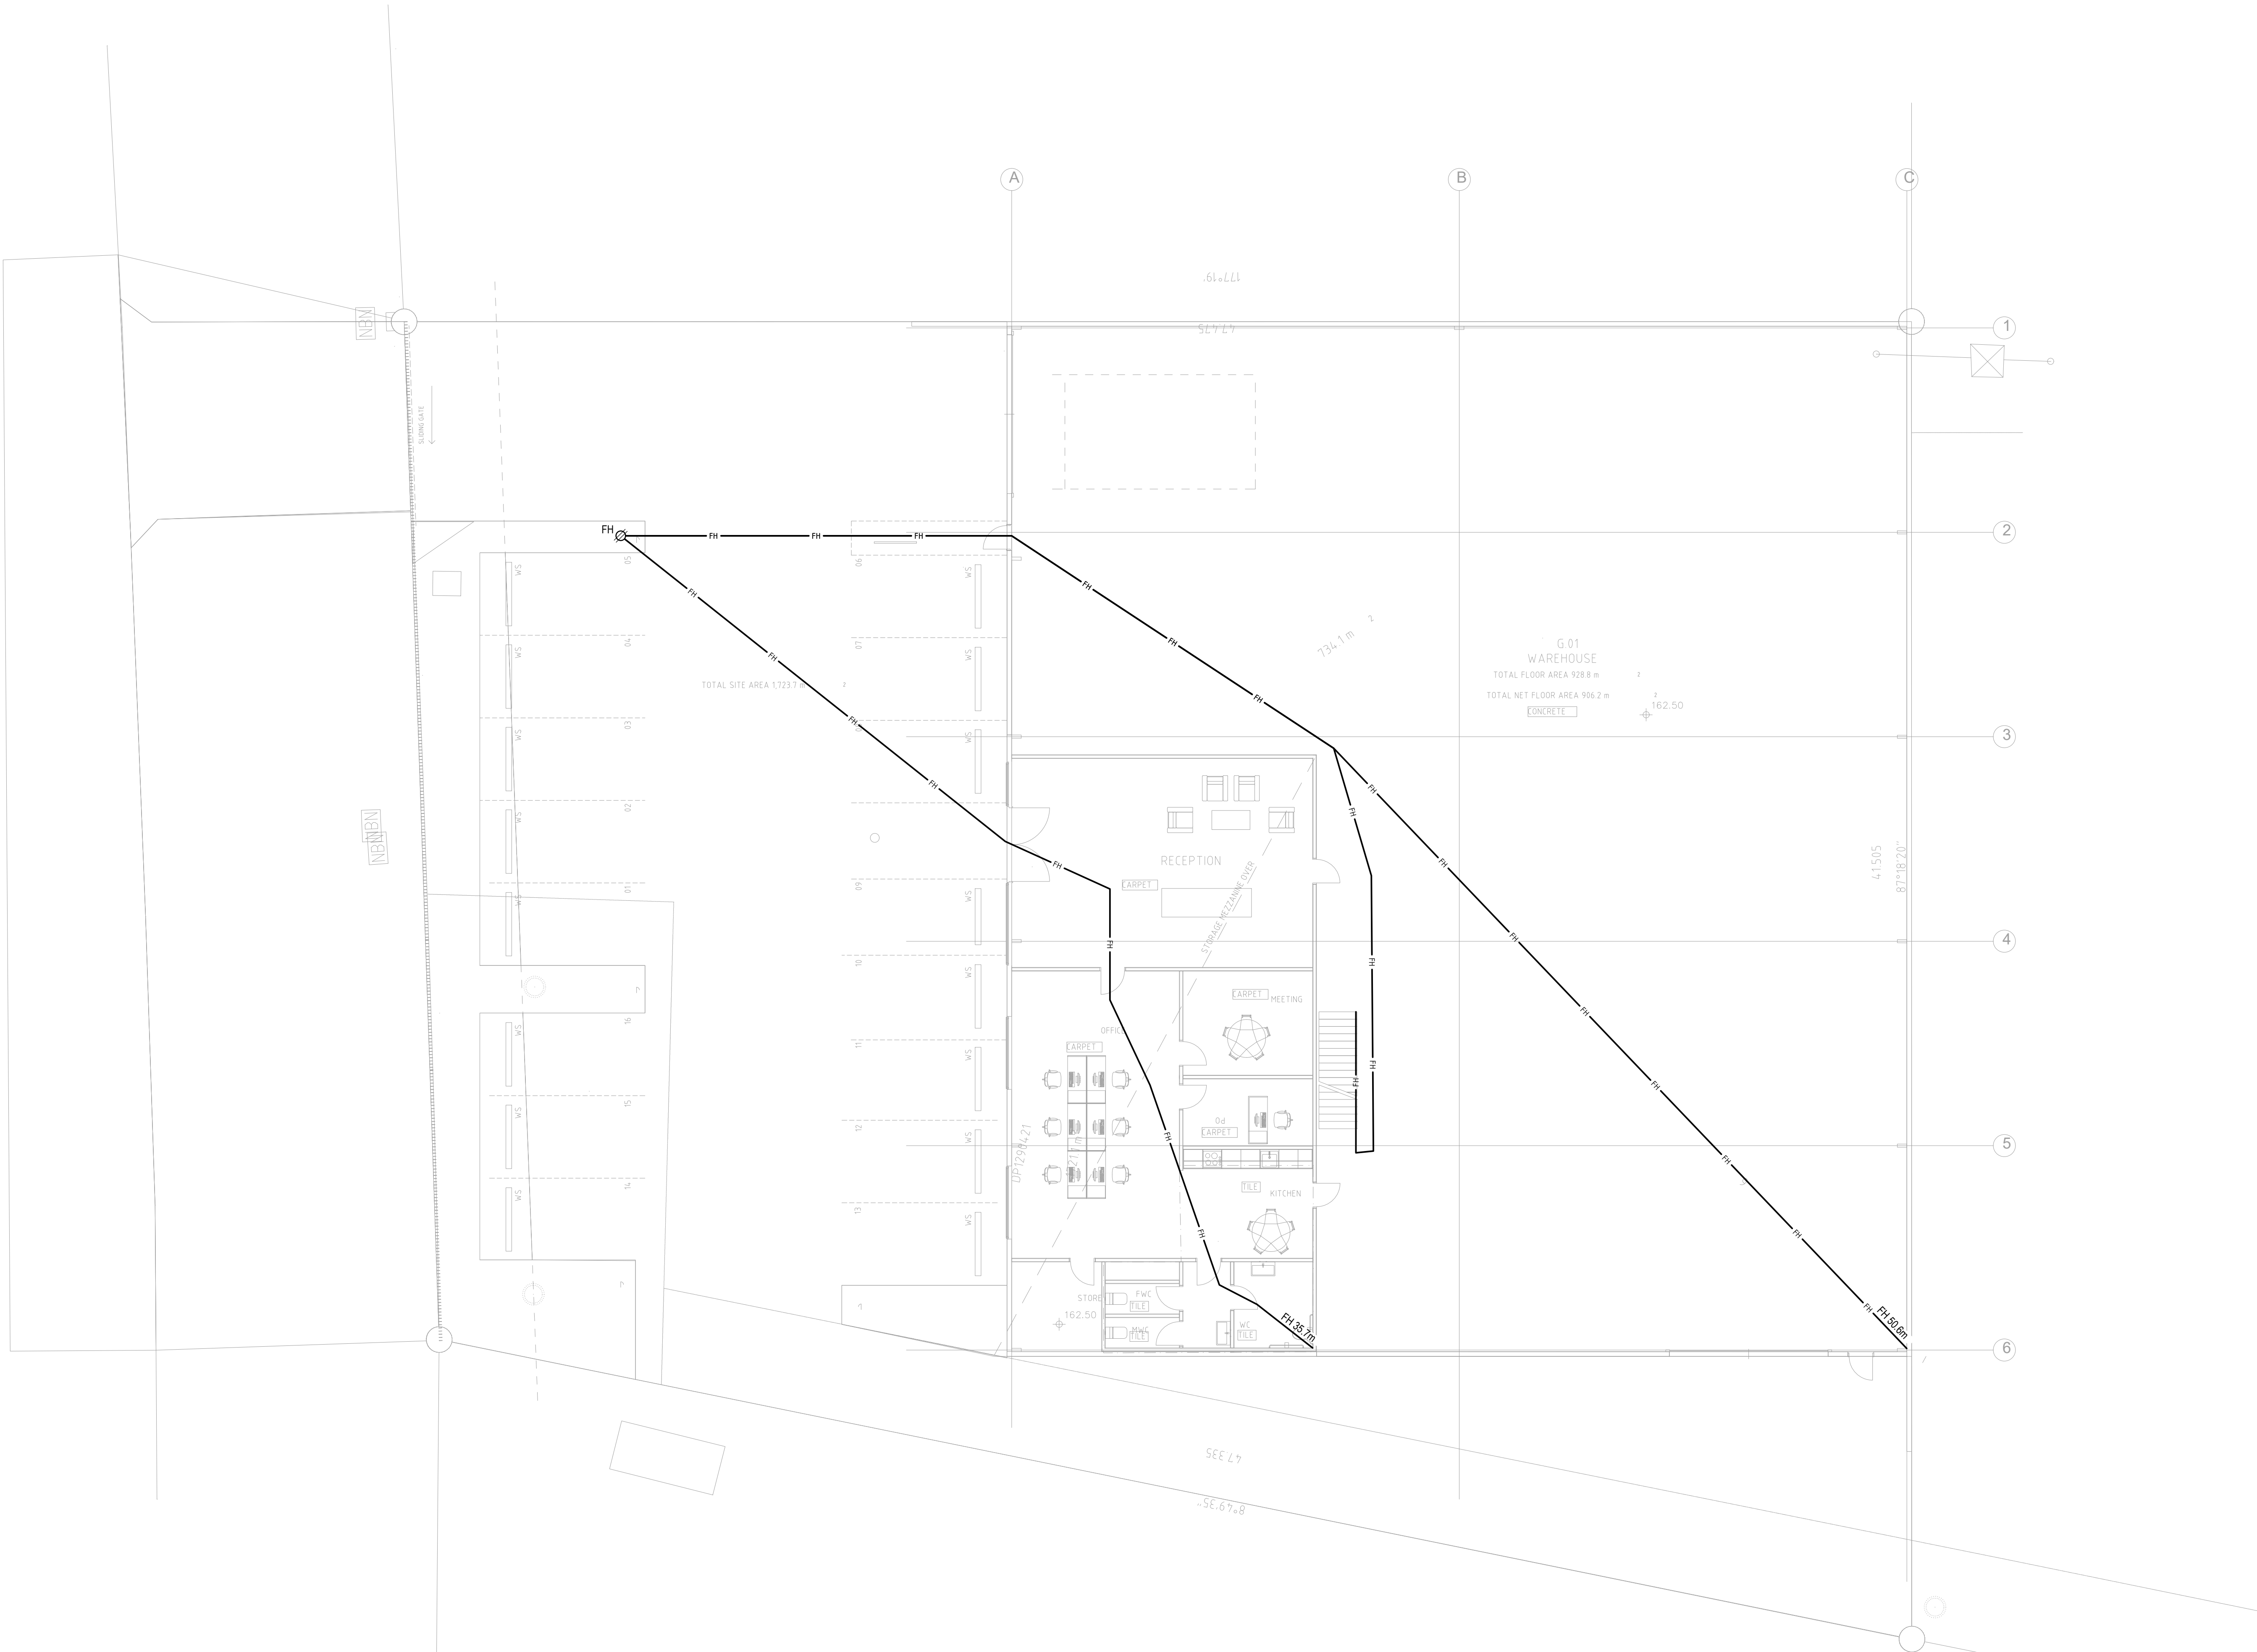

0 2 4 6 8 10 m
1:100 @ A1



© **CENTRIC BUILDING SERVICES ENGINEERS PTY LTD**
This drawing is the property of Centric Building Services PTY Limited and must not be used, reproduced or copied wholly or in part without the written permission of Centric Building Services PTY Limited. The elements shown on this drawing are prototypical design only. The contractor shall produce workshop drawings for construction purposes. The contractor shall not scale from this drawing and all measurements shall be carried out on site.

P1	01.04.2025	100% CLIENT REVIEW
P2	30.05.2025	100% FINAL COORDINATION

**100%
ISSUE**

FIRE SERVICES

Project North



 

 
Client:
Architect: VINCENT JARVIS

Project Number: 24071
Drawing Number: FC101
Revision: P2

Drawn by: IB
Designed by: IB
Approved by: JA
Scale: 1:100 @ A1

NEW WAREHOUSE, 39 CERES
DRIVE, THRUGOONA, NSW, 2640

LEVEL M FLOOR PLAN FIRE
HYDRANT COVERAGE LAYOUT

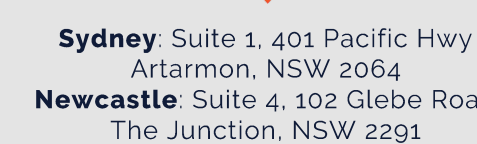



CENTRIC
Building Services Engineers

© **CENTRIC BUILDING SERVICES ENGINEERS PTY LTD**
This drawing is the property of Centric Building Services PTY Limited and must not be used, reproduced or copied wholly or in part without the written permission of Centric Building Services PTY Limited. The elements shown on this drawing are prototypical design only. The contractor shall produce workshop drawings for construction purposes. The contractor shall not scale from this drawing and all measurements shall be carried out on site.

P1 01.04.2025 100% CLIENT REVIEW
P2 30.05.2025 100% FINAL COORDINATION

**100%
ISSUE**

**FIRE
SERVICES**

Project North



Client: VINCENT JARVIS
Architect:

Project Number: 24071
Drawing Number: FC200
Revision: P2

Drawn by: IB
Designed by: IB
Approved by: JA
Scale: 1:100 @ A1

NEW WAREHOUSE, 39 CERES
DRIVE, THRUGOONA, NSW,2640

LEVEL G FLOOR PLAN FIRE HOSE
REEL COVERAGE LAYOUT




Sydney: (02) 9052 6460
Newcastle: (02) 9052 6461



Sydney: Suite 1, 401 Pacific Hwy
Artarmon, NSW 2064
Newcastle: Suite 4, 102 Glebe Road
The Junction, NSW 2291



info@centricengineers.com.au
www.centricengineers.com

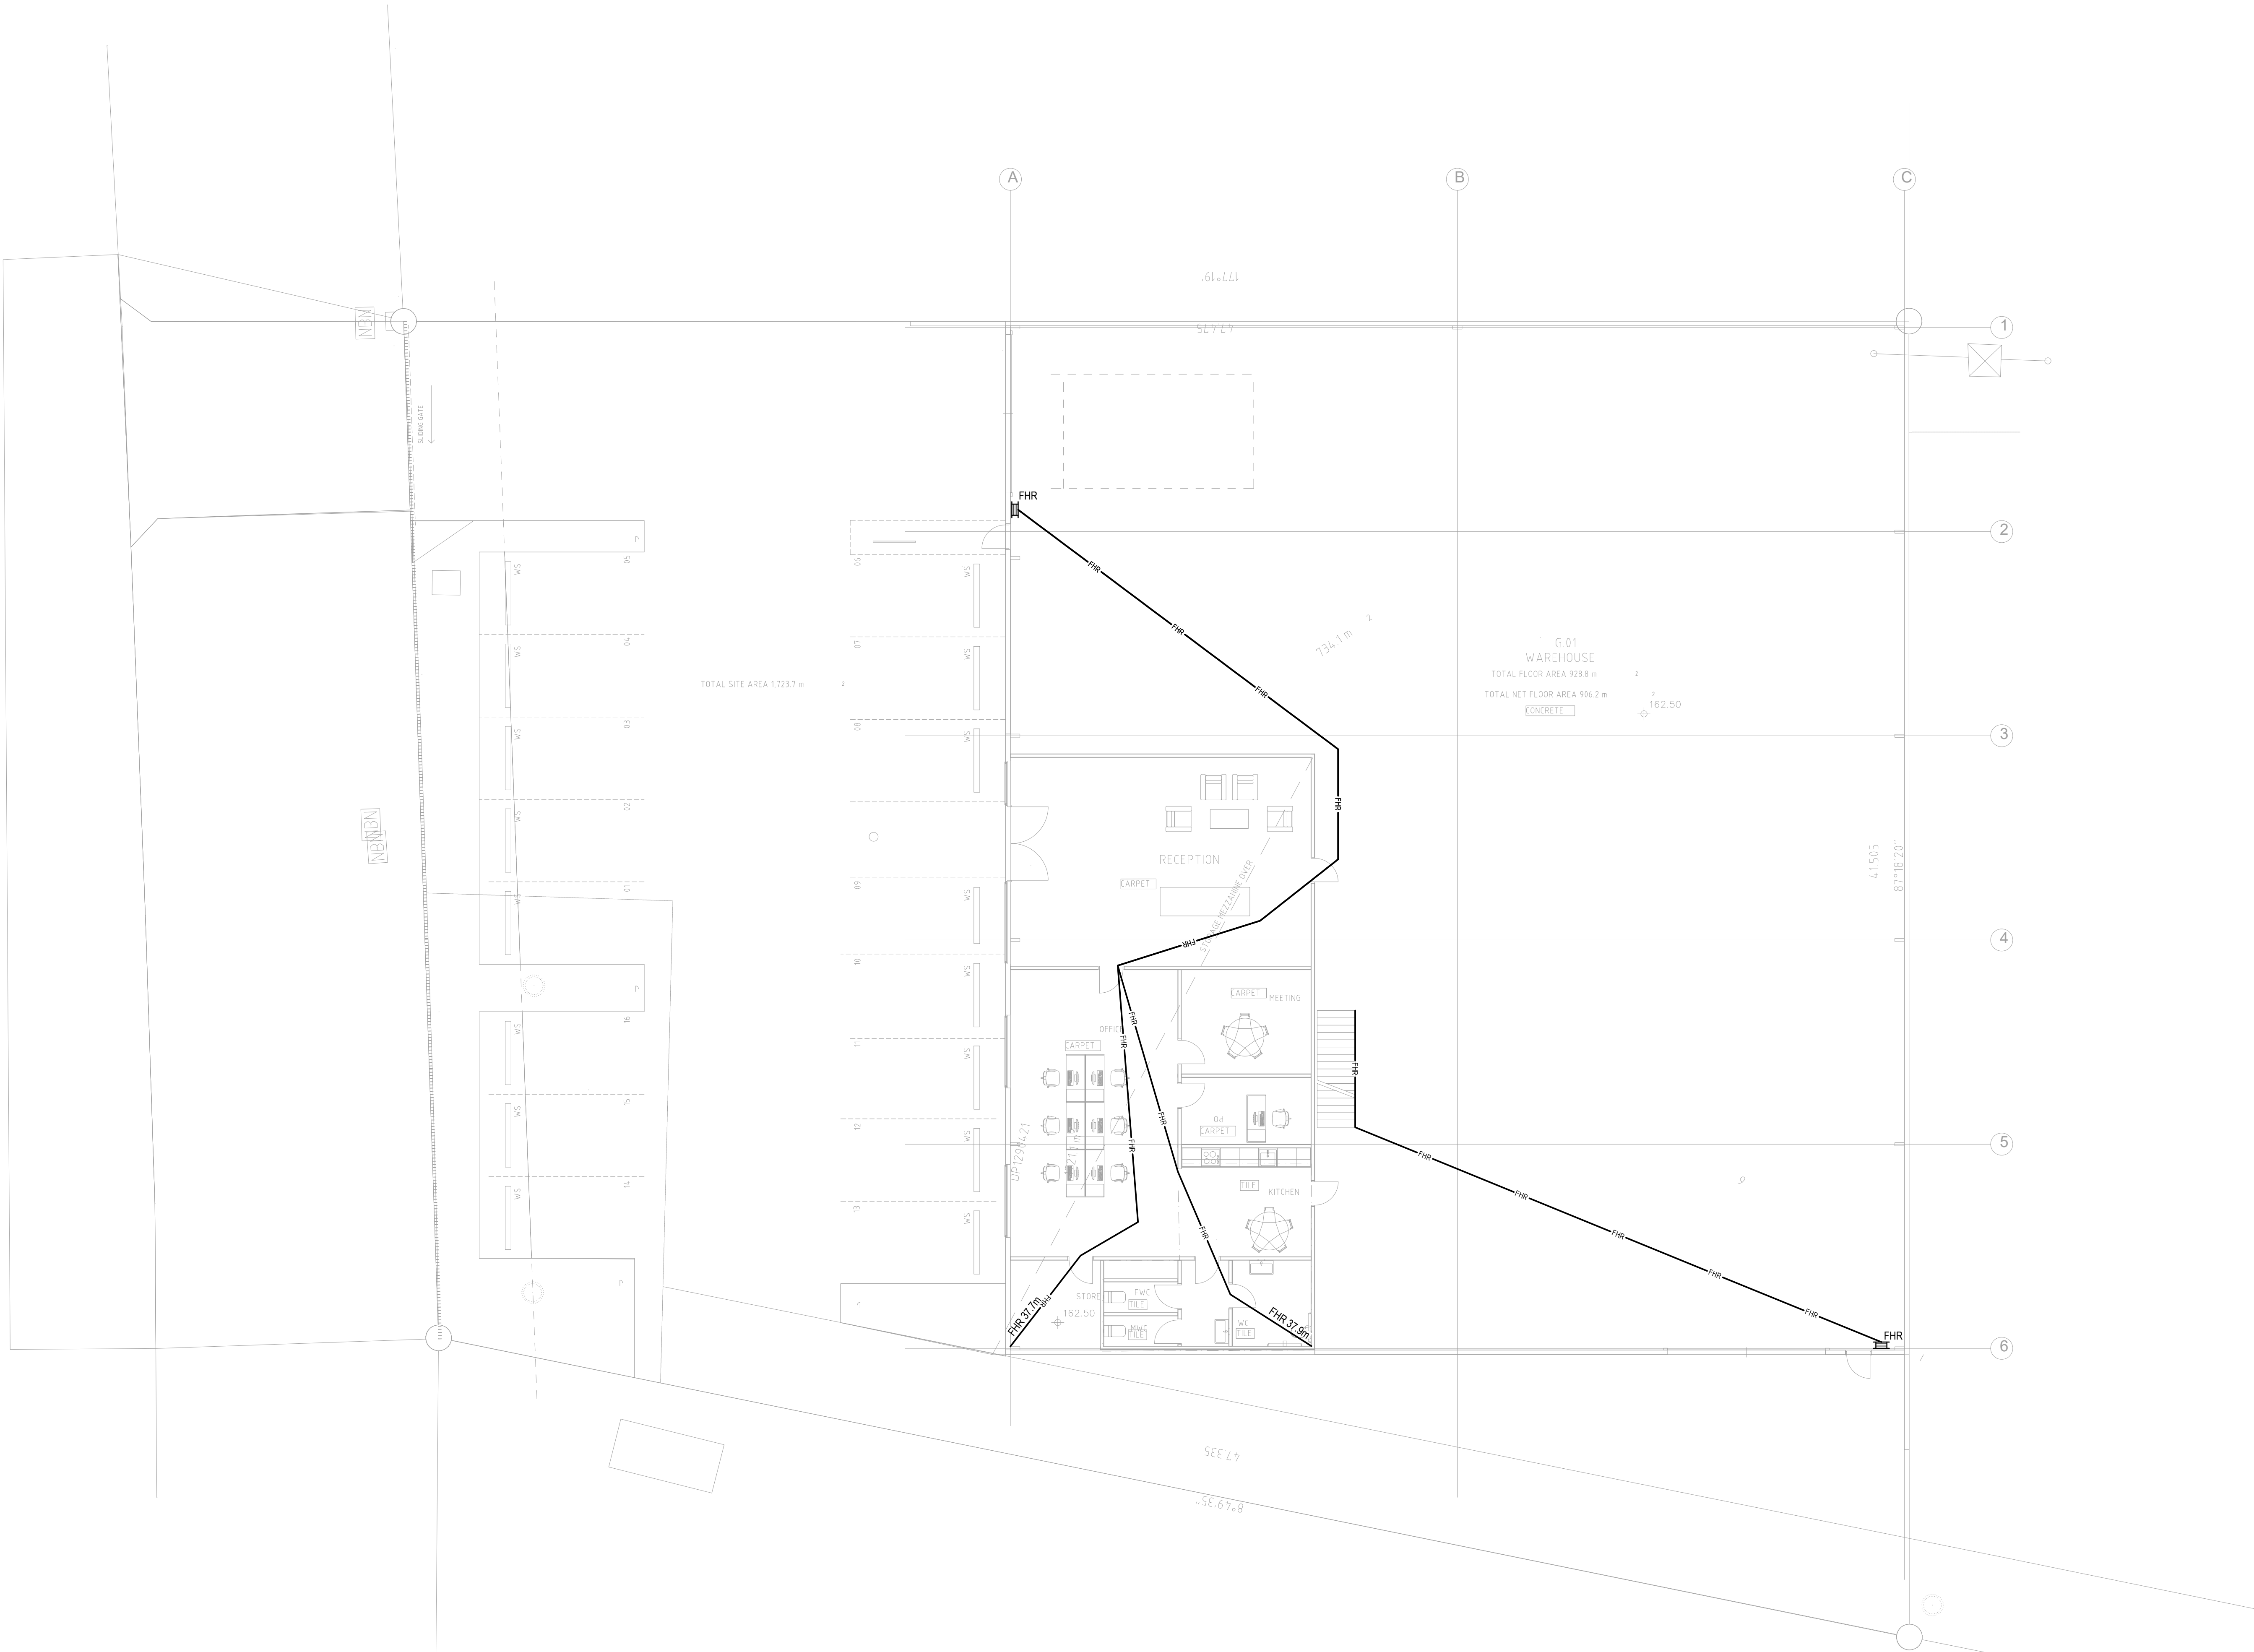



CENTRIC
Building Services Engineers

© **CENTRIC BUILDING SERVICES ENGINEERS PTY LTD**
This drawing is the property of Centric Building Services PTY Limited and must not be used, reproduced or copied wholly or in part without the written permission of Centric Building Services PTY Limited. The elements shown on this drawing are prototypical design only. The contractor shall produce workshop drawings for construction purposes. The contractor shall not scale from this drawing and all measurements shall be carried out on site.

P1 01.04.2025 100% CLIENT REVIEW
P2 30.05.2025 100% FINAL COORDINATION

100%
ISSUE

FIRE
SERVICES

Project North




Client:
Architect: VINCENT JARVIS

Project Number: 24071
Drawing Number: FC201
Revision: P2

Drawn by: IB
Designed by: IB
Approved by: JA
Scale: 1:100 @ A1

NEW WAREHOUSE, 39 CERES
DRIVE, THRUGOONA, NSW,2640

LEVEL M FLOOR PLAN FIRE HOSE
REEL COVERAGE LAYOUT

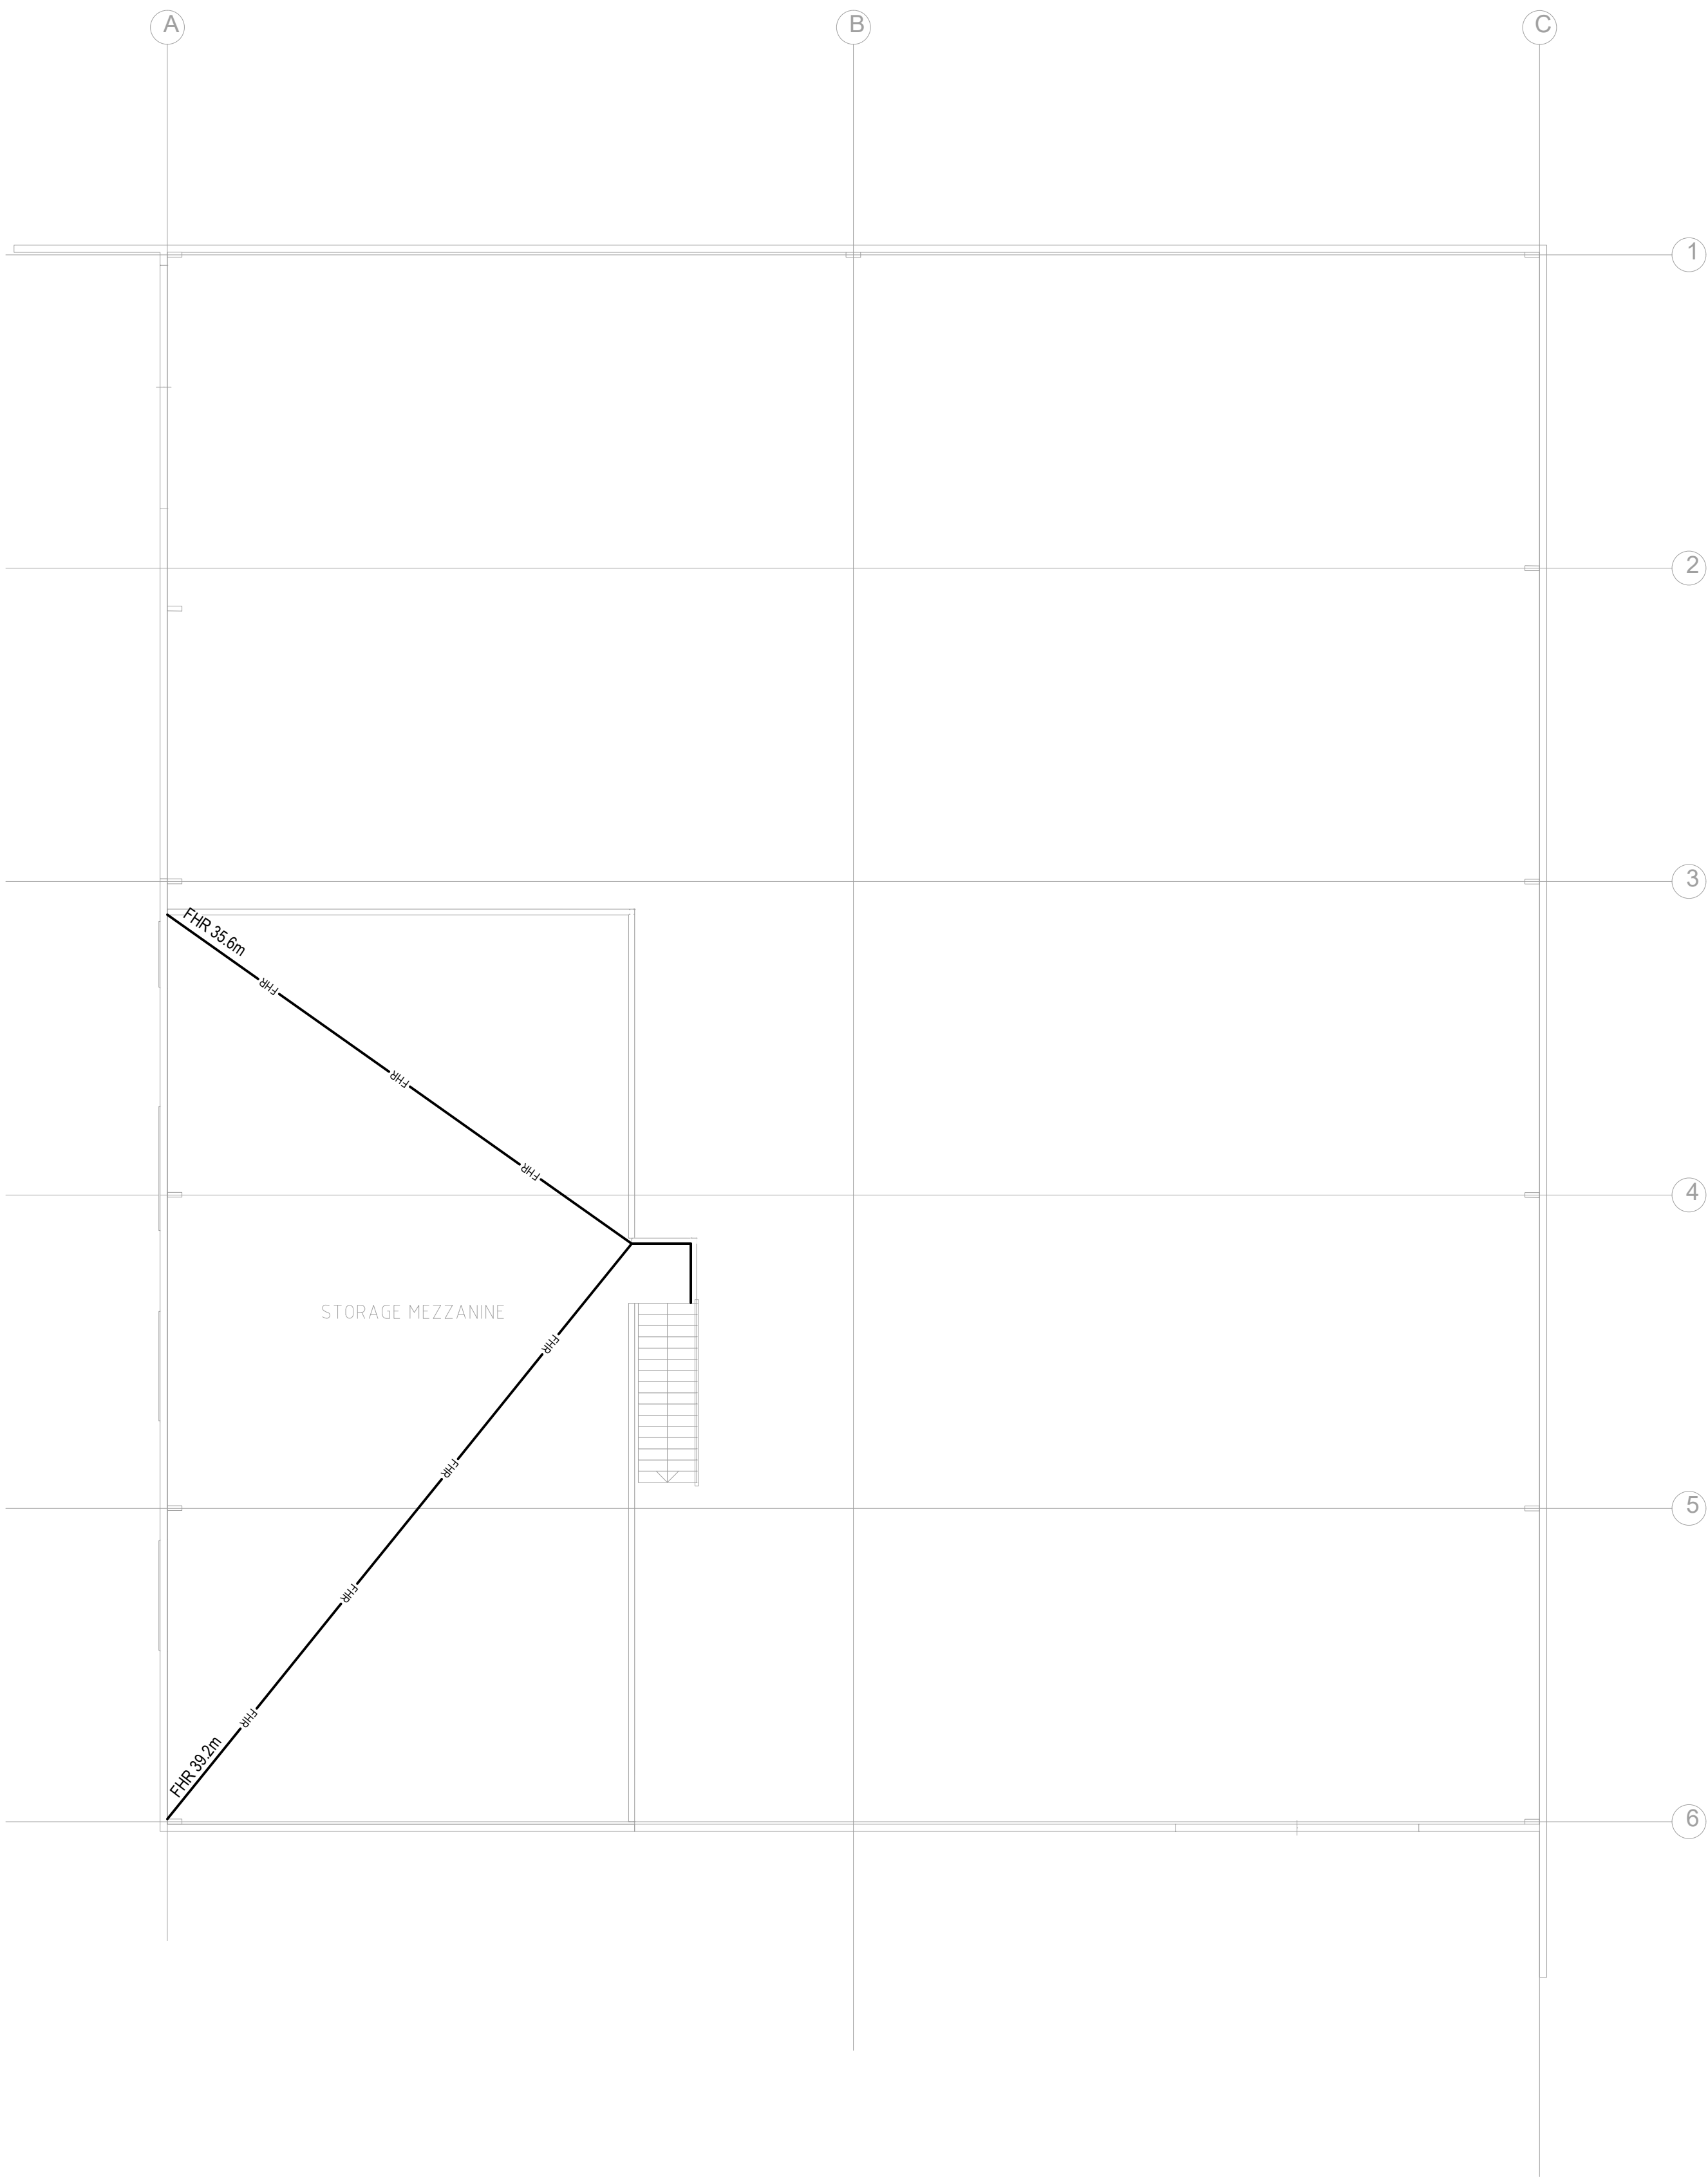

Sydney: (02) 9052 6460
Newcastle: (02) 9052 6461



Sydney: Suite 1, 401 Pacific Hwy
Artarmon, NSW 2064
Newcastle: Suite 4, 102 Glebe Road
The Junction, NSW 2291



info@centricengineers.com.au
www.centricengineers.com



DOCUMENT REGISTER & TRANSMITTAL NOTICE



Centric Building Services Engineers Pty Ltd
 Sydney: Suite 1, 401 Pacific Hwy, Artarmon, NSW 2064
 Newcastle: Suite 4, 102 Glebe Road, The Junction, NSW, 2291
 Sydney: +61 - (02) 9052 6460 | Newcastle: +61 - (02) 9052 6461
info@centricengineers.com.au
www.centricengineers.com.au

Job Title: NEW WAREHOUSE
Address: 39 CERES DRIVE THRU GOONA NSW 2640
Job No: 24071
Discipline: Fire Coverage

[illegible]