


CEILING MOUNTING BLOCKS

Profiled circular timber blocks are available from ARCPANEL to mount downlights, pendant lights, ceiling fans, chandeliers etc. They are available in x2 sizes - Ø140mm & Ø170mm. The mounting blocks are supplied in natural finished timber. They can be painted or oiled to suit application.


Method of install:

- Light weight lighting and fans (up to 20kg), two toggle bolts are used to secure the mounting block to the underside of the ceiling.
- For heavier items such as large ceiling fans and large pendant lighting (up to 40kg) the block is to be bolted through the panel, using a standard T17 14-10 screw fitted with a cyclone plate, washer and seal.
- Sikaflex or similar applied to underside of mounting block.

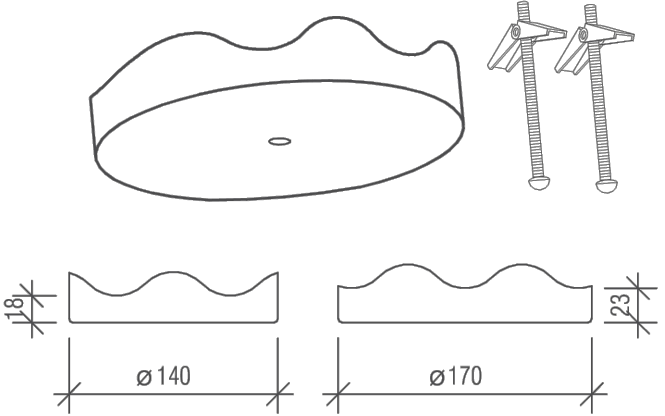

RECOMMENDED ARCPANEL FIXING FOR CABLE TRAY

NTS

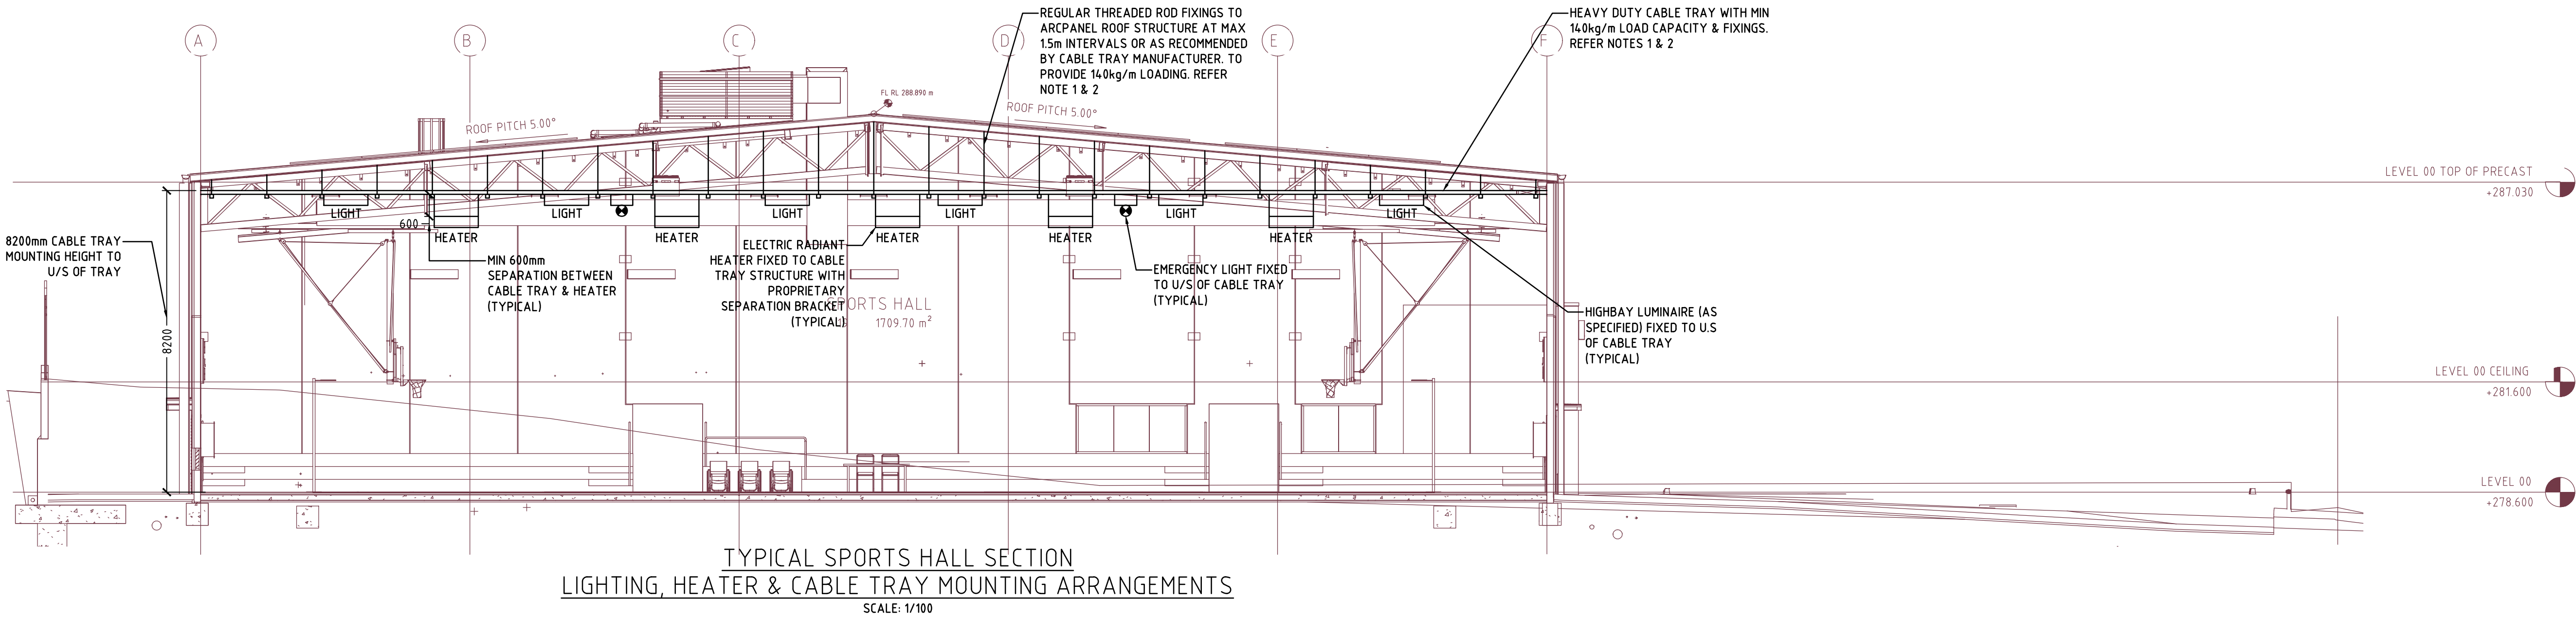



CONTRACTORS MUST VERIFY ALL DIMENSIONS ON SITE BEFORE COMMENCING ANY WORK OR PREPARING SHOP DRAWINGS

All Architectural drawing sheets to be cross-referenced with other relevant disciplines.

Rev	Description	Date
A	TENDER ISSUE	05.06.25

NOTES:

- ALL EXPOSED CABLE TRAY TO BE USED IN THE SPORTS HALL AREA SHALL BE PROVIDED WITH WHITE POWDERCOAT FINISH & SHALL BE SIMILAR TO EZYSTRUT ET3 CABLE TRAY WITH MIN 140kg/m RATING
- ALL CABLE TRAY SHALL UTILISE ROOF PERLINS FOR FIXING TO ARCPANEL ROOF STRUCTURE WHERE AVAILABLE & SHALL UTILISE ARCPANEL HARDWOOD CEILING MOUNTING KIT FOR ALL INTERMEDIATE FIXINGS DIRECTLY TO ARCPANEL ROOFING. REFER TO TYPICAL FIXING DETAIL INFORMATION & ARCPANEL MANUFACTURERS RECOMMENDATIONS

CONSULTANT 1:  SPECTRUM ENGINEERING SOLUTIONS 1 Davis Place Glenhaven NSW 2156 Phone: (02) 8650 4802 Mobile: 0411 214 633 Email: nat@spectrumengineering.com.au	
 FACILITY DESIGN GROUP Architecture & Construction NEW Reg. No. 7148 ABN: 75 583 994 624 E: info@fdg.com.au W: www.fdg.com.au P: (02) 4446 0777 P: PO Box 65, Combarwara NSW 2540	
CLIENT: SNOWY VALLEYS COUNCIL	
PROJECT NAME: MULTI PURPOSE PLUS EVACUATION CENTRE	
PROJECT ADDRESS: Lot 1, Section 81 DP 759004 & Lot 701 DP 1059193 RICHMOND PARK, TUMUT NSW	
DRAWING TITLE: ELECTRICAL SERVICES ELECTRICAL DETAILS SHEET No 1	
B1 PRINT SIZE	
SHEET ISSUE DATE: 24.02.2025 REVISION DATE:	DRAWING NO. REV.
SCALE: 1:100 @ B1	E-05 A
JOB NO.: 22-076	
DRAWN BY: JDC	CHECKED BY: NC