


CONTRACTORS MUST VERIFY ALL DIMENSIONS ON SITE BEFORE COMMENCING ANY WORK OR PREPARING SHOP DRAWINGS

All Architectural drawing sheets to be cross-referenced with other relevant disciplines.

Rev	Description	Date
A	ISSUED FOR TENDER	23.04.25
B	TENDER ISSUE	29.05.25
C	TENDER ISSUE	05.06.25

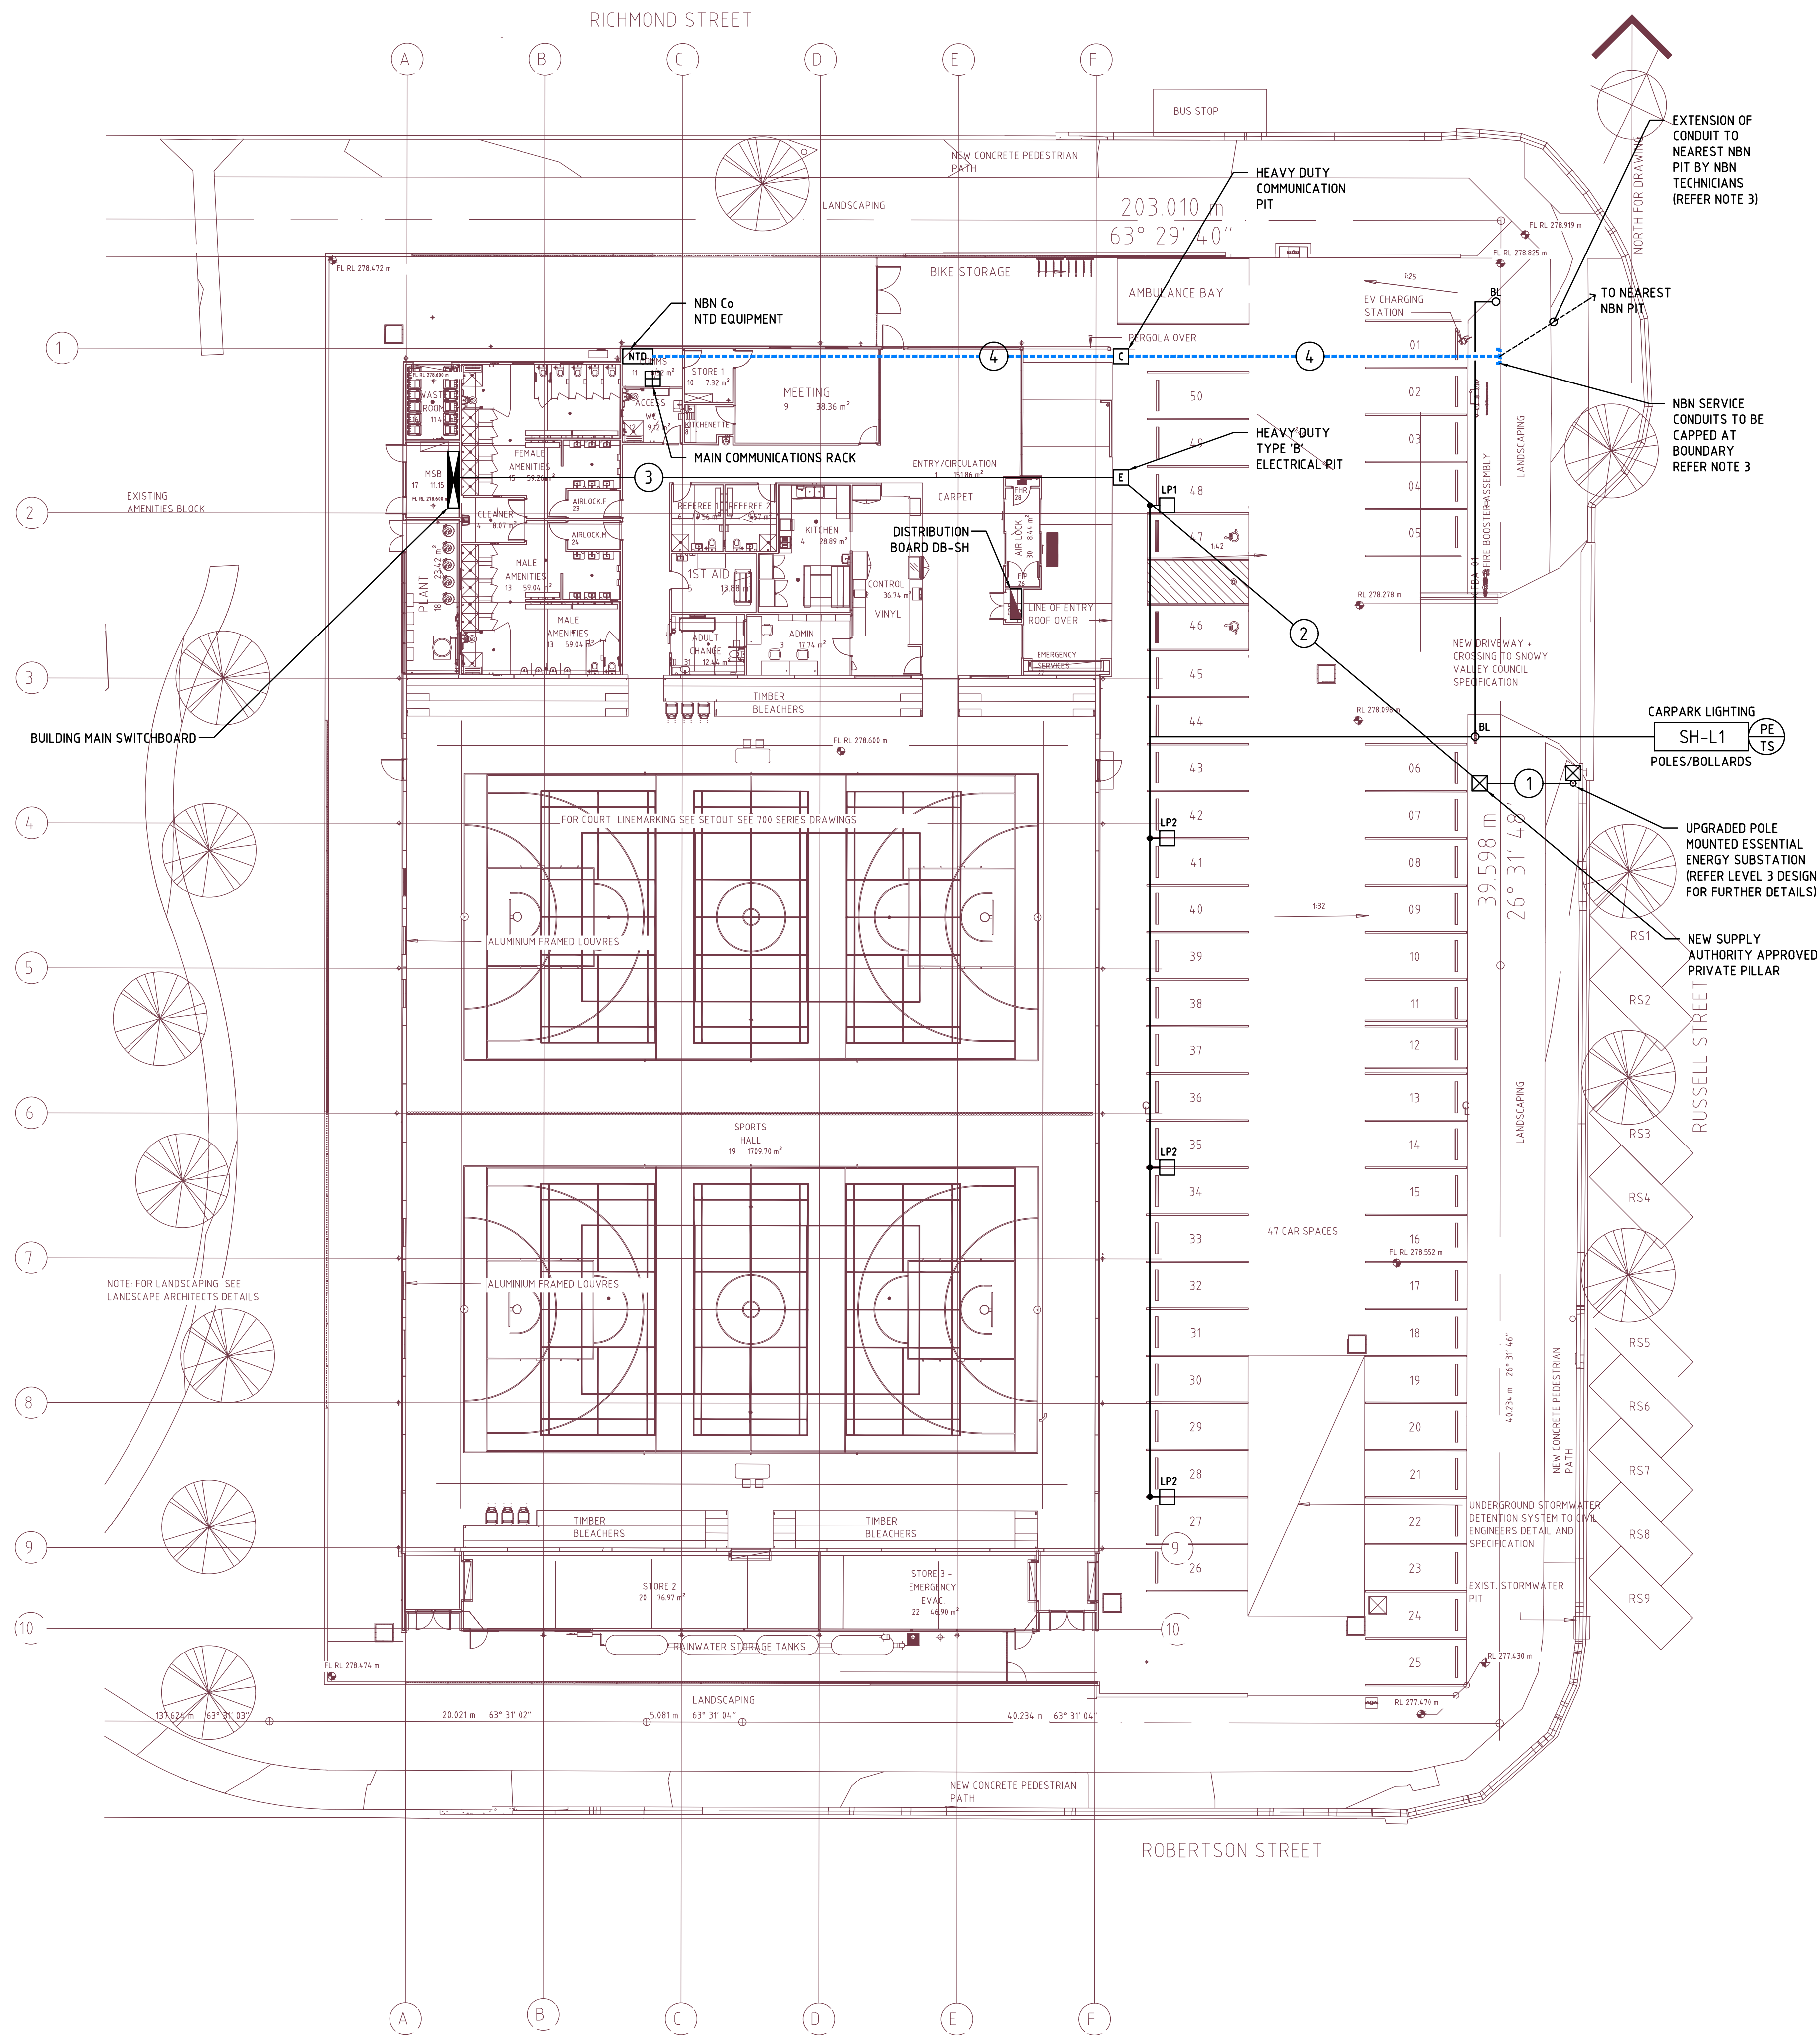

SITE SERVICES SCHEDULE	
SERVICE No.	DESCRIPTION
1	NEW 400A U/G SERVICES MAINS INSTALLED BY CERTIFIED LEVEL 2 CONTRACTOR IN U/G CONDUIT
2	3 x 125mmØ ORANGE HDUPVC CONDUITS
3	3 x 125mmØ & 2 x 50mmØ ORANGE HDUPVC CONDUIT
4	2 x 50mmØ WHITE HDUPVC CONDUITS FOR NBN SERVICE CABLE

NOTES:

- THE CONTRACTOR SHALL NOTE THAT THE USE OF SURFACE CONDUIT & DUCTING SHALL NOT BE PERMITTED WITHOUT PRIOR APPROVAL OF THE SUPERINTENDANT. ALL CABLING RUNS SHALL BE HIDDEN, INTEGRATED INTO BUILDING STRUCTURE OR INSTALLED ON CABLE TRAY UNLESS APPROVED OTHERWISE.
- CABLE TRAYS SHALL BE HEAVY GALVANISED STEEL AND PROVIDED WITH WHITE POWDERCOAT FINISH IN ALL VISIBLE AREAS OF THE BUILDING.
- NBN SERVICE CONDUITS SHALL BE CAPPED AT SITE BOUNDARY & PROTECTED FROM DAMAGE. EXTENSION OF CONDUITS TO EXISTING NBN NETWORK SHALL BE UNDERTAKEN BY NBN TECHNICIANS

CONSULTANT 1:
SPECTRUM
ENGINEERING SOLUTIONS
1 Davis Place
Glenhaven NSW 2156
Phone: (02) 8650 4802
Mobile: 0411 294 633
Email: nat@spectrumsolutions.com.au

FACILITY DESIGN GROUP
Architecture & Construction
NEW Reg. No. 7168
ABN: 75 583 999 624
E: info@fdg.com.au
W: www.fdg.com.au
P: 02 4446 0777
P: 02 4446 0777
PO Box 65
Cambera NSW 2540

CLIENT:
SNOWY VALLEYS COUNCIL

PROJECT NAME:
MULTI PURPOSE PLUS
EVACUATION CENTRE

PROJECT ADDRESS:
Lot 1, Section 81 DP 759004 & Lot 701 DP 1059193
RICHMOND PARK, TUMUT NSW

DRAWING TITLE: ELECTRICAL SERVICES
**SITE SERVICES & CARPARK
LIGHTING LAYOUT**

SHEET ISSUE DATE: 24.02.2025		DRAWING NO. REV.	
REVISION DATE:		E-200	C
SCALE: 1:200 @ B1			
JOB NO.: 22-076			
DRAWN BY: JDC		CHECKED BY: NC	