


WODONGA TAFE LOGICAL INNOVATIONS

45 ALBERTSON ROAD BARNAWARTHA NORTH VIC 3691 AUSTRALIA

ELECTRICAL SERVICES

ELECTRICAL SERVICES

- E001 DRAWING REGISTER & SITE LOCALITY PLAN
- E002 GENERAL NOTES & LEGEND
- E003 SITE PLAN
- E004 ELECTRICAL & COMMUNICATION SITE RETICULATION
- E005 SITE MAIN SWITCHBOARD SCHEMATIC
- E100 HEAVY VEHICLE WORKSHOP EXISTING & PROPOSED SITE PLAN LAYOUT
- E101 HEAVY VEHICLE WORKSHOP GROUND & MEZZANINE POWER LAYOUT
- E102 HEAVY VEHICLE WORKSHOP GROUND & MEZZANINE LIGHTING LAYOUT
- E103 HEAVY VEHICLE WORKSHOP ROOF LAYOUT
- E104 HEAVY VEHICLE WORKSHOP SWITCHBOARD SCHEMATIC
- E200 CLIENT BUILDING PROPOSED SITE PLAN LAYOUT
- E201 CLIENT BUILDING GROUND FLOOR POWER LAYOUT
- E202 CLIENT BUILDING FIRST FLOOR POWER LAYOUT
- E203 CLIENT BUILDING GROUND FLOOR LIGHTING LAYOUT
- E204 CLIENT BUILDING FIRST FLOOR LIGHTING LAYOUT
- E205 CLIENT BUILDING ROOF LAYOUT
- E206 CLIENT BUILDING SWITCHBOARD SCHEMATIC & DETAILS

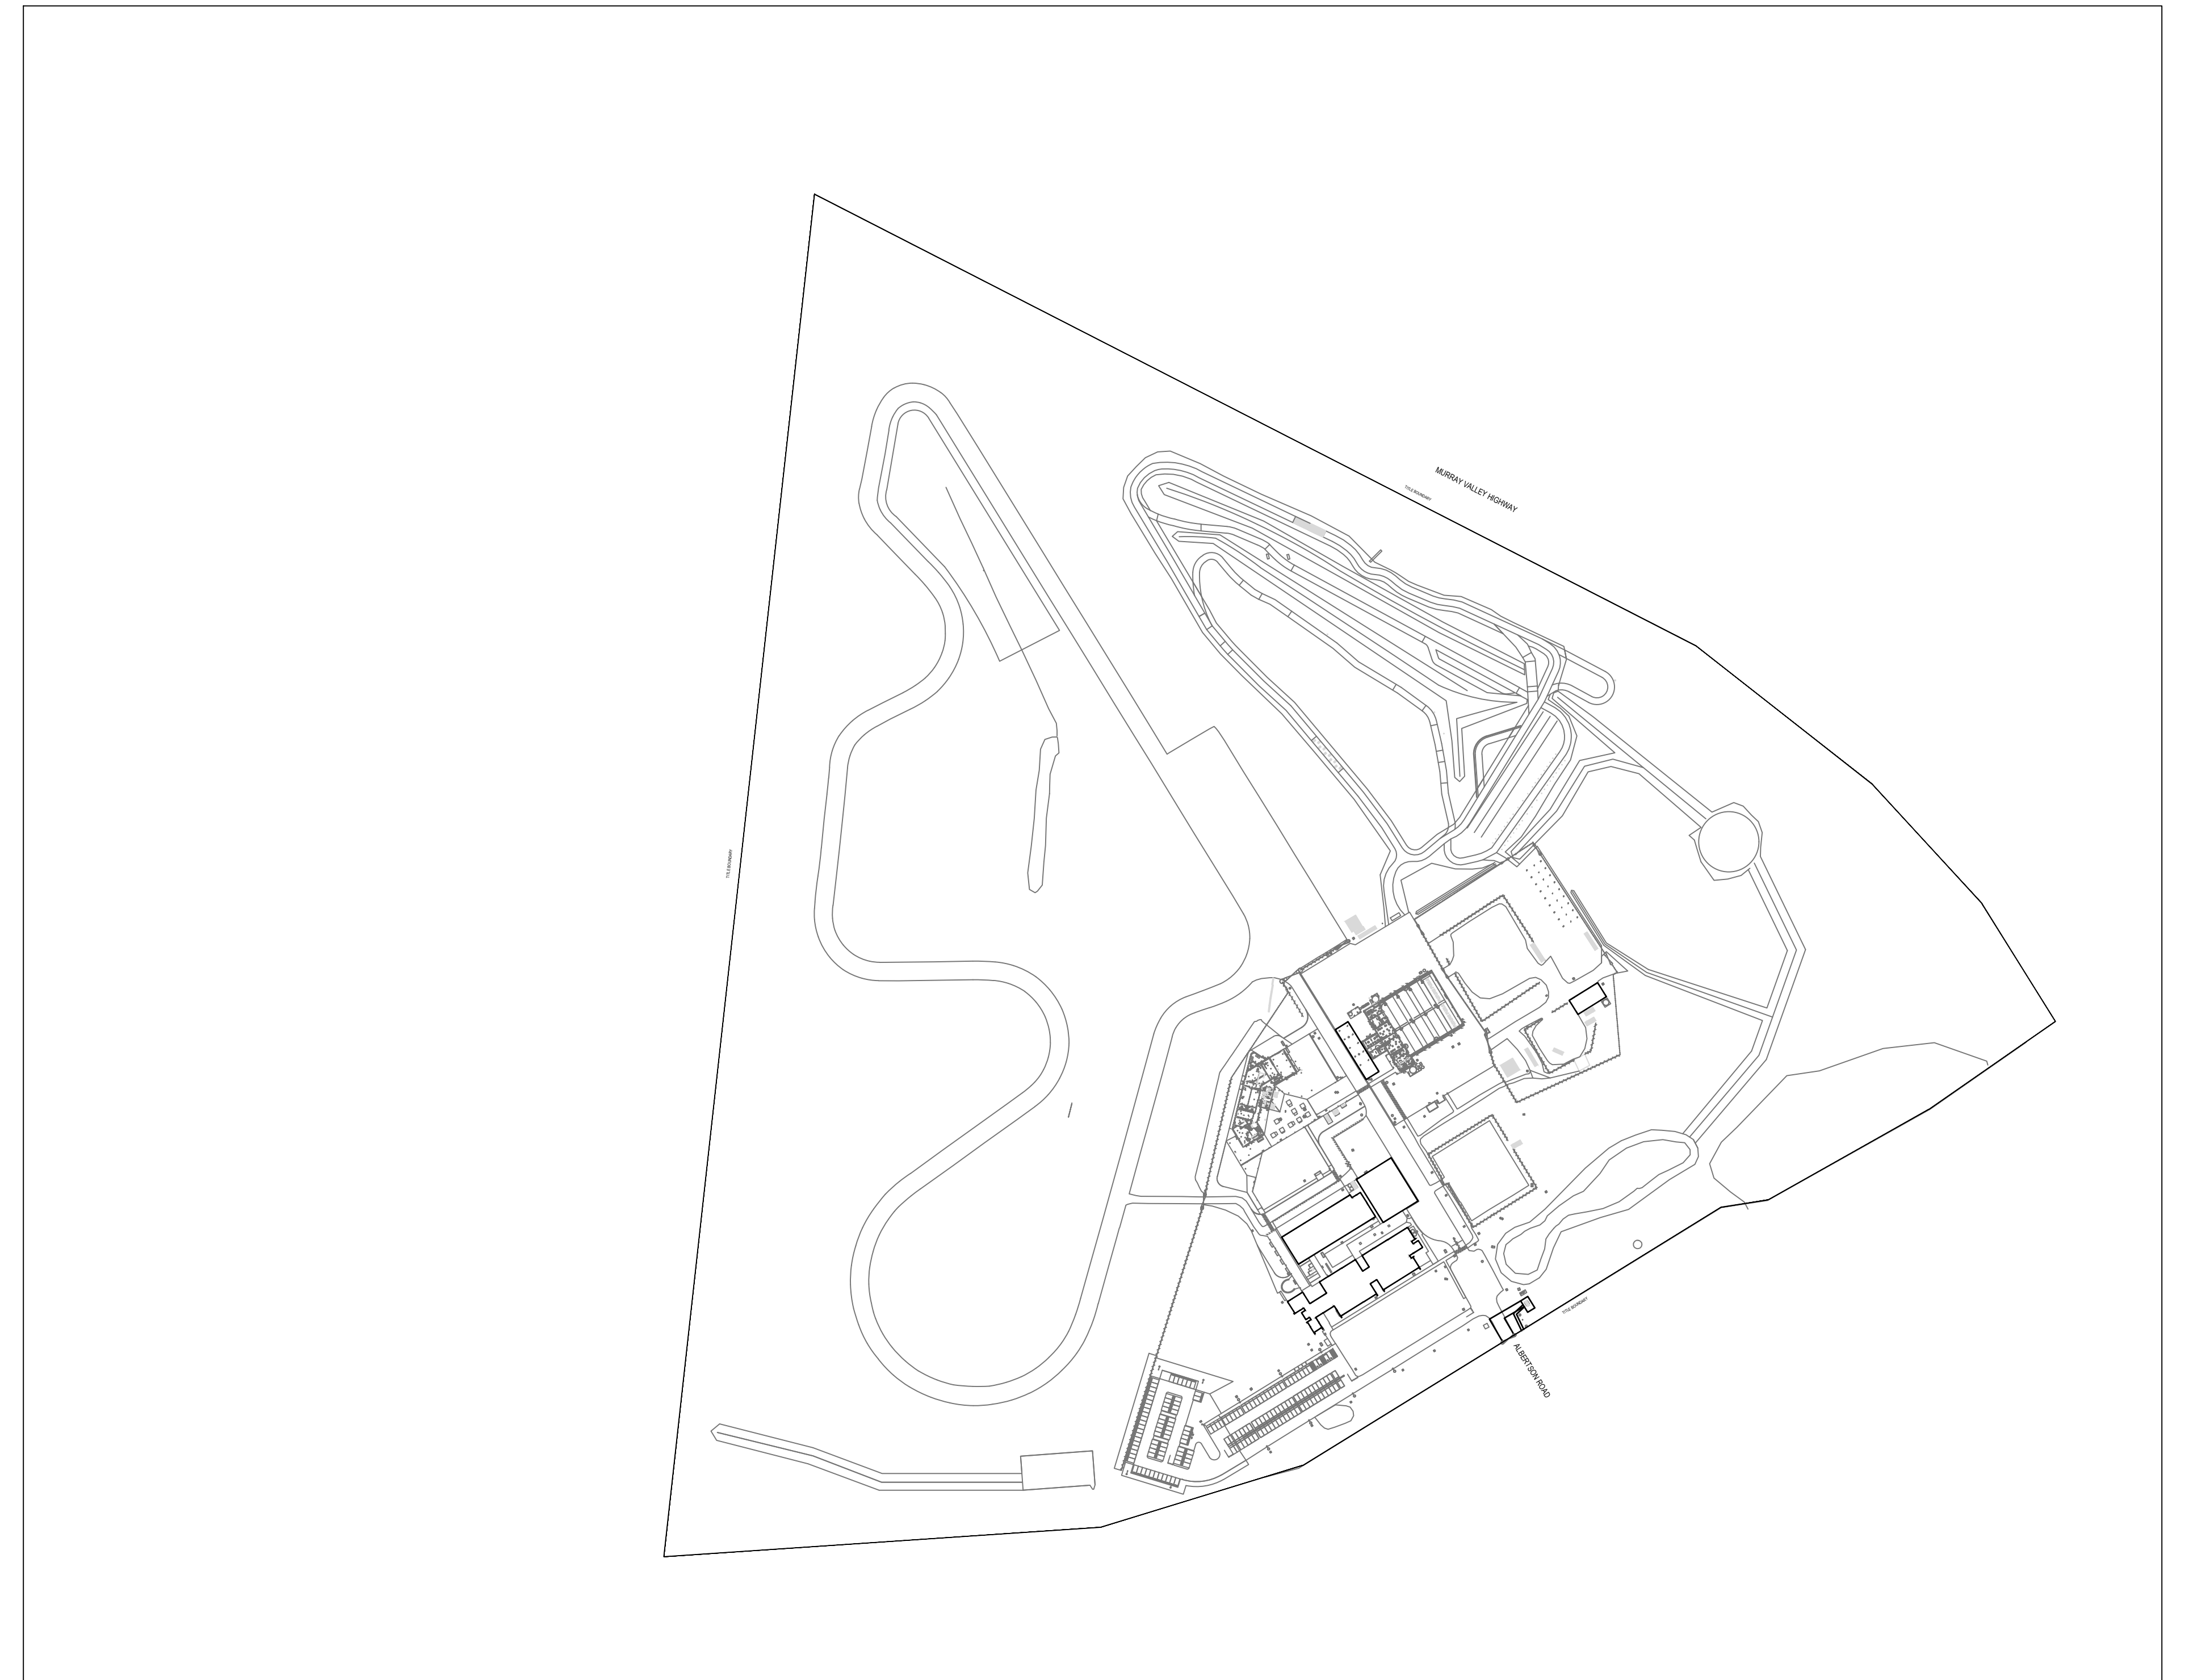

LOCALITY PLAN

REV	DATE	DESCRIPTION	INITIALS
DD-A	18.09.2024	DESIGN DEVELOPMENT - PAGE TURN ISSUE	M.G.
DD-B	23.09.2024	DESIGN DEVELOPMENT - PAGE TURN ISSUE	M.G.
DD-C	26.09.2024	DESIGN DEVELOPMENT - PAGE TURN ISSUE	M.G.
TD-A	06.09.2024	TENDER DOCUMENTATION ISSUE	M.G.
TD-B	13.09.2024	TENDER DOCUMENTATION ISSUE	M.G.
TD-C	03.10.2024	TENDER DOCUMENTATION ISSUE	M.G.

© JBA Consulting Engineers Pty Ltd. This document is copyright and is not to be reproduced or copied in whole or in part without prior written approval from JBA. It is confidential, not subject to public release, design, patent, copyright or other intellectual property rights, and its use is limited to the project for which it was prepared. All Rights Reserved.

JBA smarter engineering
phone (03) 9646 9144 web www.jba.com.au

CLIENT
WODONGA TAFE LOGICAL INNOVATIONS

ARCHITECT
ds architects
03 9438 2414
1/100 Glenelg Street
Hawthorn East Victoria 3123
+61 (0)3 9438 2414
www.dsarch.com.au

PROJECT
WODONGA TAFE LOGICAL INNOVATIONS
45 ALBERTSON ROAD BARNAWARTHA
NORTH VIC 3691 AUSTRALIA

SERVICE
ELECTRICAL SERVICES
TITLE
DRAWING REGISTER & SITE LOCALITY PLAN

DESIGNED	DRAWN	PROJECT LEADER
R.LAU	M.GUNASINGHE	G.KENNETT
SCALE @ A0	COMMENCED DATE	SHEET NUMBER
N.T.S	JULY 2024	1 of 16

TENDER
NOT FOR CONSTRUCTION

PROJECT NUMBER	DRAWING NUMBER	REVISION
4849	E001	TD-C